


Use figured dimensions only. Do not scale from drawing.
 All levels and dimensions are to be checked on site.
 This drawing is to be read in conjunction with all relevant documents

NOTES

Legend

- Proposed New Drainage
- Existing Drainage to be Blocked Off
- \rightarrow Direction of surface water flow

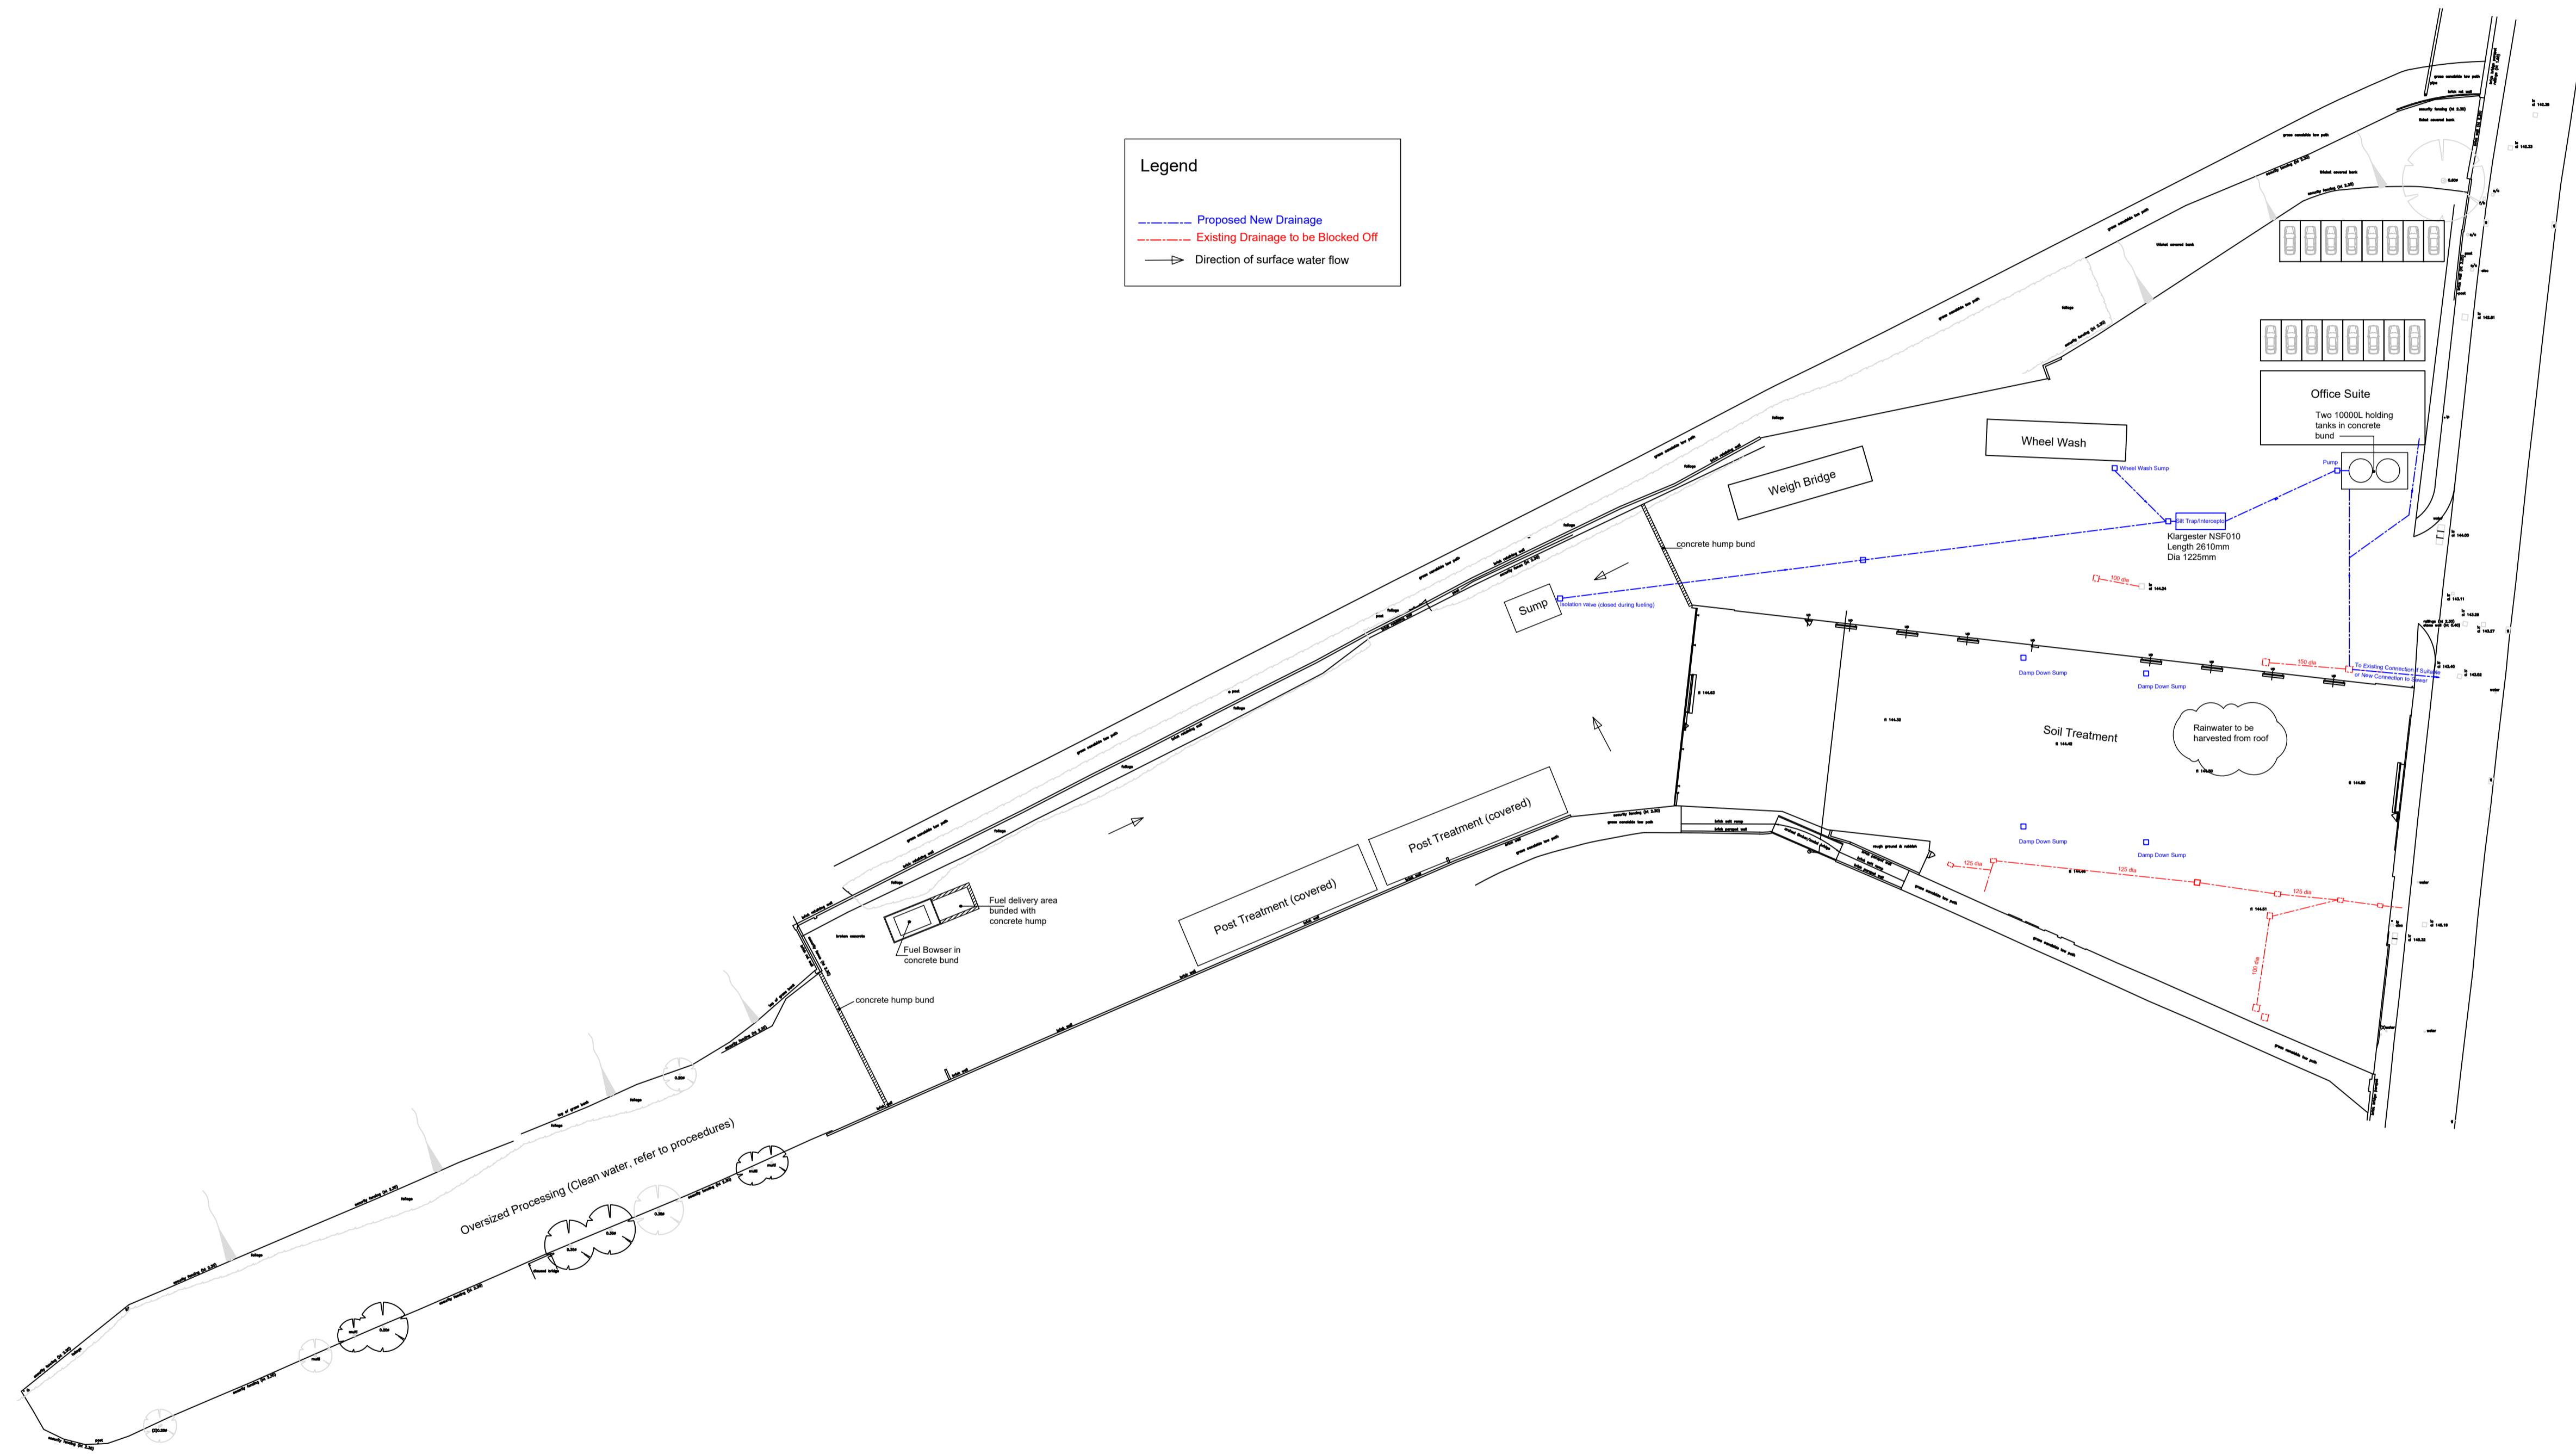

PRELIMINARY

Rev.	Date	Revision
B	03/11/22	revised to suit Rambol requirements
A	10/10/22	Sump and Bowser added

Dunton Technology

Soil Treatment Plant
 Bridge Street North

Drainage Layout Plan

Sean M Fitzpatrick BSC CEng MStructE
 Consulting Engineer

Sf

40 Measham Road
 Acresford,
 DE12 8AJ

email: structfz@btinternet.com
 tel: 07956 851595

Drawn by: SMF Date: 04/10/22

Scale: 1:500 @ A1

Drawing No. 102201/100 Rev. B