

1a-1b PEARSALL DRIVE, OLDBURY, B69 2RA

DRAWING TITLE: LOCATION PLAN • JOB NO: 1327 • DRAWING NO: OS/1002 • SCALE: 1:1250 • DATE: 11/06/2023





- KEY:**
- Perimeter boundary
 - Storage areas
 - Sealed buildings
 - Concreted area
 - Vegetation/grass area
 - Mains water
 - Spill kit
 - Fire fighting equipment (extinguishers, etc.)
 - Electricity shutoff
 - Plant shutoff
 - Fire alarm
 - Gully
 - Main Fire Alarm control panel
 - Emergency vehicle access route
 - Foul drainage
 - Rain/Surface water drainage
 - MH Manhole
 - IC Inspection chamber
 - CCTV Closed circuit surveillance camera
 - SC Metal stillage store cage (1200x1200)
 - B Land Boom (wall mounted)
 - SD Sewage Discharge point



ARCTEK
 ARCTEK LTD
 GROSVENOR HOUSE
 11 ST PAULS SQUARE BIRMINGHAM B3 1RB
 TEL: 0121 389 8001 M: 0744711042 E: INFO@ARCTEK.CO.UK WWW.ARCTEK.CO.UK

CLIENT
FIRE PROTECTION RECYCLING

SITE ADDRESS
**UNIT 1A-1B PEARSALL DRIVE
 OLDBURY,
 B69 2RA**

DRAWING TITLE
PROPOSED SITE PLAN


DATE
12-02-2024

SCALE
1:250 @ A3

DRAWN BY
MA

DRAWING NO.
1002-03

JOB NO.
1327

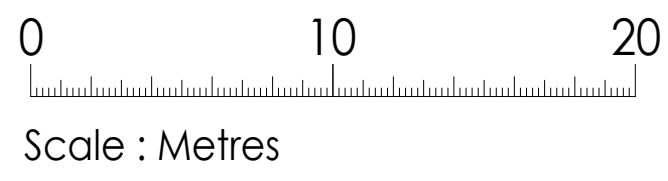

© This drawing is the property of Arctek Ltd. Copyright is reserved by them and the drawings issued on condition that they are not copied either wholly or in part without the consent in writing from Arctek Ltd. Figured dimensions are to take preference over those scaled. All dimensions to be checked on site prior to commencement of any work.