


# AVONMOUTH DOWNSTREAM PROCESS FLOW DIAGRAM

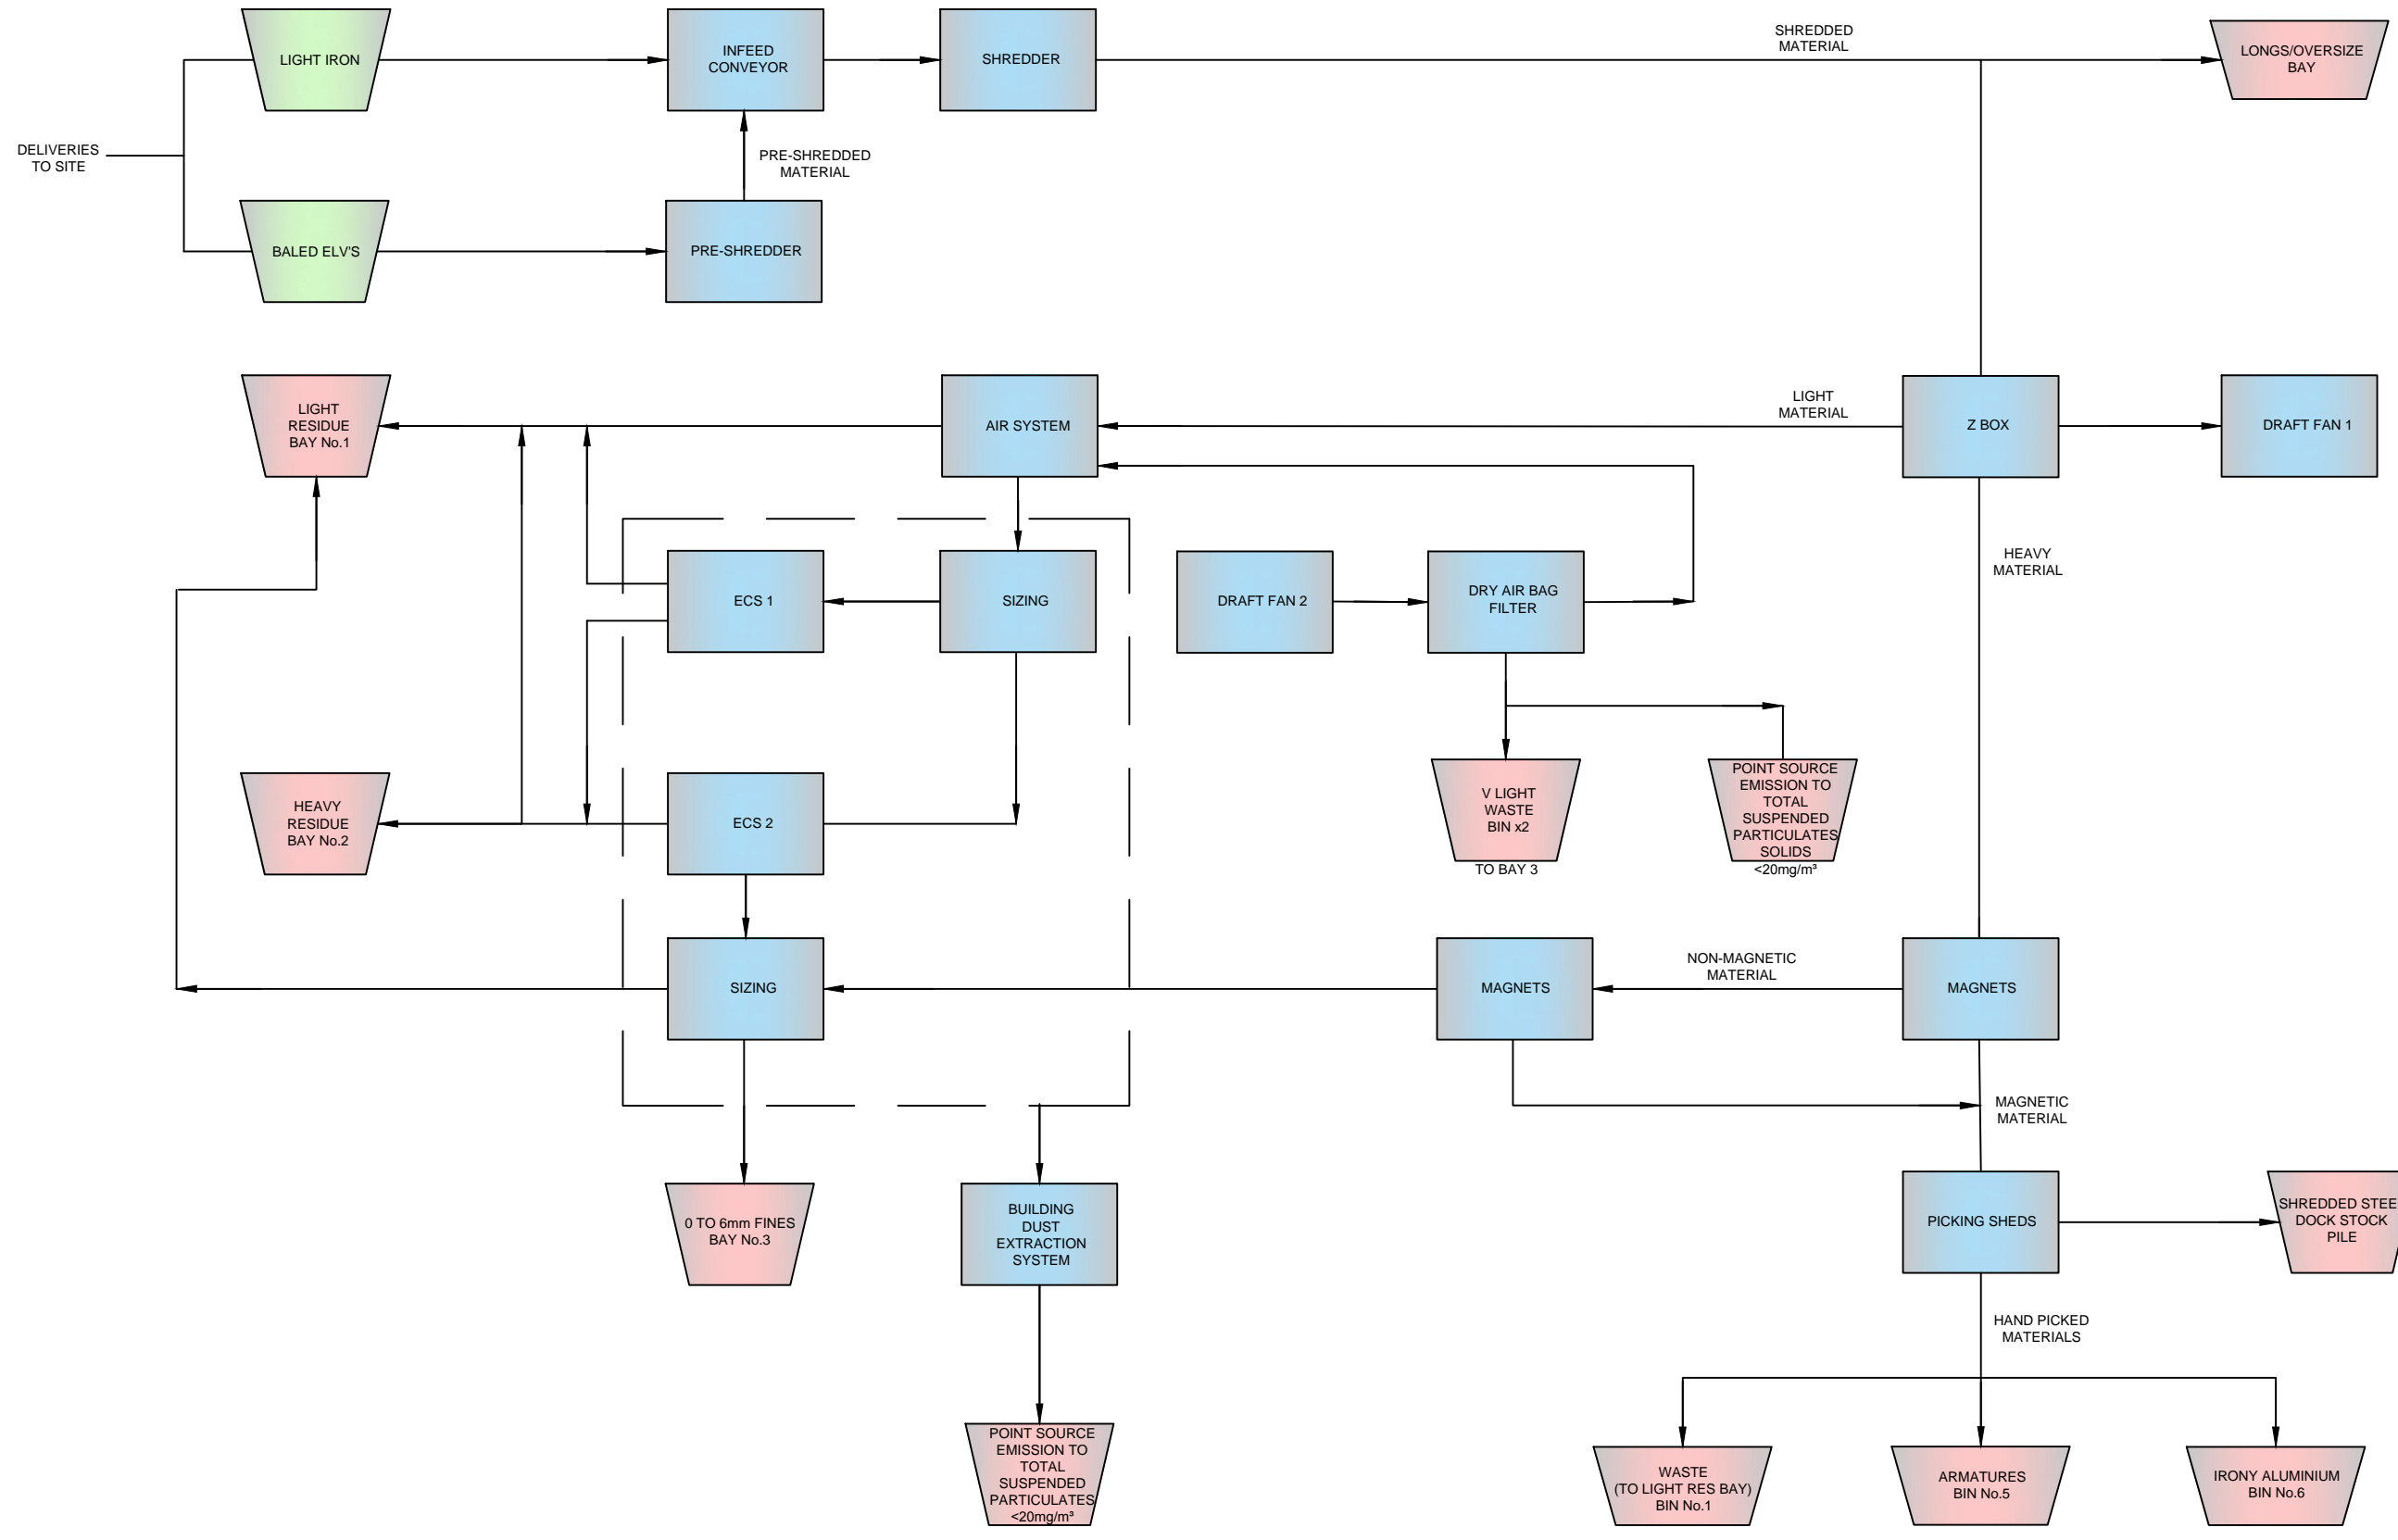

DRAWING NOTES:

	NAME	SIGNATURE	DATE
DRAWN	GT	GT	26-03-18
CHK'D	JN	JN	28-03-18
APPV'D	GS	GS	28-03-18

THIS DRAWING IS CONFIDENTIAL AND THE COPYRIGHT IS VESTED IN  
**SIMS METAL MANAGEMENT**  
 IT MUST NOT BE COPIED, LENT OR DISCLOSED TO A THIRD PARTY, WITHOUT THE WRITTEN CONSENT OF **SIMS METAL MANAGEMENT**  
 IT IS SUBJECT TO RECALL.

**Consul UK**  
 Engineering Design Consultants



PROJECT: **SIMS AIP**  
 SHEET 1 OF 1  
 REVISION **A**

**AVONMOUTH DOWNSTREAM  
 PROCESS FLOW DIAGRAM**

DWG NO. **001**