


Appendix B – Layout Drawings

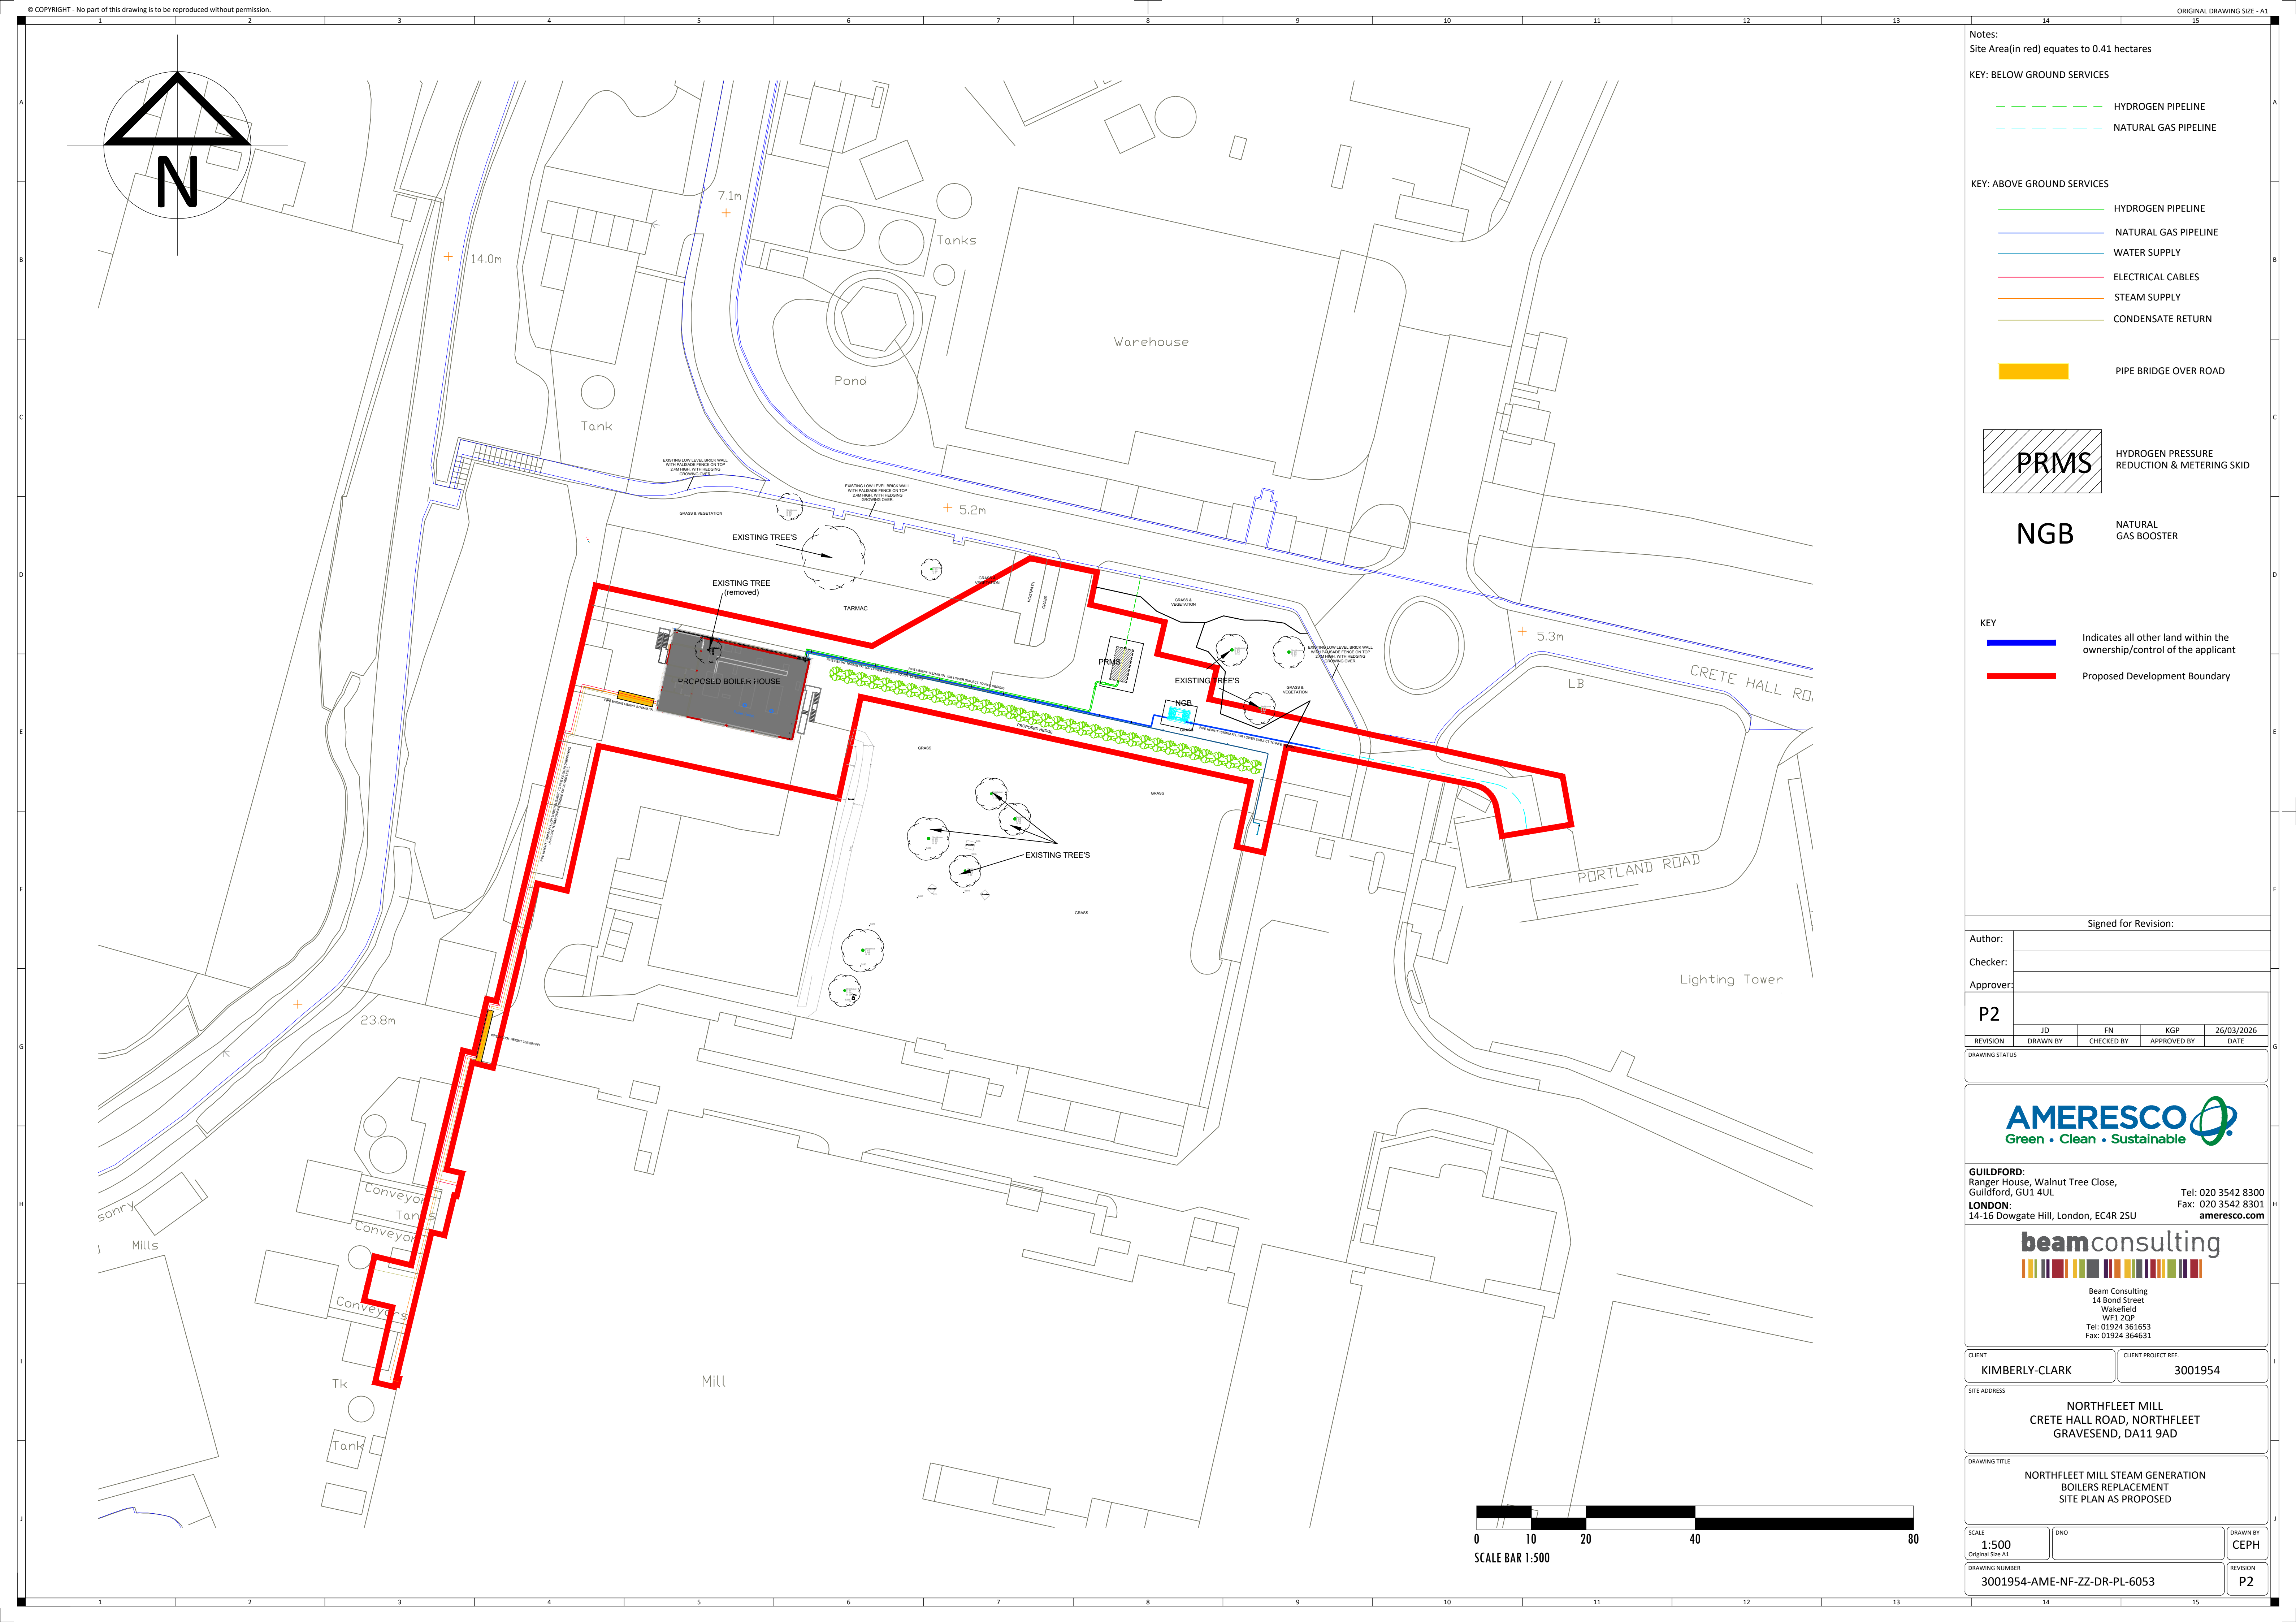

Notes:
Site Area(in red) equates to 0.41 hectares


KEY: BELOW GROUND SERVICES

- HYDROGEN PIPELINE
- NATURAL GAS PIPELINE

KEY: ABOVE GROUND SERVICES

- HYDROGEN PIPELINE
- NATURAL GAS PIPELINE
- WATER SUPPLY
- ELECTRICAL CABLES
- STEAM SUPPLY
- CONDENSATE RETURN

PIPE BRIDGE OVER ROAD

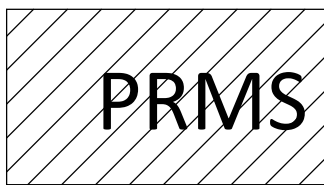

HYDROGEN PRESSURE
REDUCTION & METERING SKID

NGB

NATURAL
GAS BOOSTER

KEY

- Indicates all other land within the
ownership/control of the applicant
- Proposed Development Boundary

Signed for Revision:

Author:				
Checker:				
Approver:				
P2				
REVISION	JD	FN	KGP	26/03/2026
	DRAWN BY	CHECKED BY	APPROVED BY	DATE

DRAWING STATUS



GUILDFORD:
Ranger House, Walnut Tree Close,
Guildford, GU1 4UL
LONDON:
14-16 Dowgate Hill, London, EC4R 2SU

Tel: 020 3542 8300
Fax: 020 3542 8301
ameresco.com




Beam Consulting
14 Bond Street
Wakefield
WF1 2QP
Tel: 01924 361653
Fax: 01924 364631

CLIENT	CLIENT PROJECT REF.
KIMBERLY-CLARK	3001954

SITE ADDRESS
**NORTHFLEET MILL
CRETE HALL ROAD, NORTHFLEET
GRAVESEND, DA11 9AD**





DRAWING TITLE
**NORTHFLEET MILL STEAM GENERATION
BOILERS REPLACEMENT
SITE PLAN AS PROPOSED**

SCALE 1:500 Original Size A1	DWG	DRAWN BY CEPH
DRAWING NUMBER 3001954-AME-NF-ZZ-DR-PL-6053	REVISION P2	

 

0 2 4 8 160

SCALE BAR 1:100

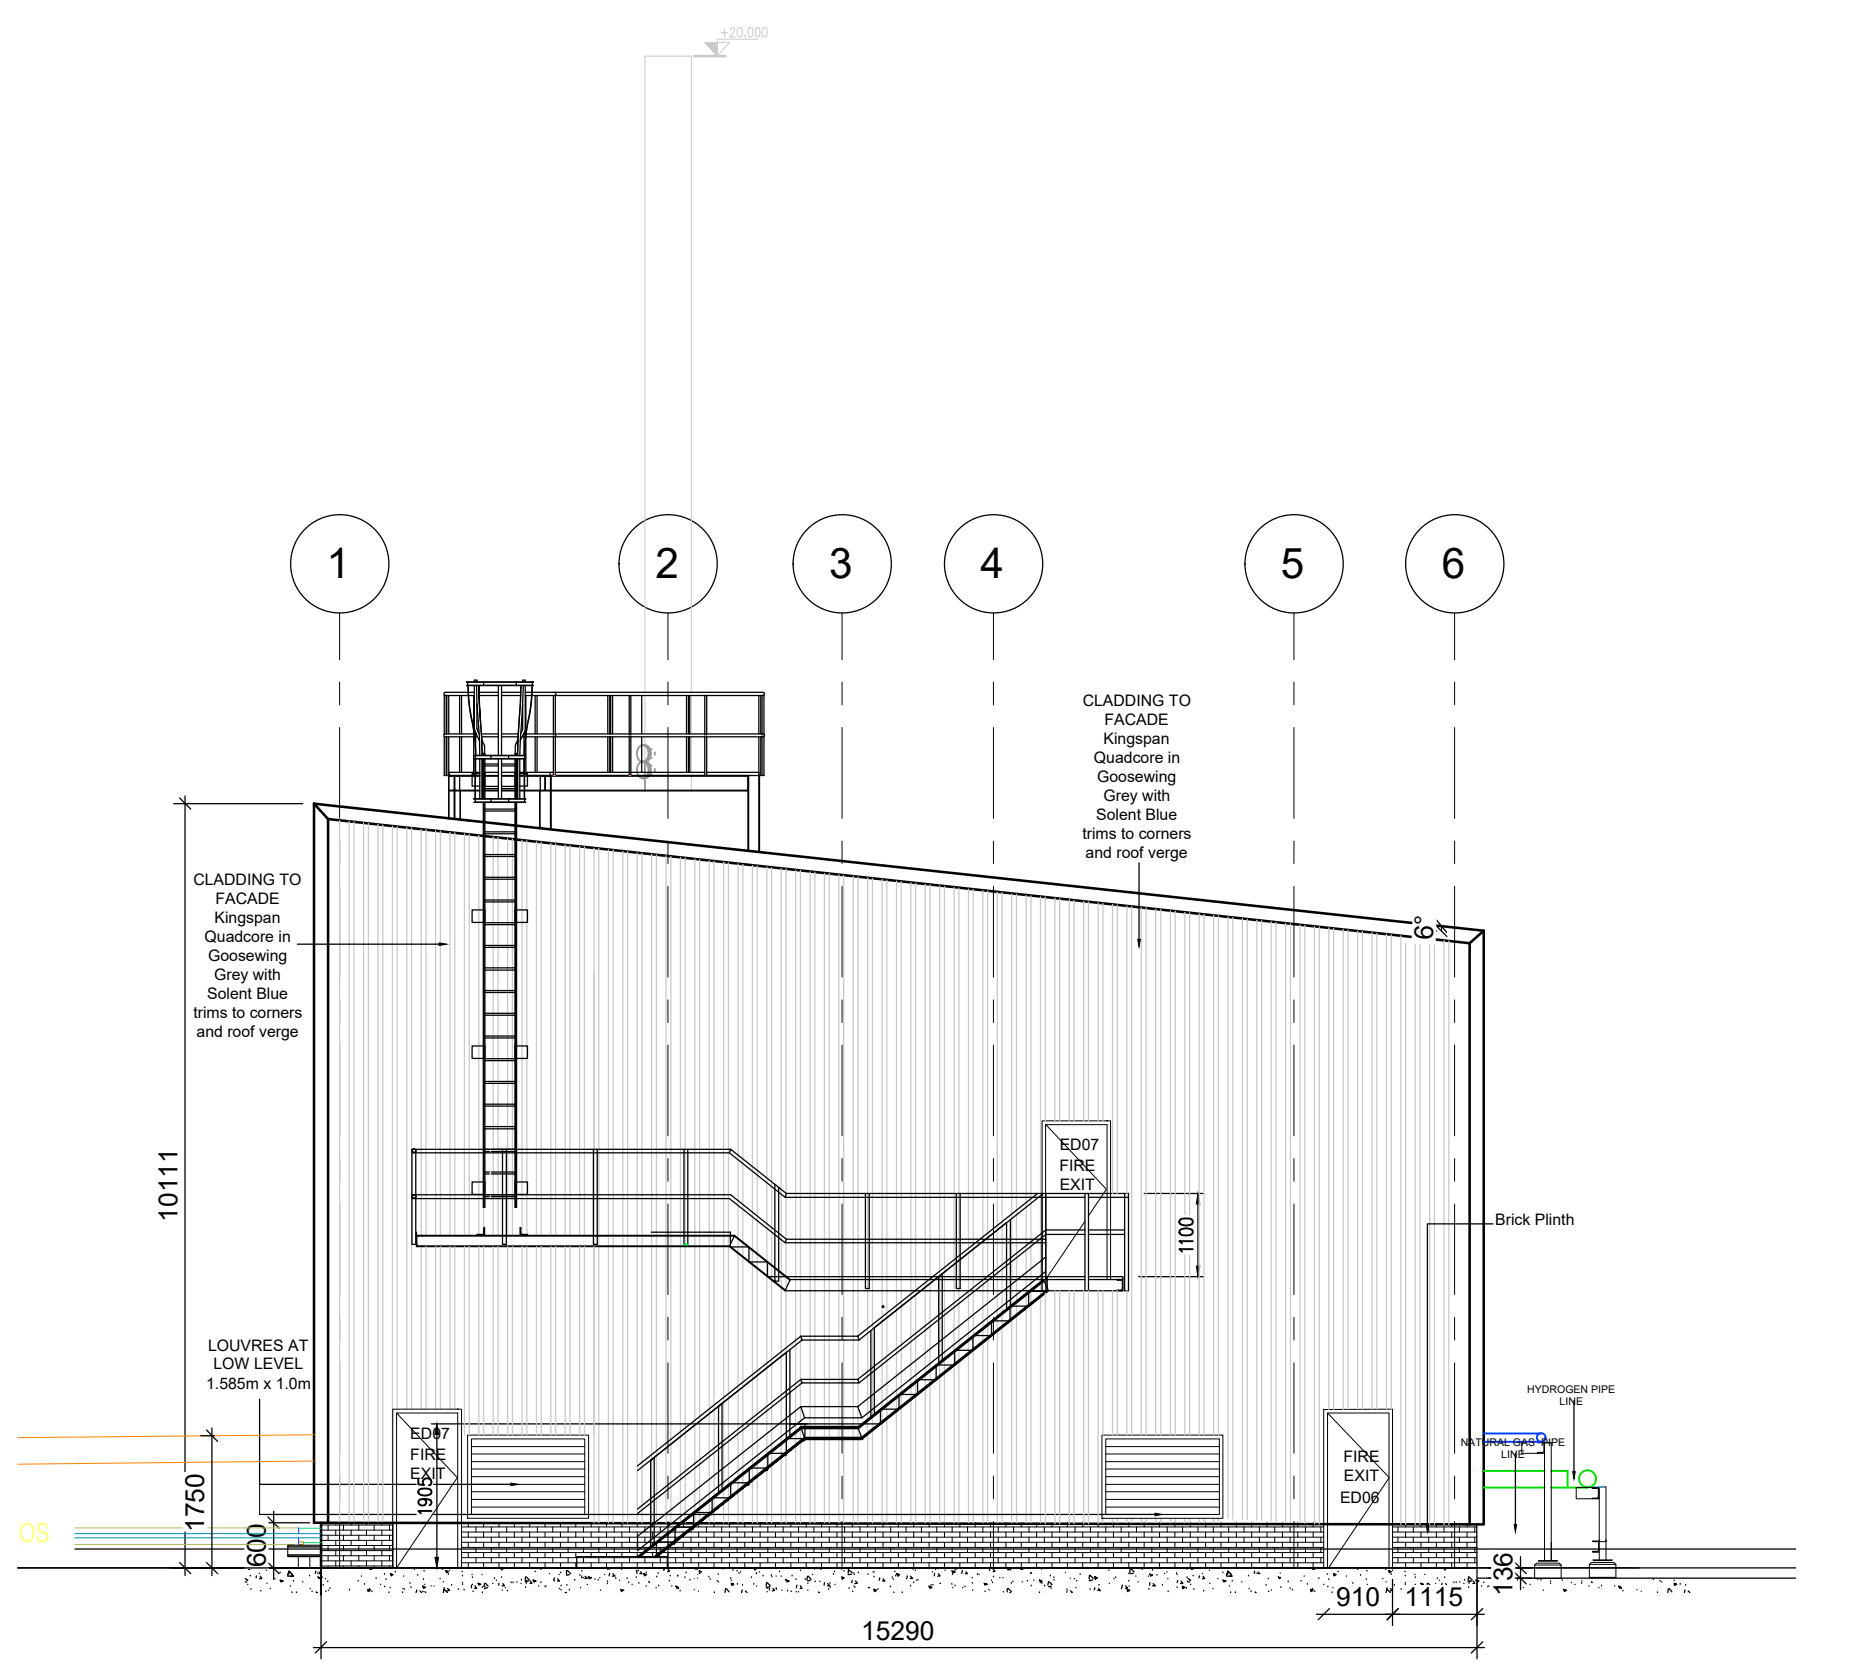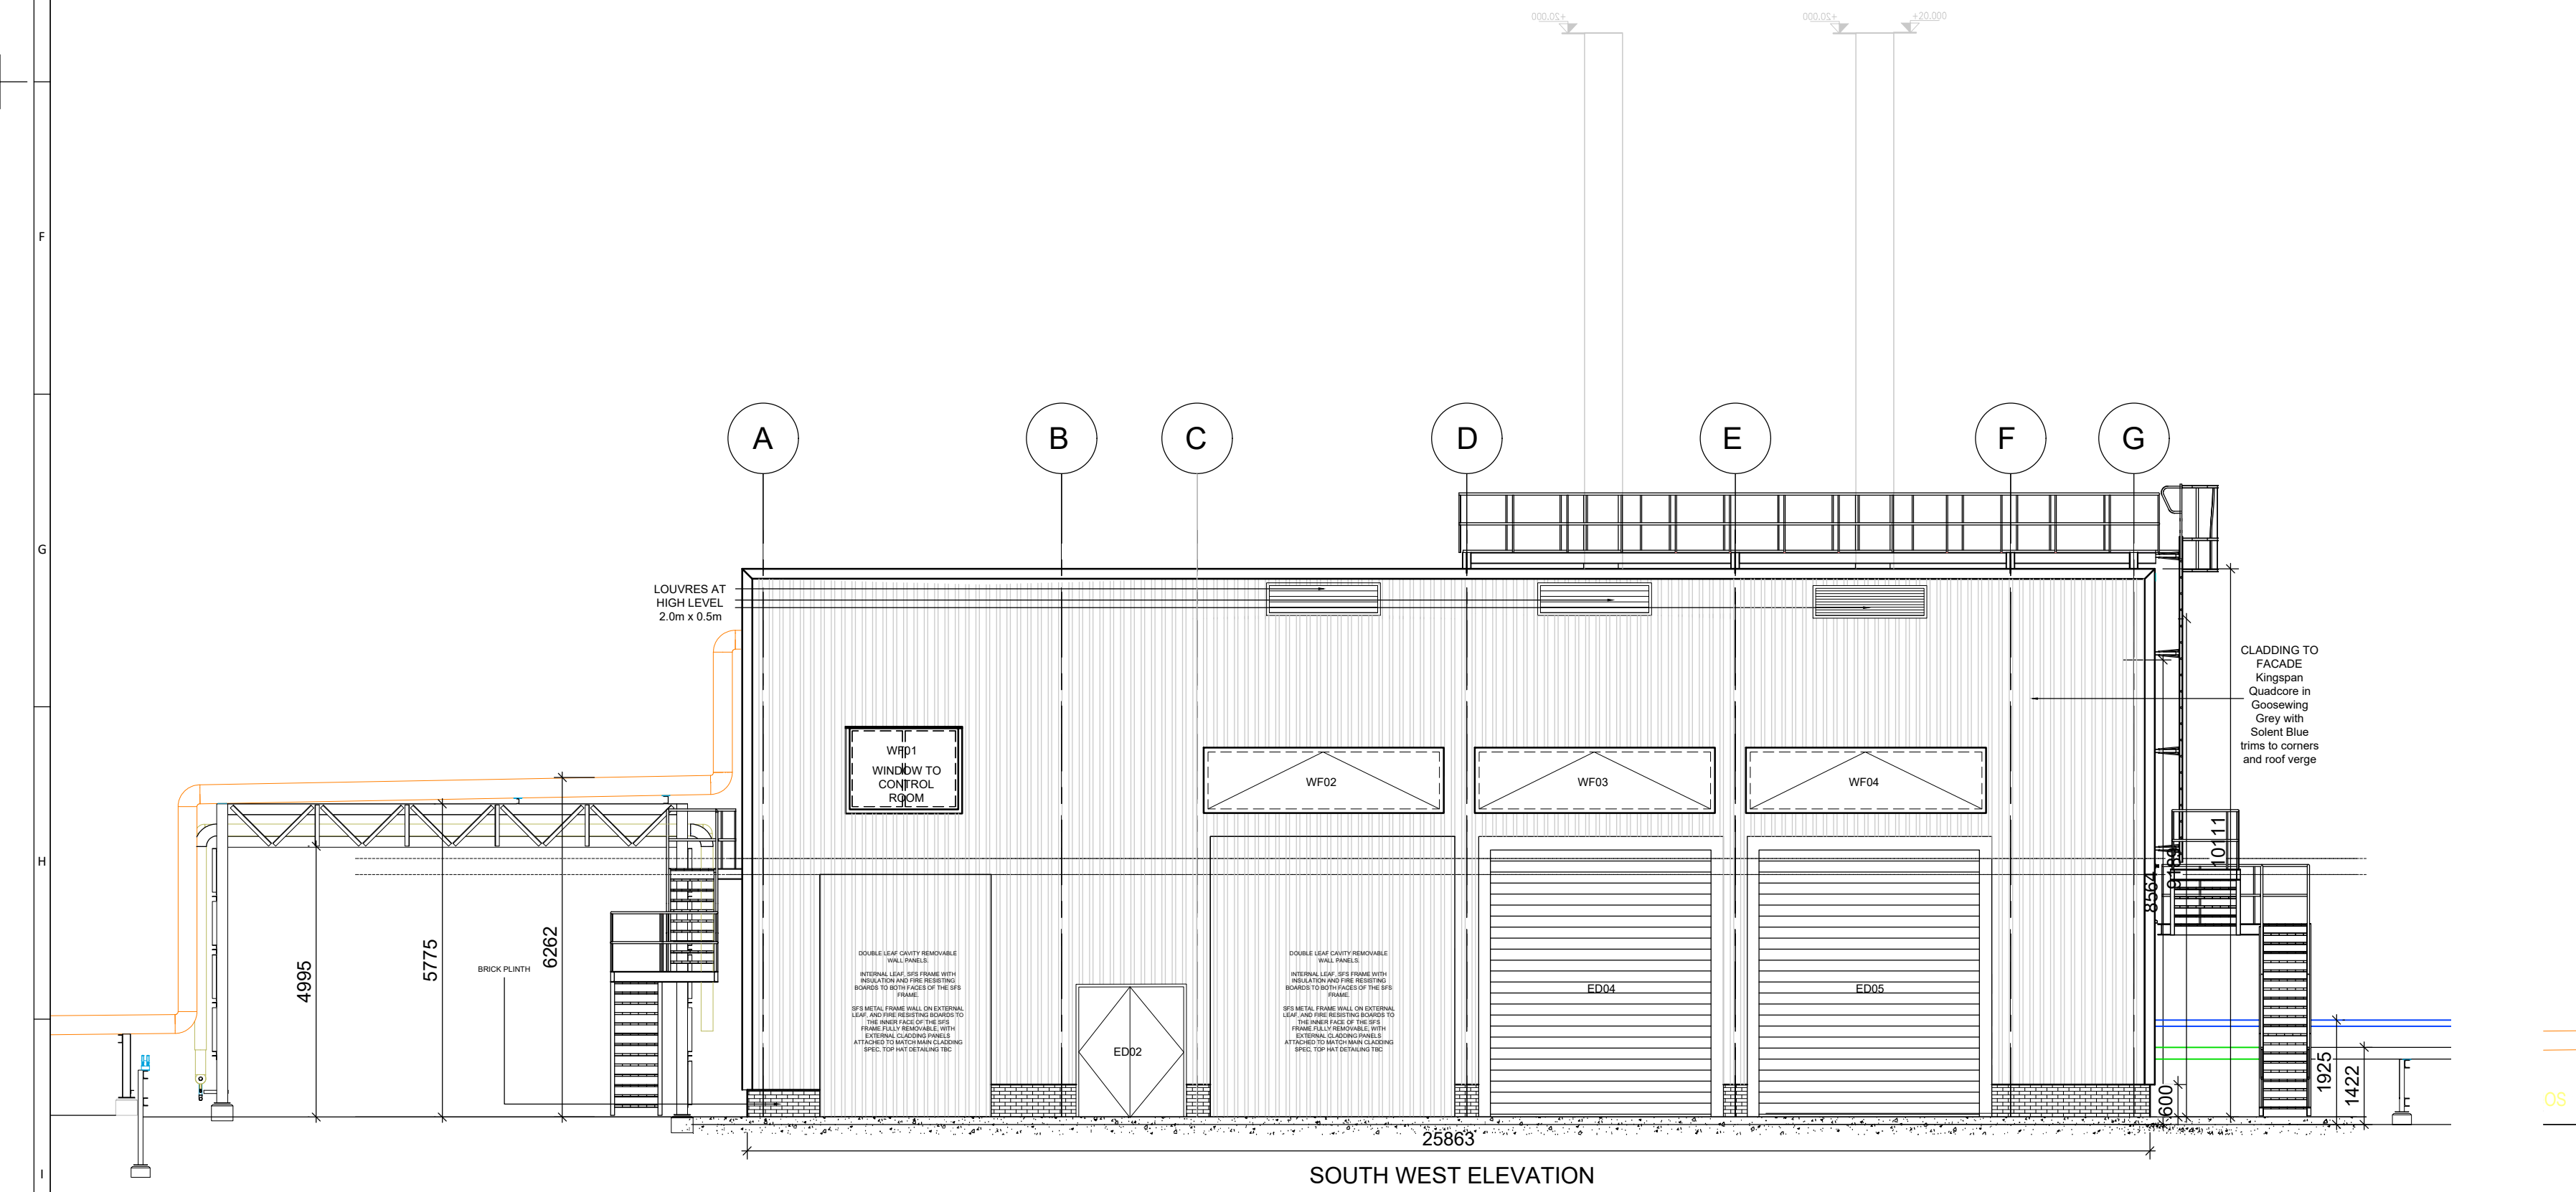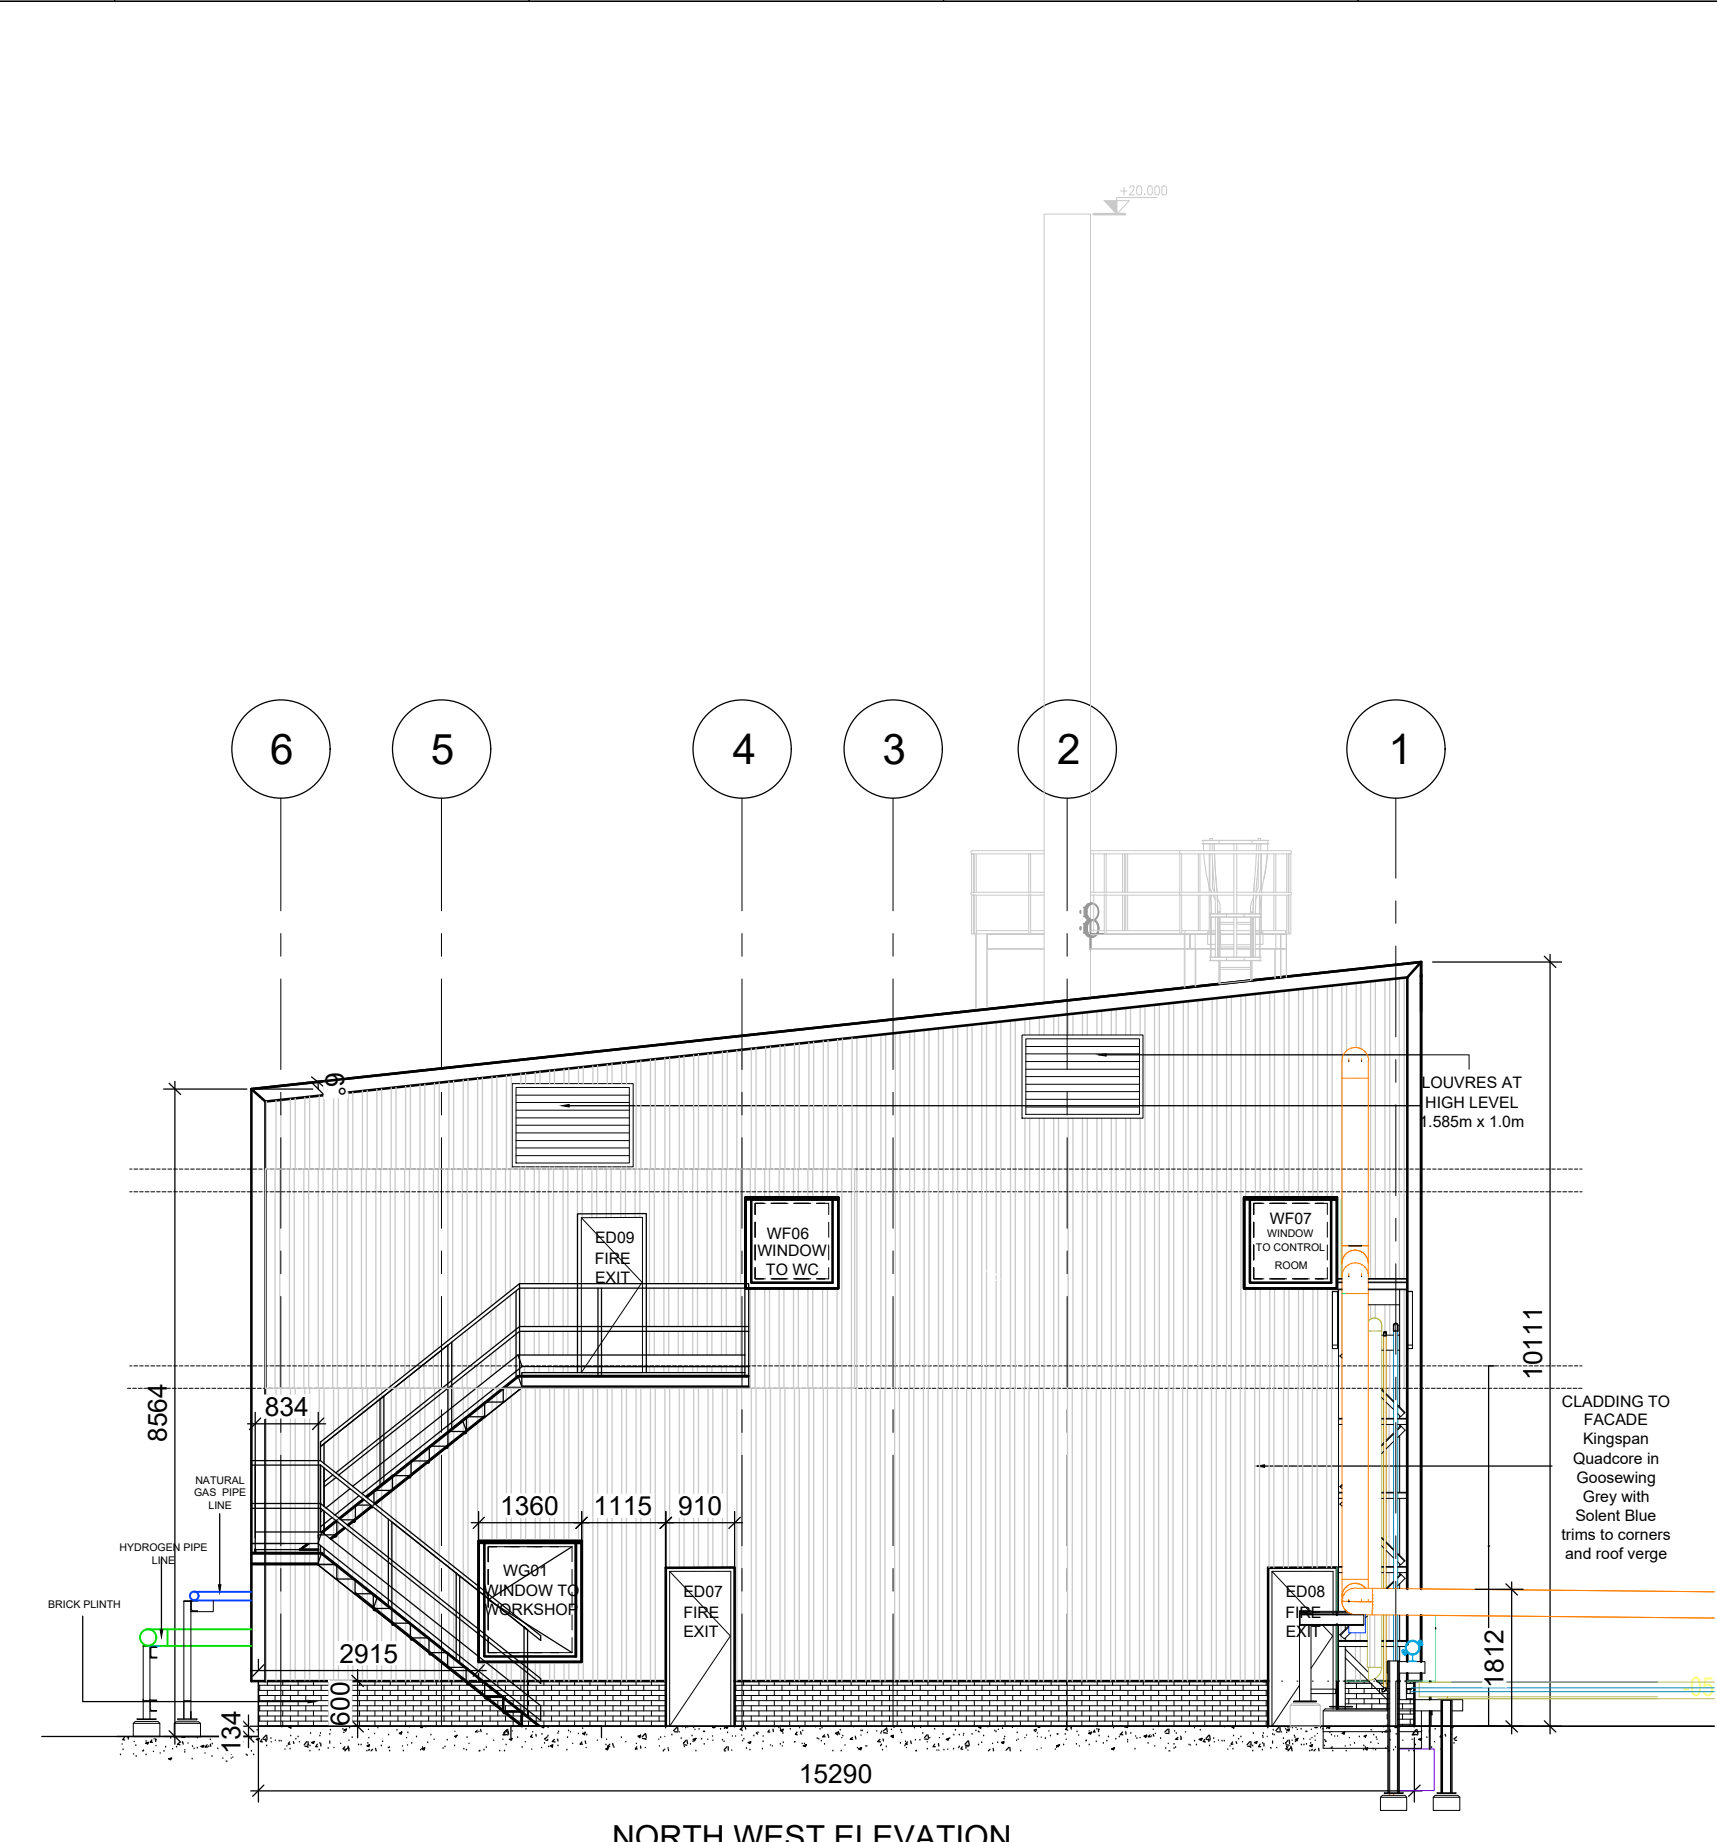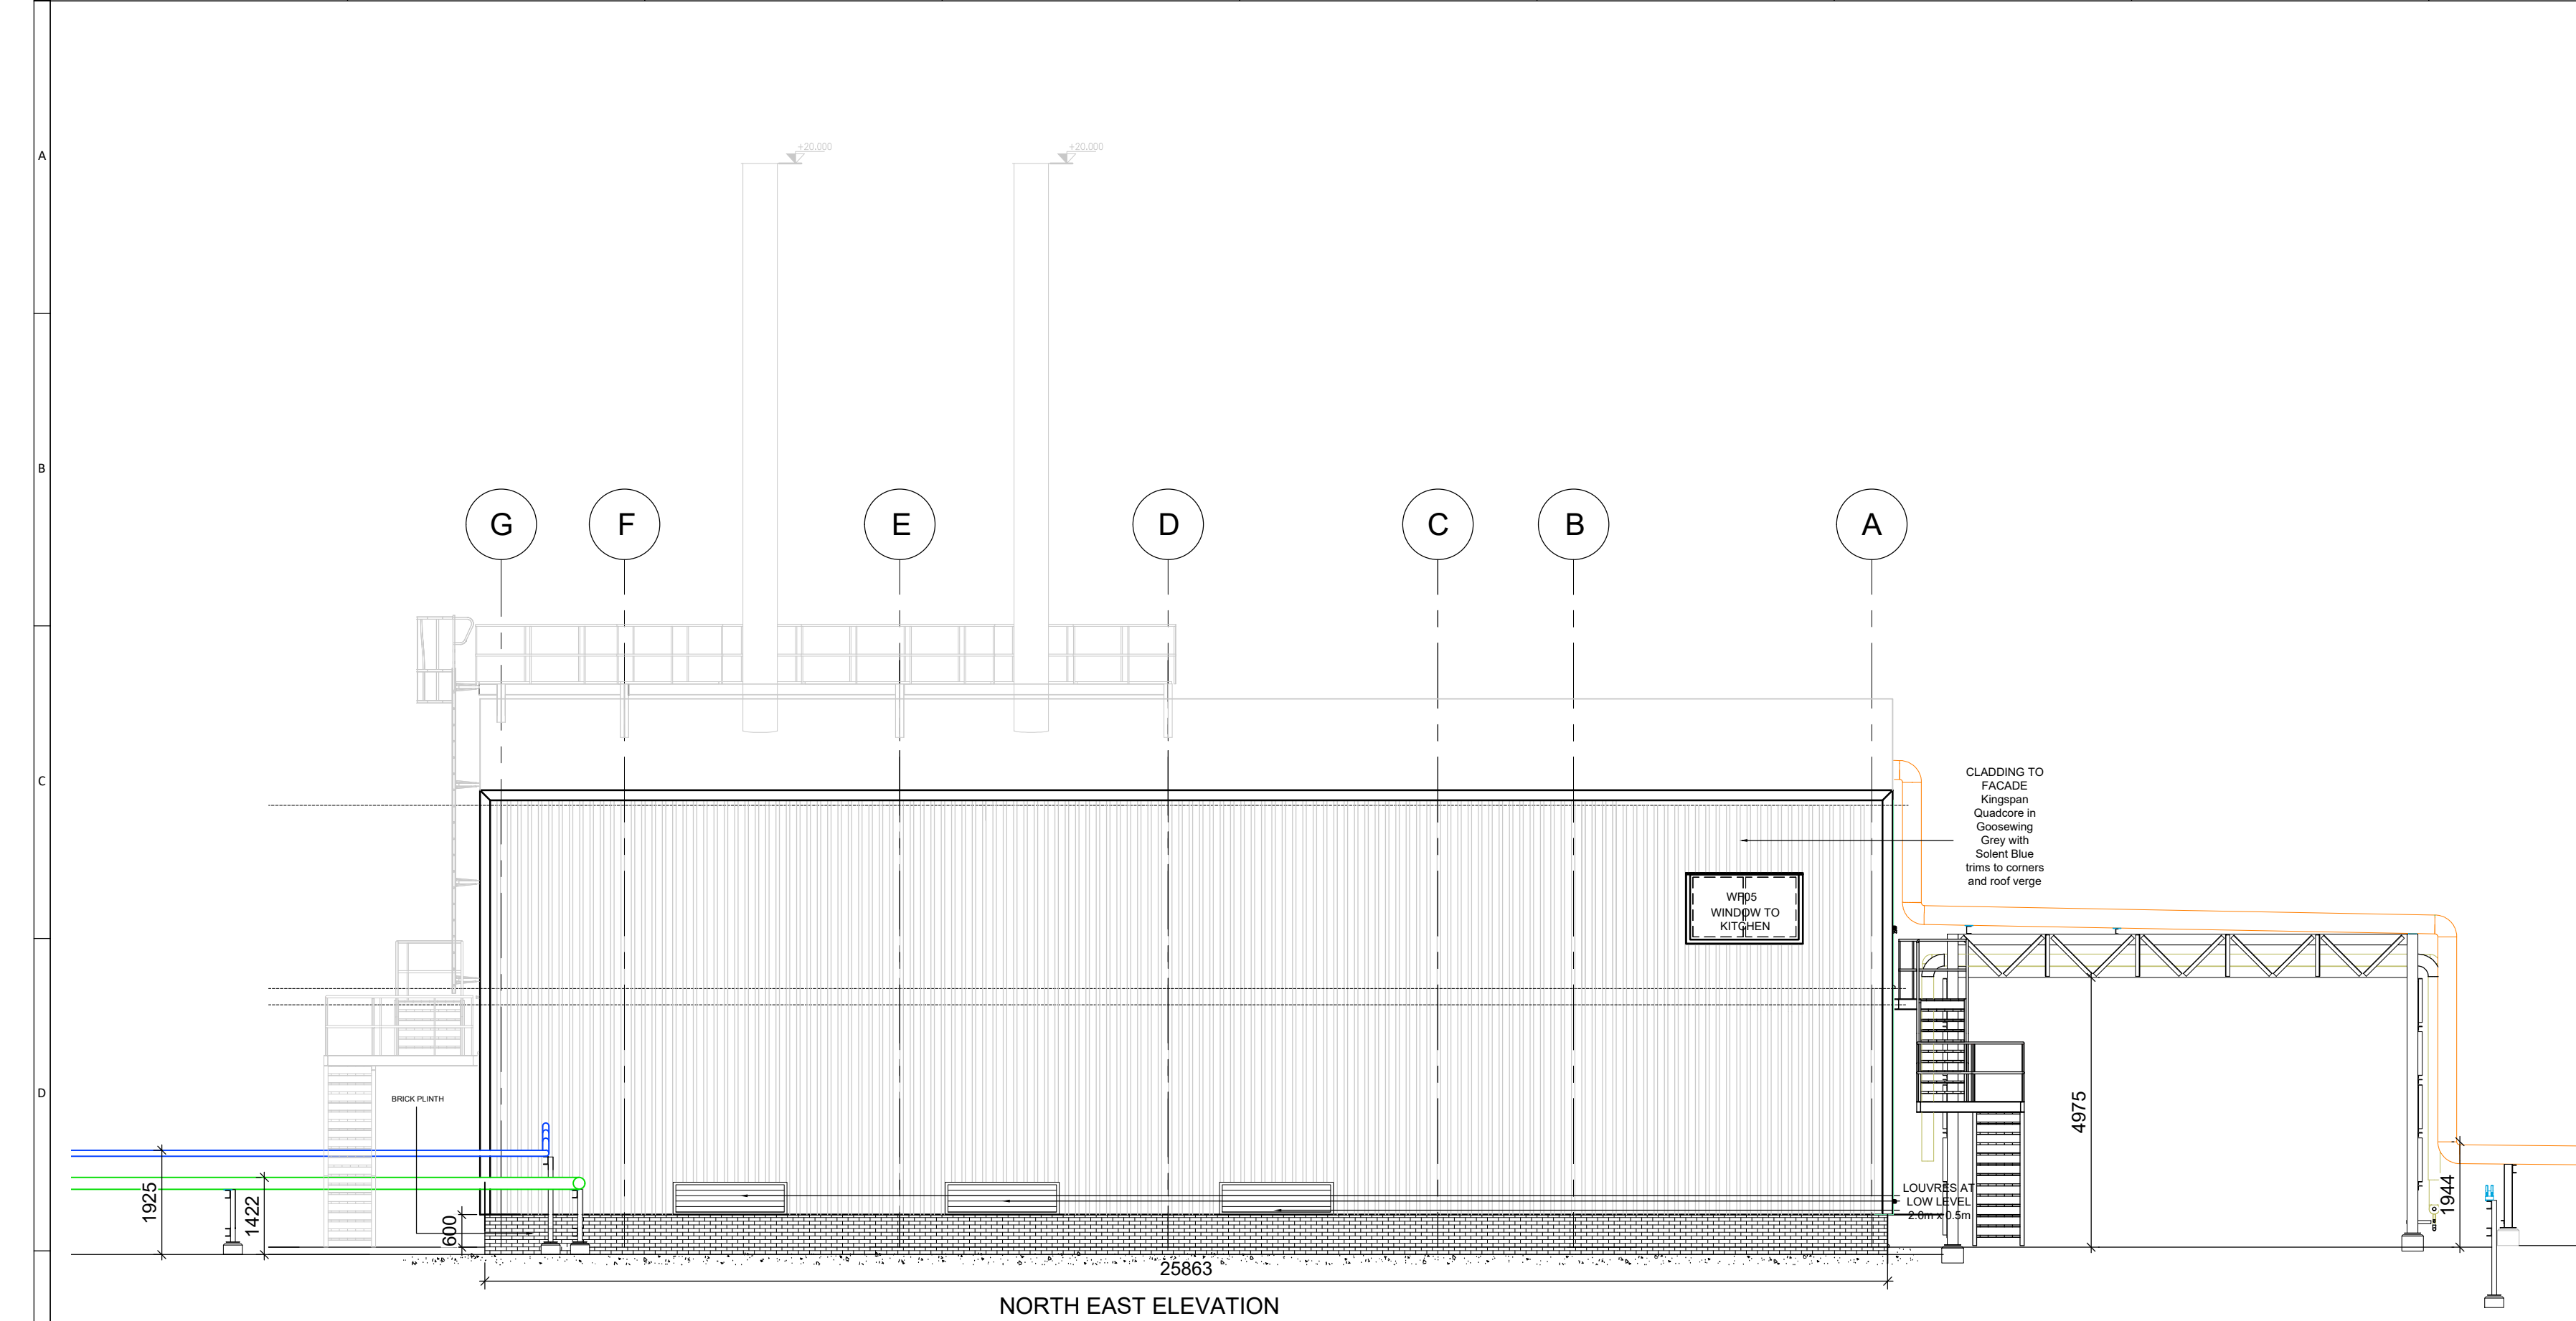

Notes:
LIGHTING TO REMAIN AS EXISTING ONSITE LIGHTING IN VICINITY OF BUILDING.

KEY

- HYDROGEN PIPELINE
- NATURAL GAS PIPELINE
- ELECTRICAL CABLES
- STEAM SUPPLY
- CONDENSATE RETURN

Signed for Revision: **

Author:				
Checker:				
Approver:				
P2				
REVISION	DRAWN BY	CHECKED BY	APPROVED BY	DATE
	ELH	FN	KGP	24-03-26

DRAWING STATUS


AMERESCO
Green • Clean • Sustainable

GUILDFORD:
Ranger House, Walnut Tree Close,
Guildford, GU1 4UL
Tel: 020 3542 8300
Fax: 020 3542 8301

LONDON:
14-16 Dowgate Hill, London, EC4R 2SU
Tel: 01924 361653
Fax: 01924 364631

beamconsulting
Beam Consulting
14 Bond Street
Wakefield
WF1 2QP
Tel: 01924 361653
Fax: 01924 364631

CLIENT	KIMBERLY-CLARK	CLIENT PROJECT REF.	3001954
SITE ADDRESS	NORTHFLEET MILL CRETE HALL ROAD, NORTHFLEET GRAVESEND, DA11 9AD		
DRAWING TITLE	NORTHFLEET MILL STEAM GENERATION BOILERS REPLACEMENT ELEVATIONS		
SCALE	1:100 Original Size A1	DWG	DRAWN BY ELH
DRAWING NUMBER	3001954-AME-NF-ZZ-DR-PL-6055	REVISION	P2

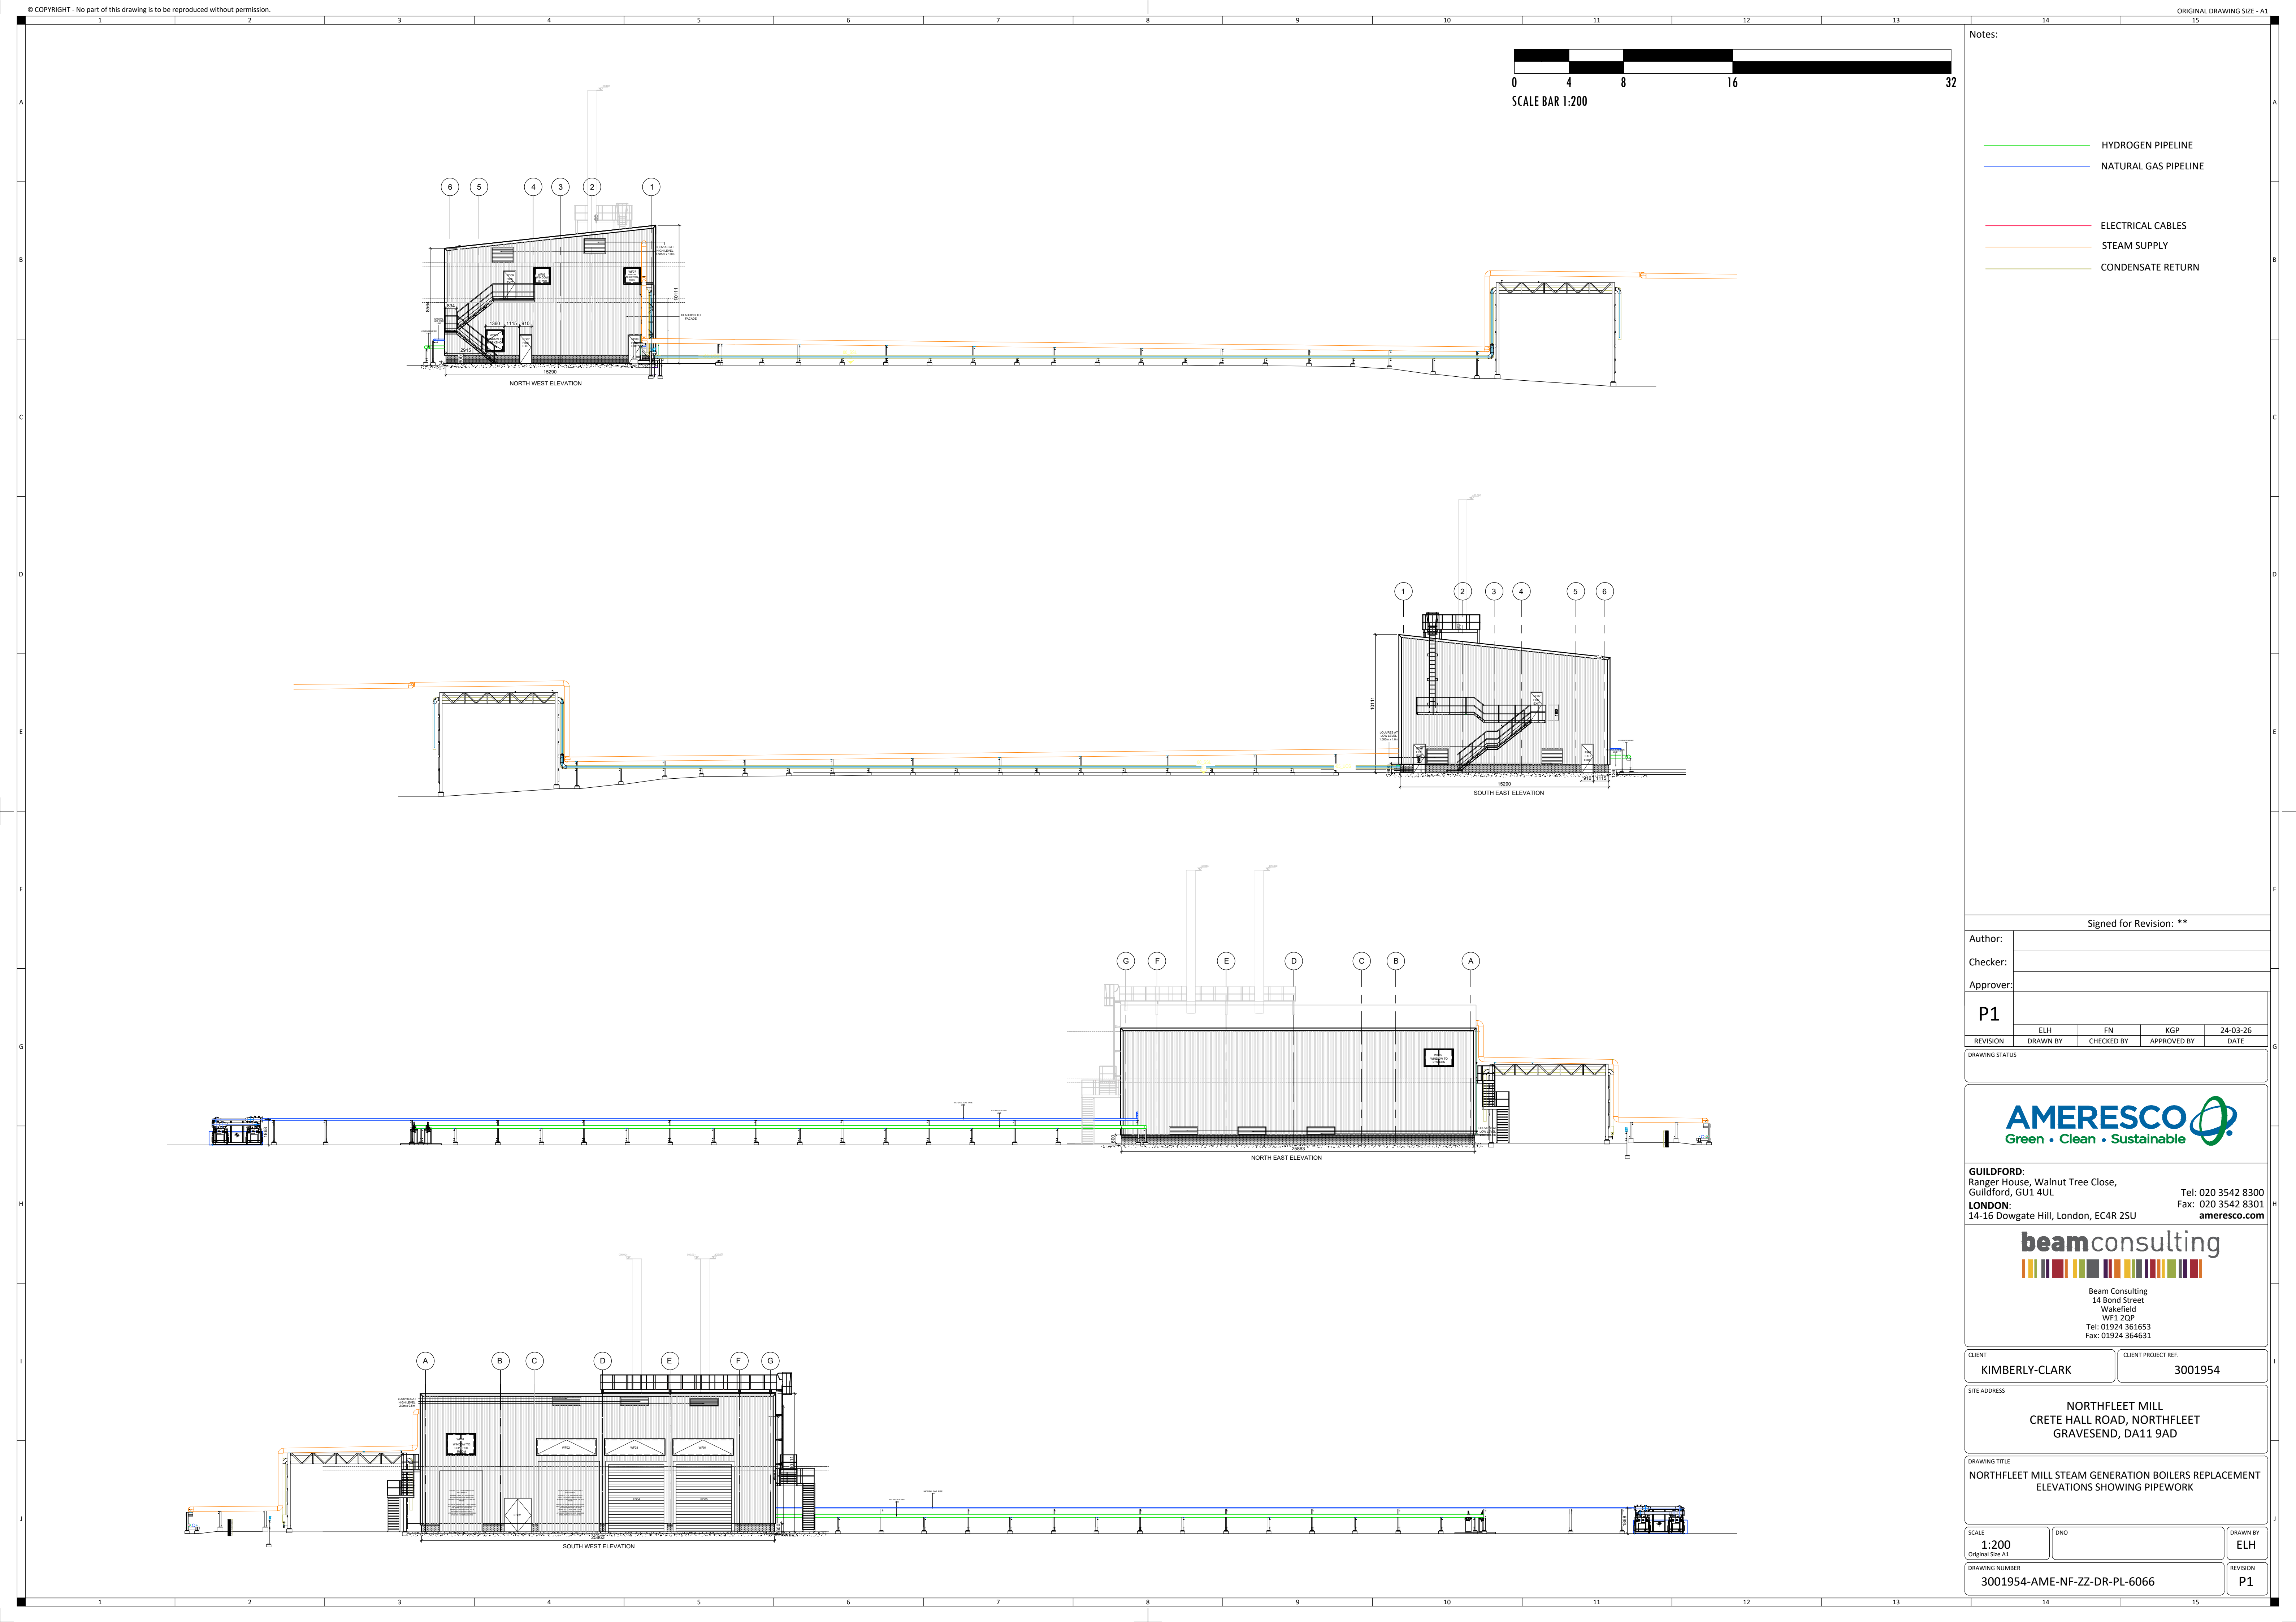

Notes:

- HYDROGEN PIPELINE
- NATURAL GAS PIPELINE
- ELECTRICAL CABLES
- STEAM SUPPLY
- CONDENSATE RETURN

Signed for Revision: **

Author:
Checker:
Approver:

P1				
REVISION	DRAWN BY	CHECKED BY	APPROVED BY	DATE

DRAWING STATUS



GUILDFORD:
Ranger House, Walnut Tree Close,
Guildford, GU1 4UL
LONDON:
14-16 Dowgate Hill, London, EC4R 2SU

Tel: 020 3542 8300
Fax: 020 3542 8301
ameresco.com




Beam Consulting
14 Bond Street
Wakefield
WF1 2QP
Tel: 01924 361653
Fax: 01924 364631

CLIENT	CLIENT PROJECT REF.
KIMBERLY-CLARK	3001954

SITE ADDRESS
**NORTHFLEET MILL
CRETE HALL ROAD, NORTHFLEET
GRAVESEND, DA11 9AD**

DRAWING TITLE
**NORTHFLEET MILL STEAM GENERATION BOILERS REPLACEMENT
ELEVATIONS SHOWING PIPEWORK**

SCALE 1:200 Original Size A1	DWG	DRAWN BY ELH
DRAWING NUMBER 3001954-AME-NF-ZZ-DR-PL-6066	REVISION P1	

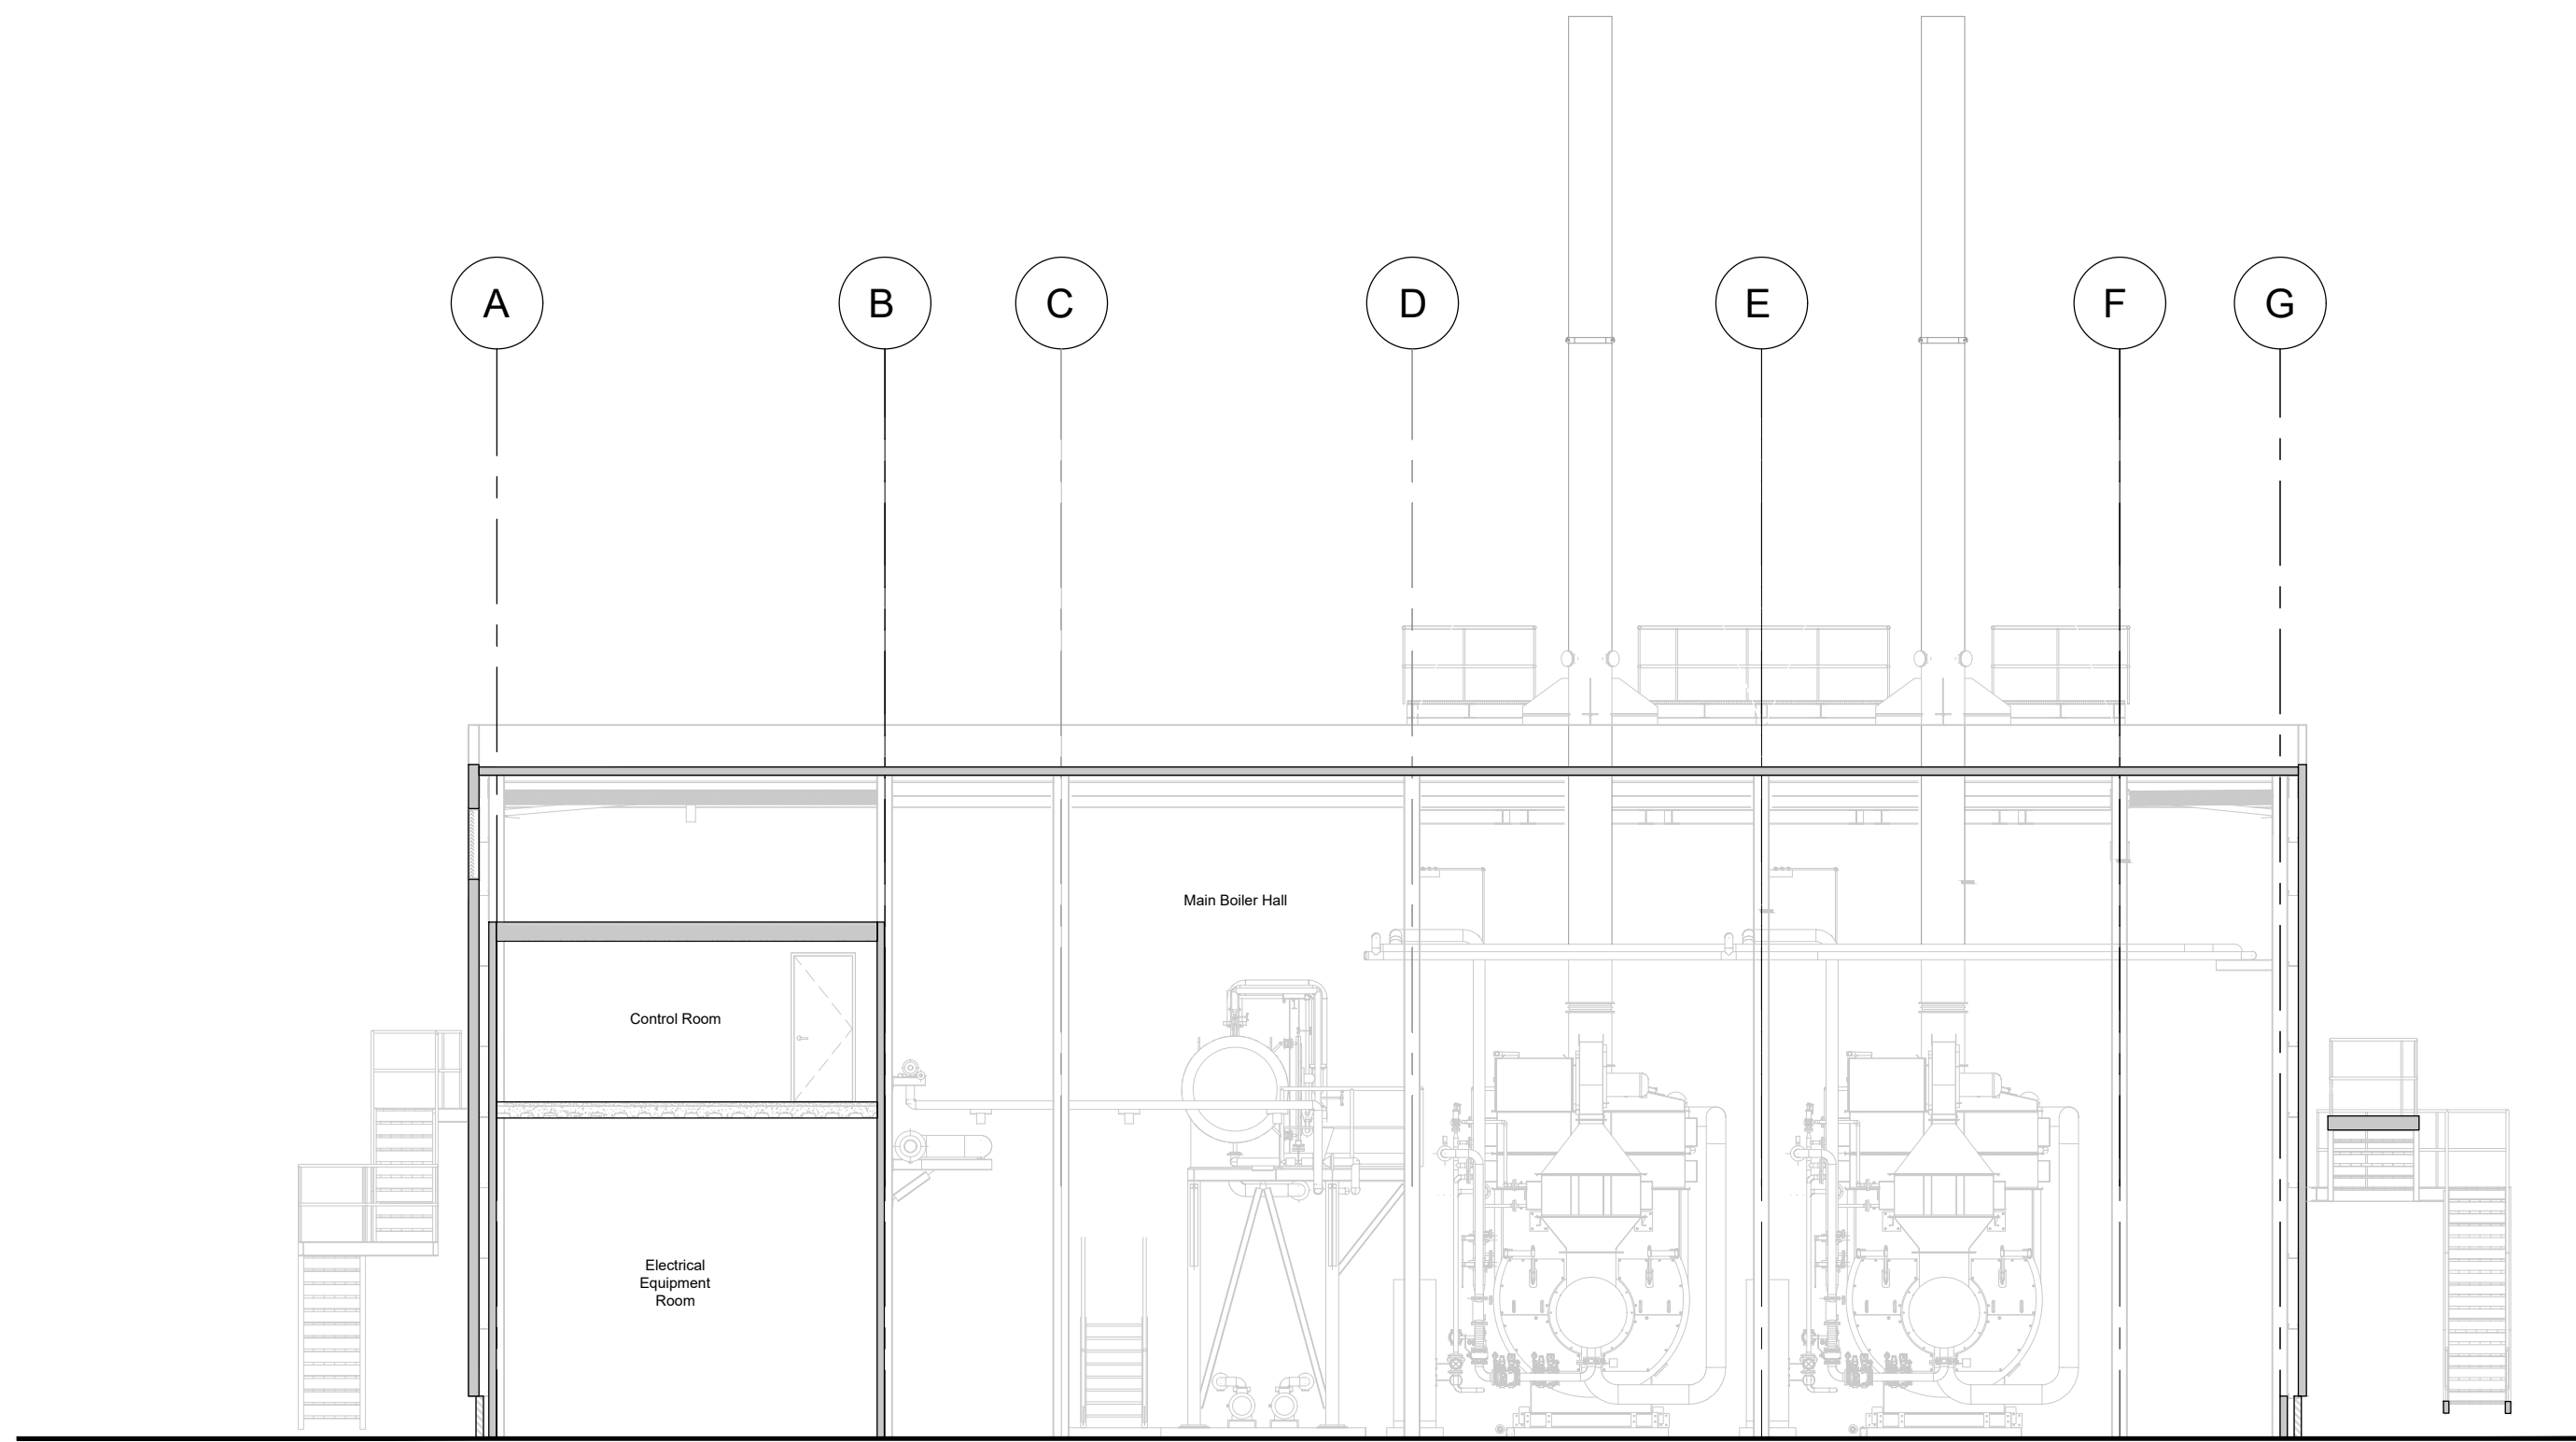

Notes:

Signed for Revision: **

Author:				
Checker:				
Approver:				
P1				
	CEPH	FN	KGP	27-03-26
REVISION	DRAWN BY	CHECKED BY	APPROVED BY	DATE

DRAWING STATUS



GUILDFORD:
Ranger House, Walnut Tree Close,
Guildford, GU1 4UL
LONDON:
14-16 Dowgate Hill, London, EC4R 2SU

Tel: 020 3542 8300
Fax: 020 3542 8301
ameresco.com

beamconsulting

Beam Consulting
14 Bond Street
Wakefield
WF1 2QP
Tel: 01924 361653
Fax: 01924 364631

CLIENT	CLIENT PROJECT REF.
KIMBERLY-CLARK	3001954

SITE ADDRESS
NORTHFLEET MILL
CRETE HALL ROAD, NORTHFLEET
GRAVESEND, DA11 9AD

DRAWING TITLE
NORTHFLEET MILL STEAM GENERATION BOILERS REPLACEMENT
LONGITUDINAL PLANNING SECTION

SCALE 1:100 Original Size A1	DWG DRAWN BY CEPH	REVISION P1
DRAWING NUMBER 3001954-AME-NF-ZZ-DR-PL-6070		

