


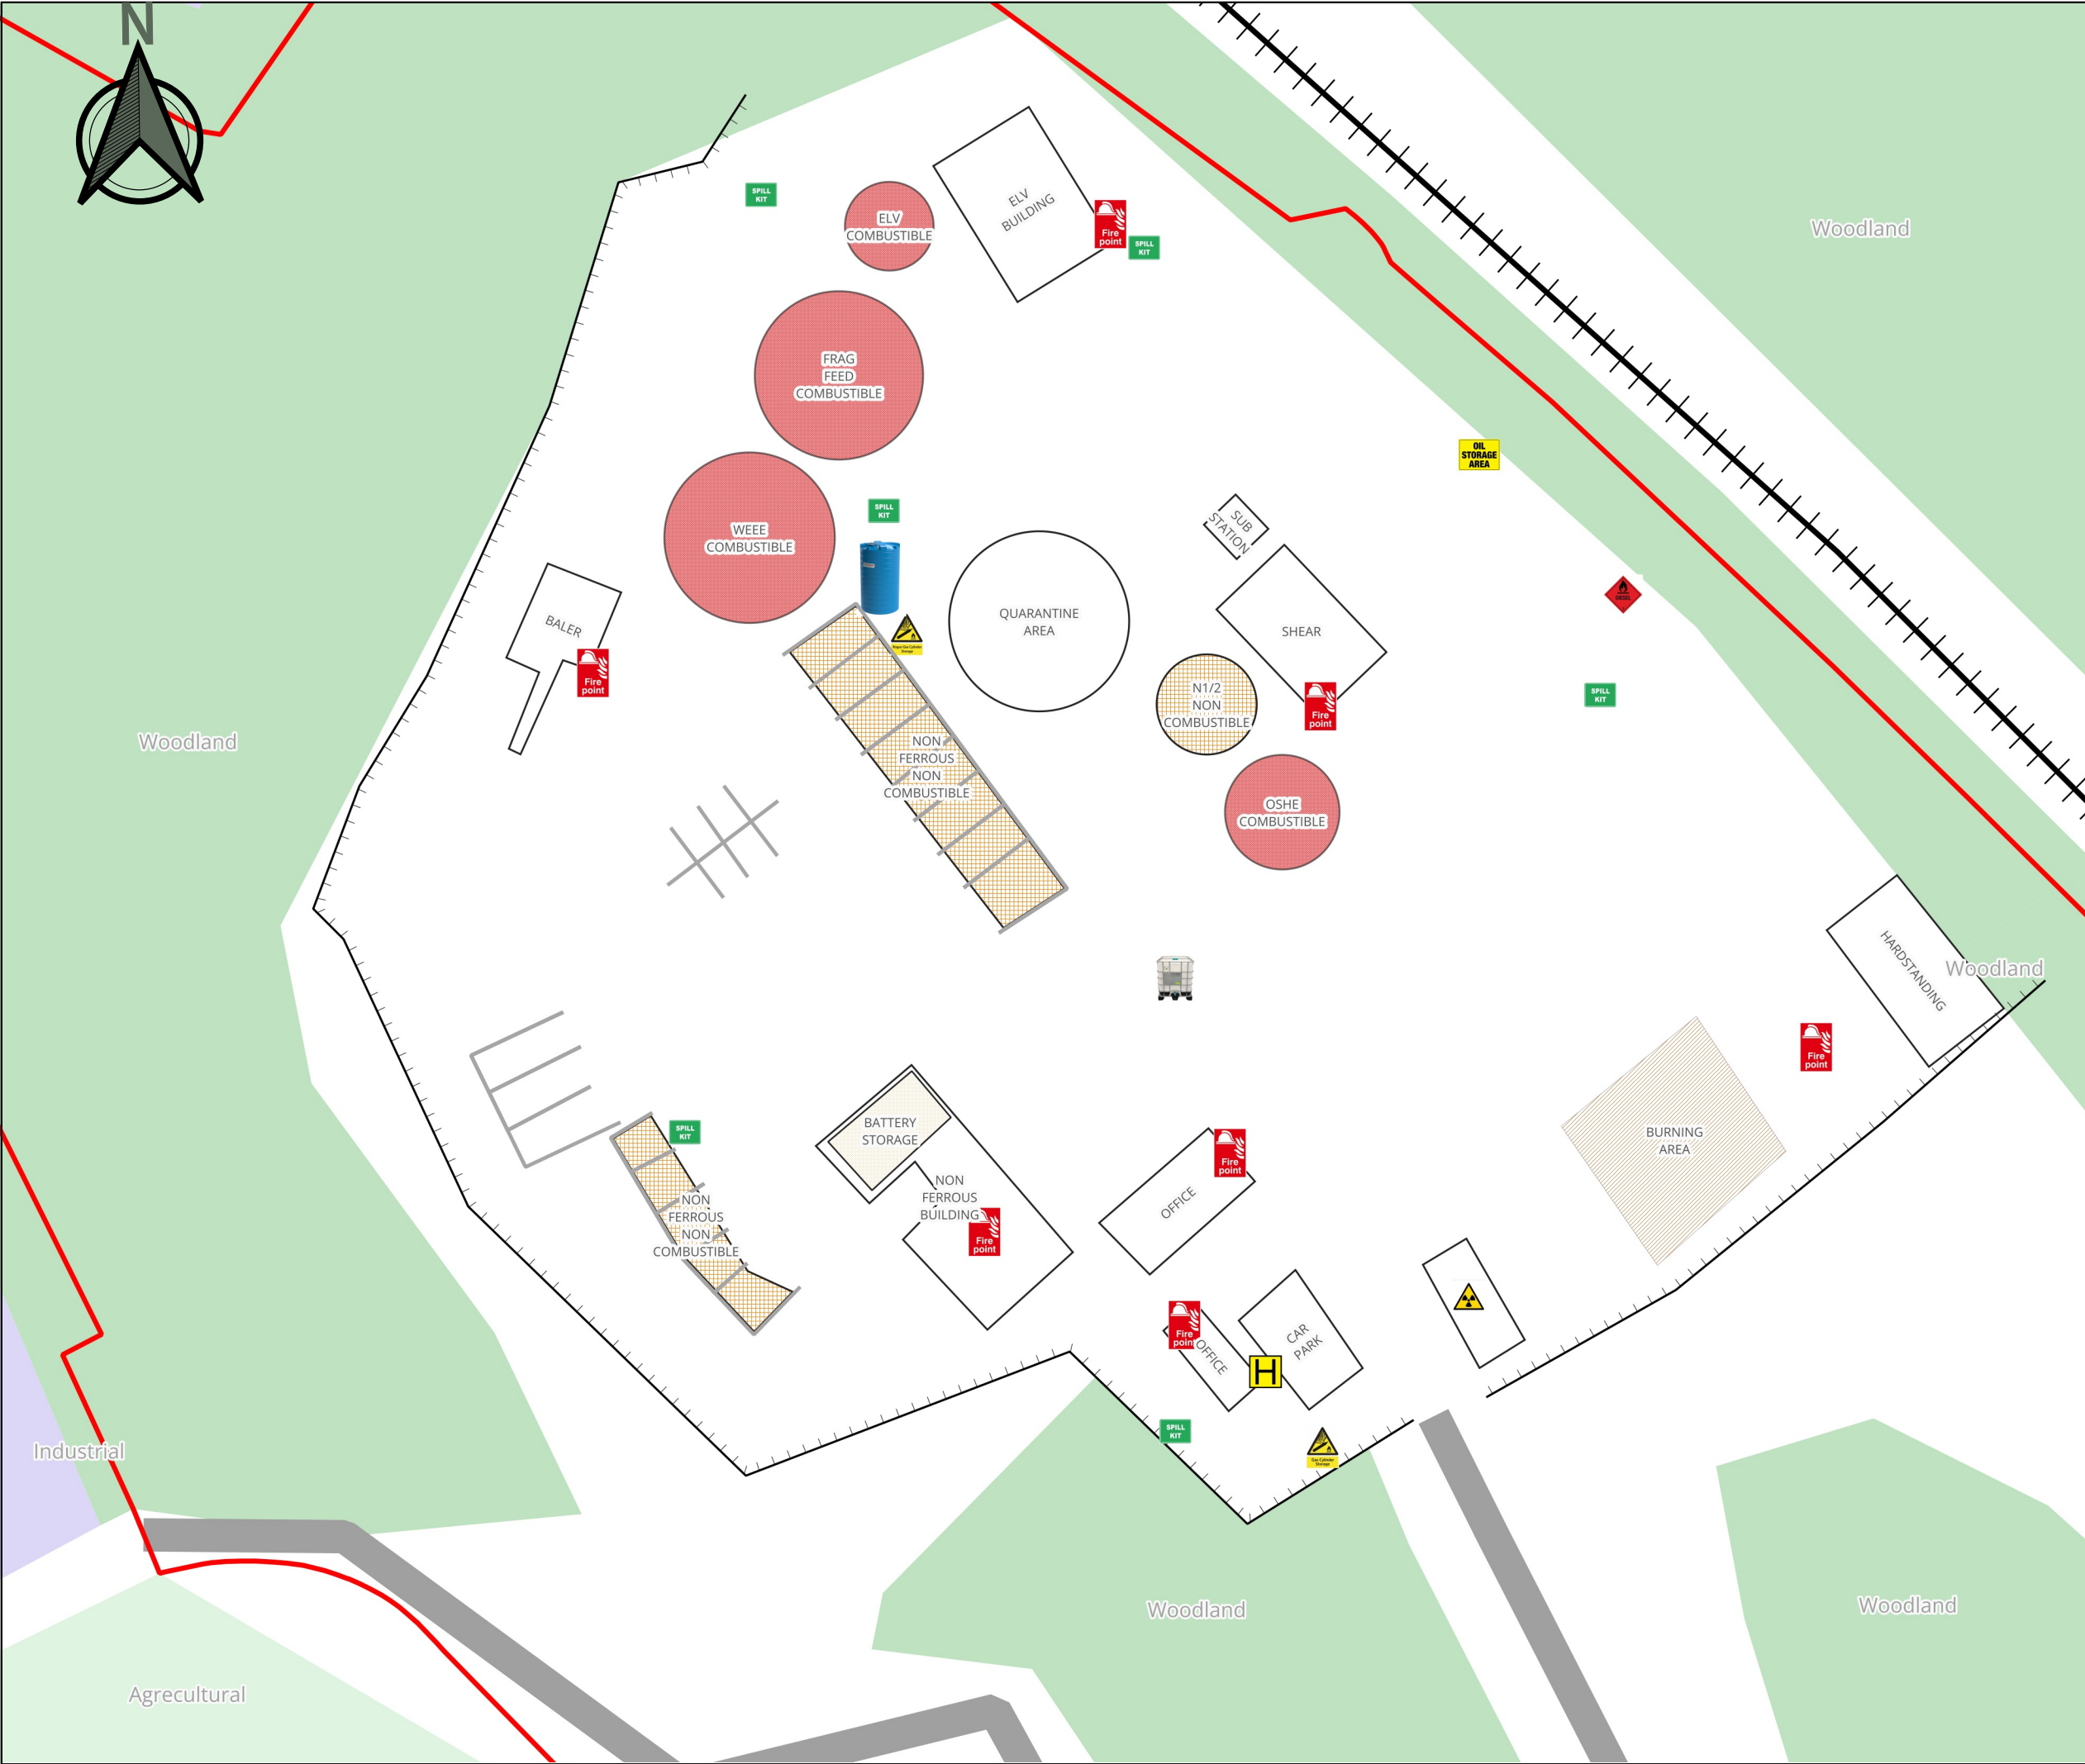

EMR New Alfreton Site Plan



Site: EMR New Alfreton

Drawing Name: Site Plan

Drawing No: EMR-Alfreton-001

Rev: a

Scale: 1:750

Date: 15/04/2026

Drawn By: Union



Red Line Boundary

Fence

Gate

Rail

Roads

Burning Area

Battery Storage

Non-Combustible

Combustible

Fire Point

Radiation Store

Diesel Tank

Spill Kit

Water Bombs (IBCs)

Offsite Hydrant

Gas Cylinder Store

Rogue Cylinder Store

30,000ltr Water Tank

Oil Storage

0

15

30 m

