


DO NOT SCALE

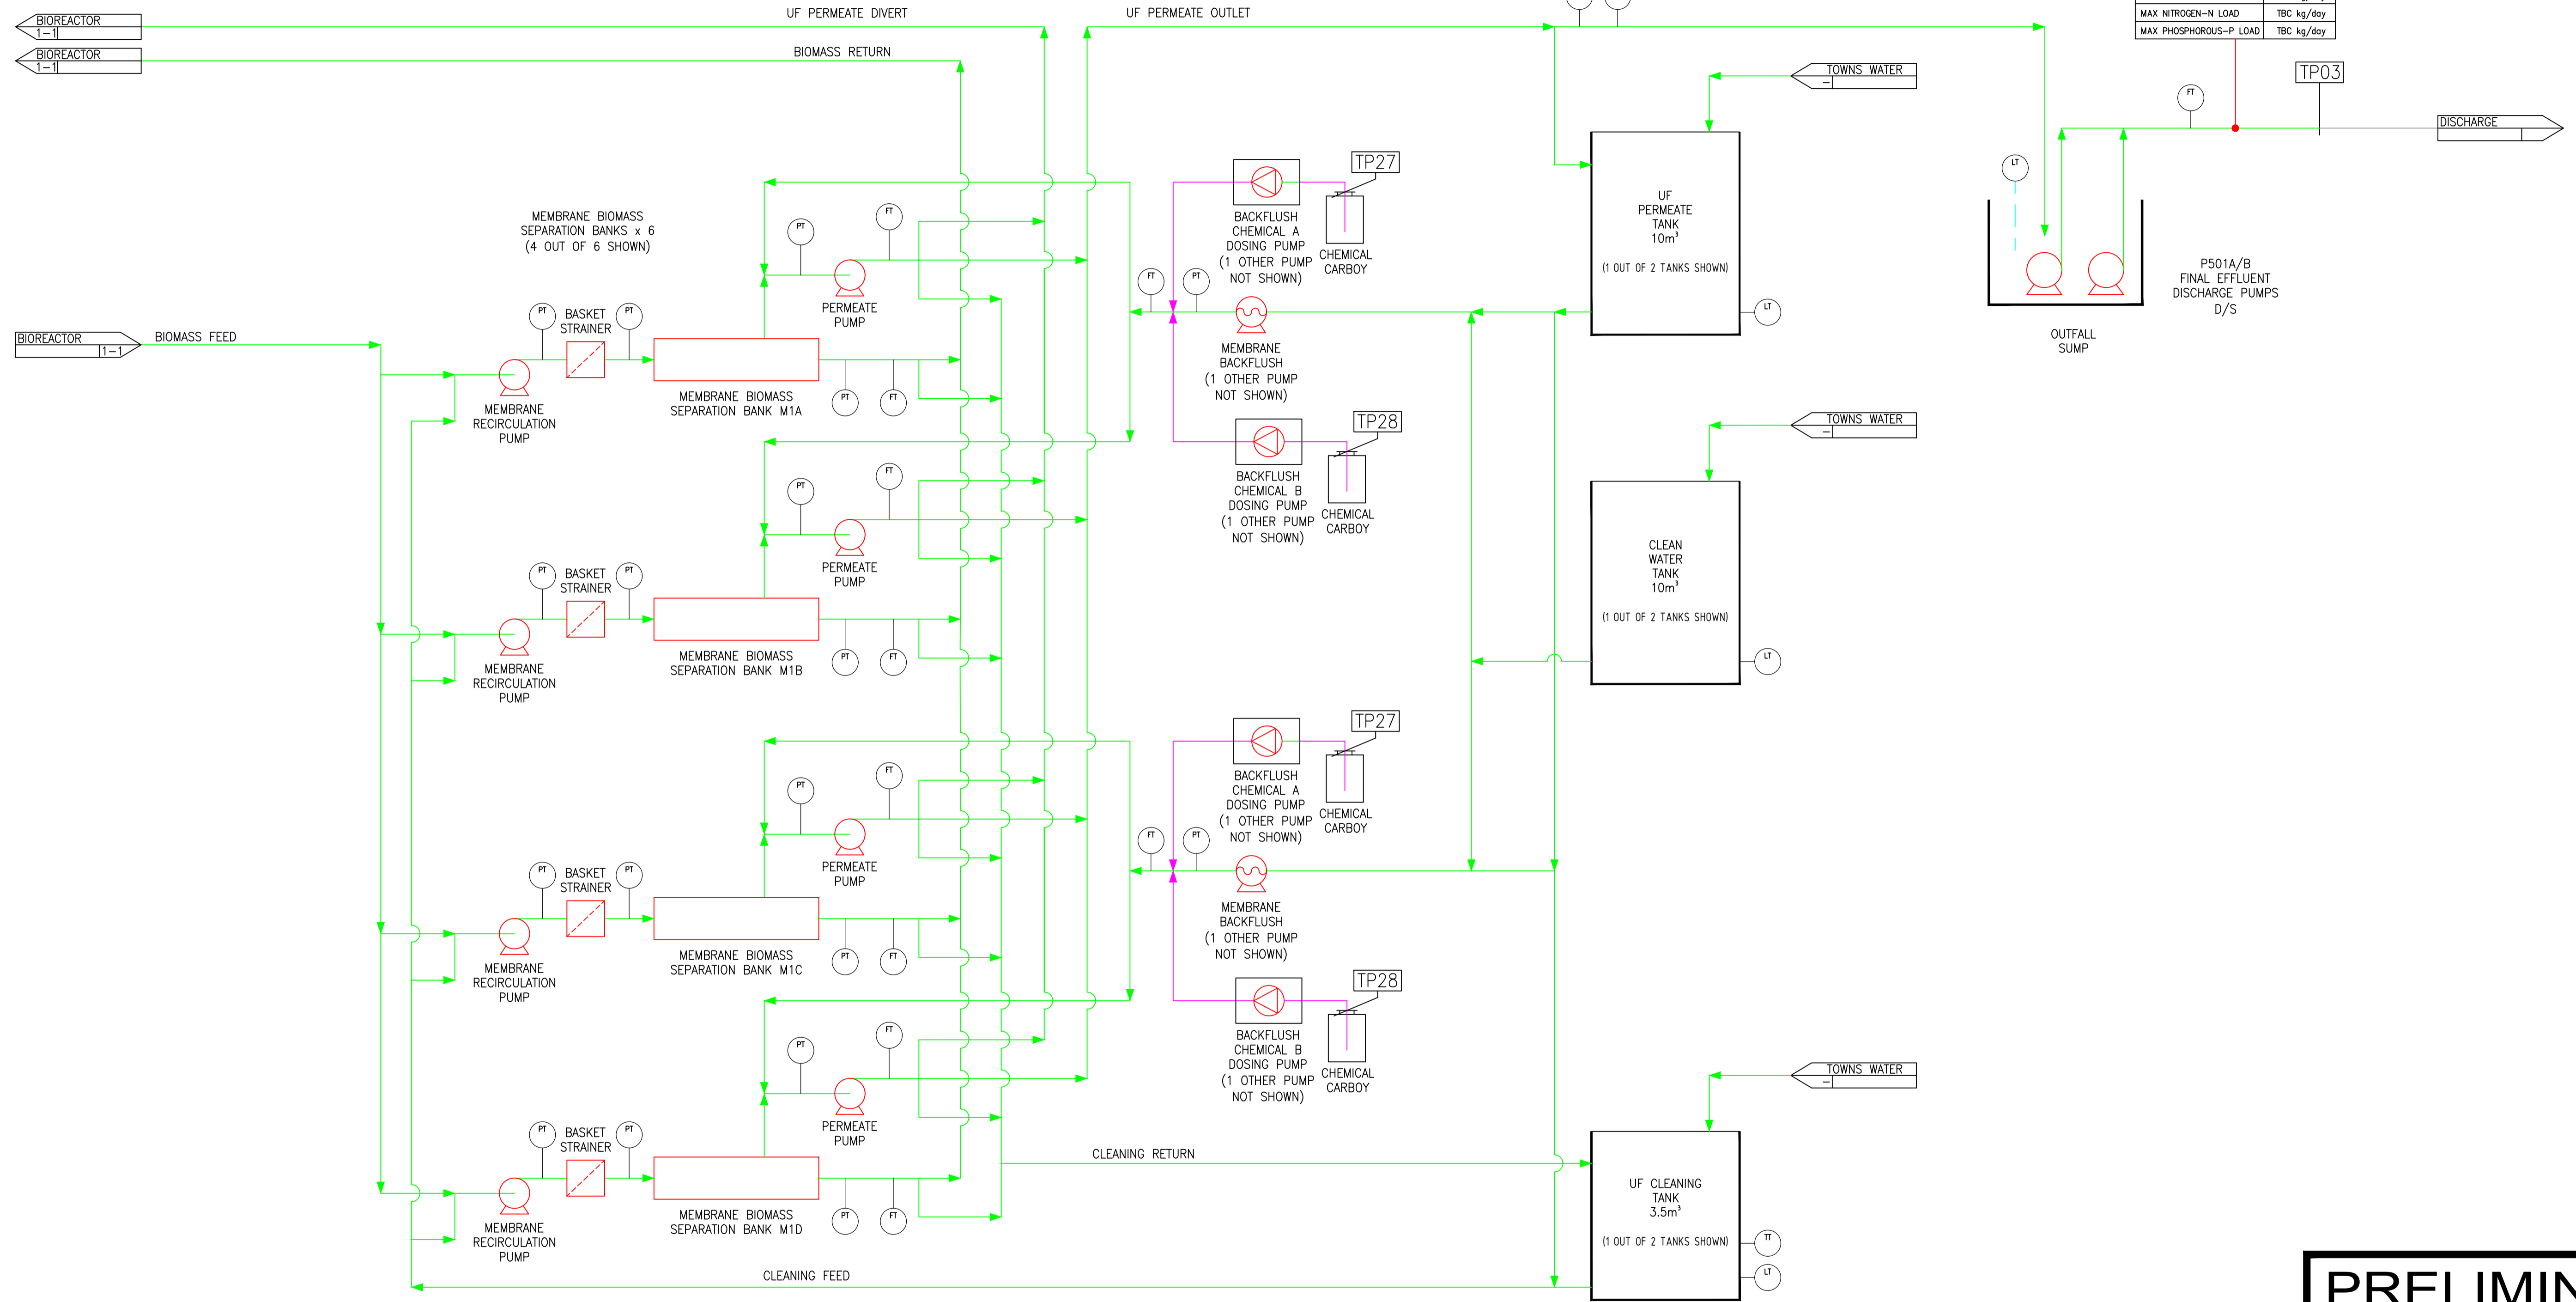

PRELIMINARY

0	FIRST ISSUE	XX/02/22	CA	DH
Rev No	Revision note	Date	By	Approved

Aquabio Limited
 Ball Mill Top Business Park, Hallow,
 Worcester, WR2 6LS
 Tel:- +44(0) 1905 641966
 email:- info@aquabio.co.uk

Aquabio Ltd is part of the Freudenberg Filtration Technology group of companies

This document contains proprietary information and is the property of Aquabio Ltd. It shall not be copied, reproduced, transmitted or communicated to third parties without explicit permission in writing, of Aquabio Ltd. Aquabio Ltd - Registered No 3379754 England

Client: LENZING WWRP

Title: PROCESS FLOW DIAGRAM - UF MEMBRANES

Drawing No	Rev.	Sheet	Scale
P5339-P01-2	0	2 OF 3	NTS

H