




1.

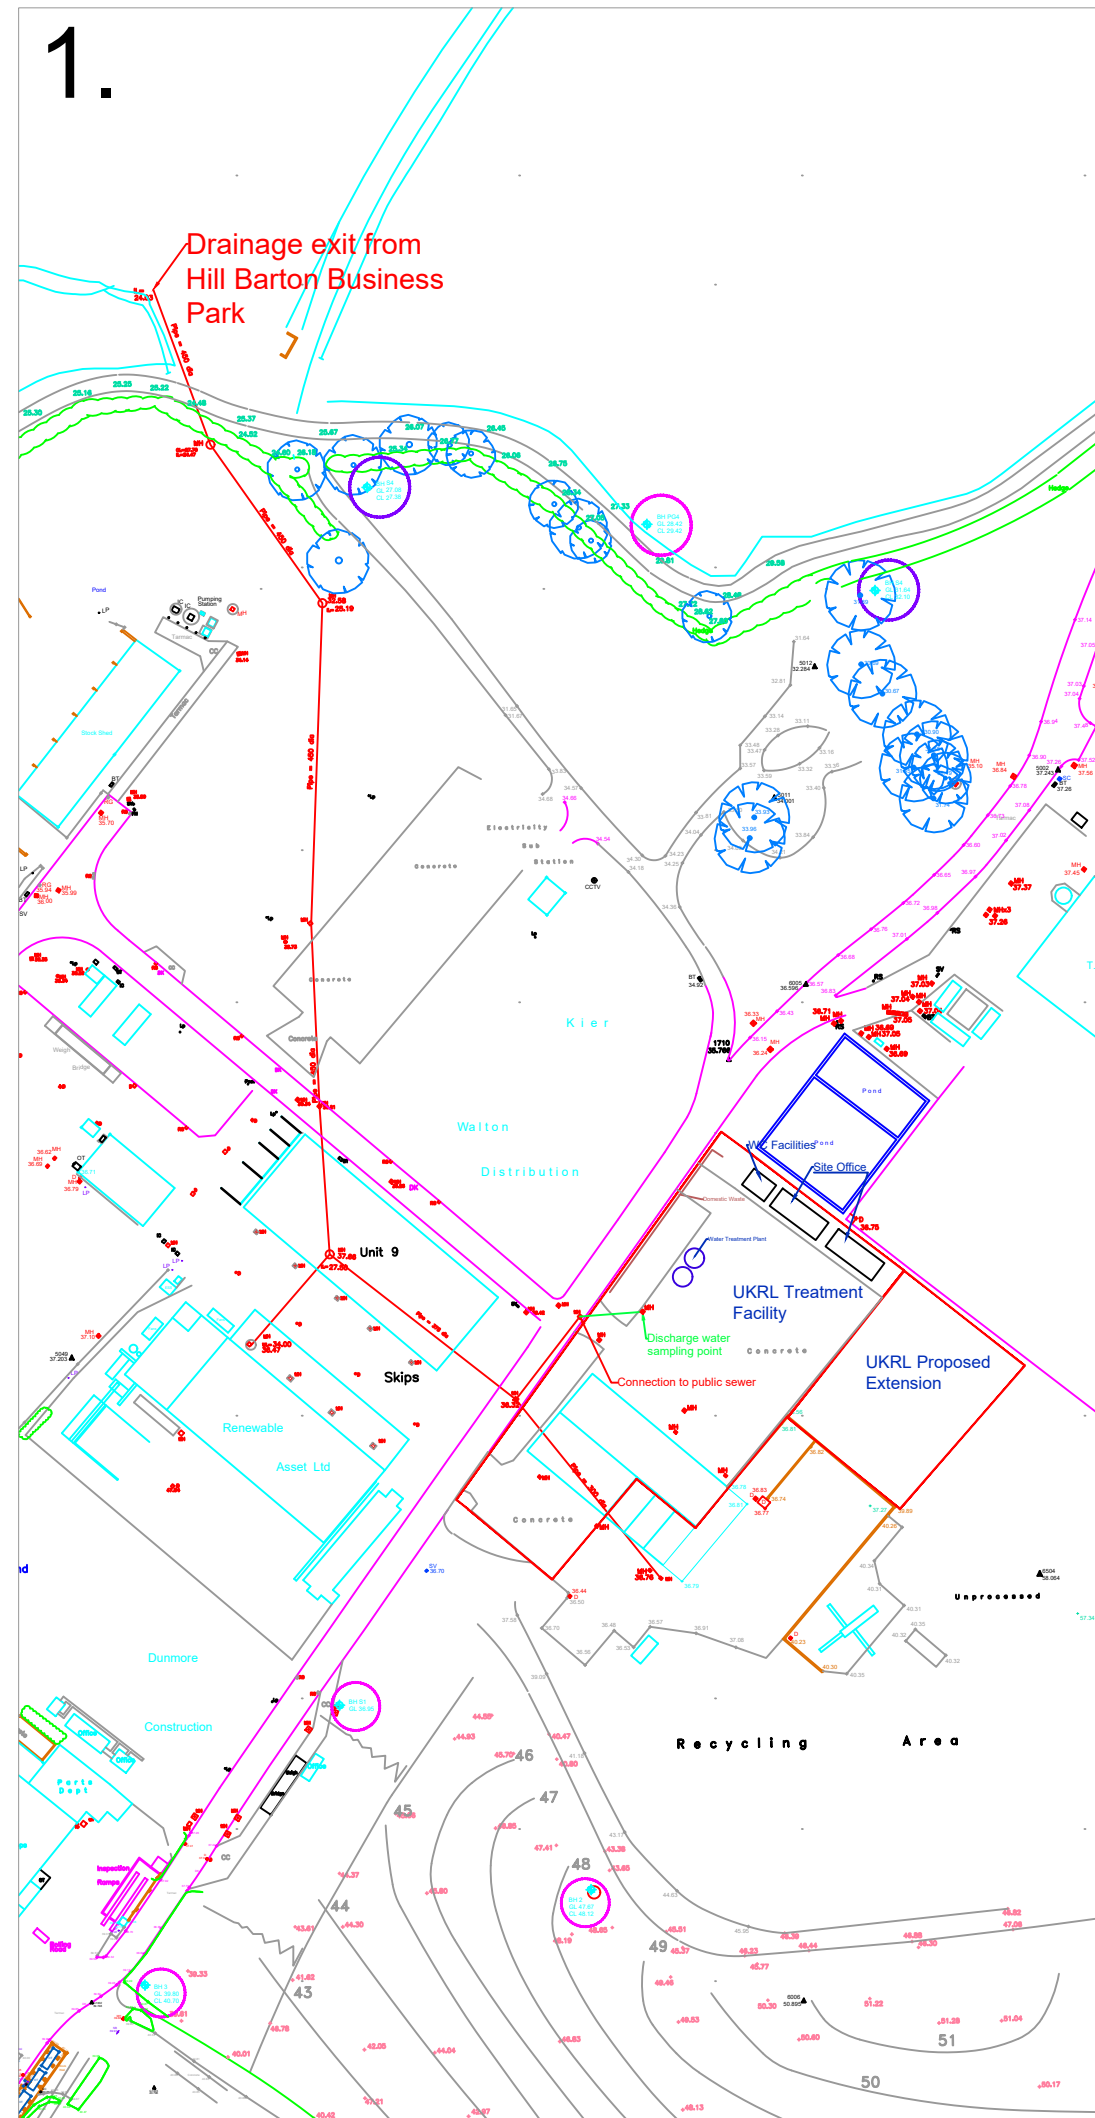

2.

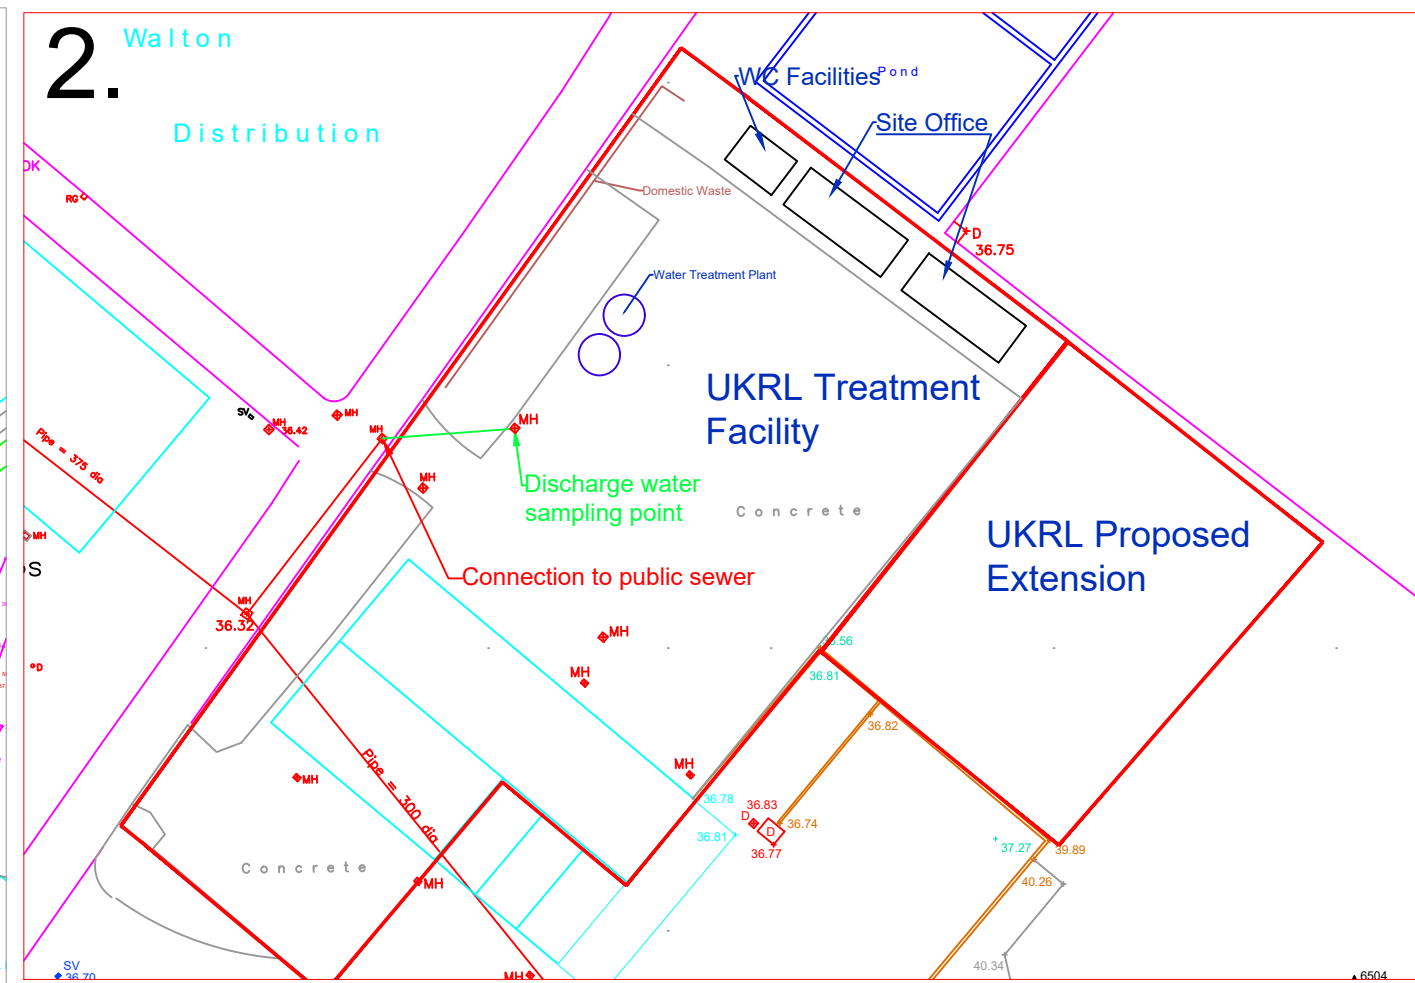

3.

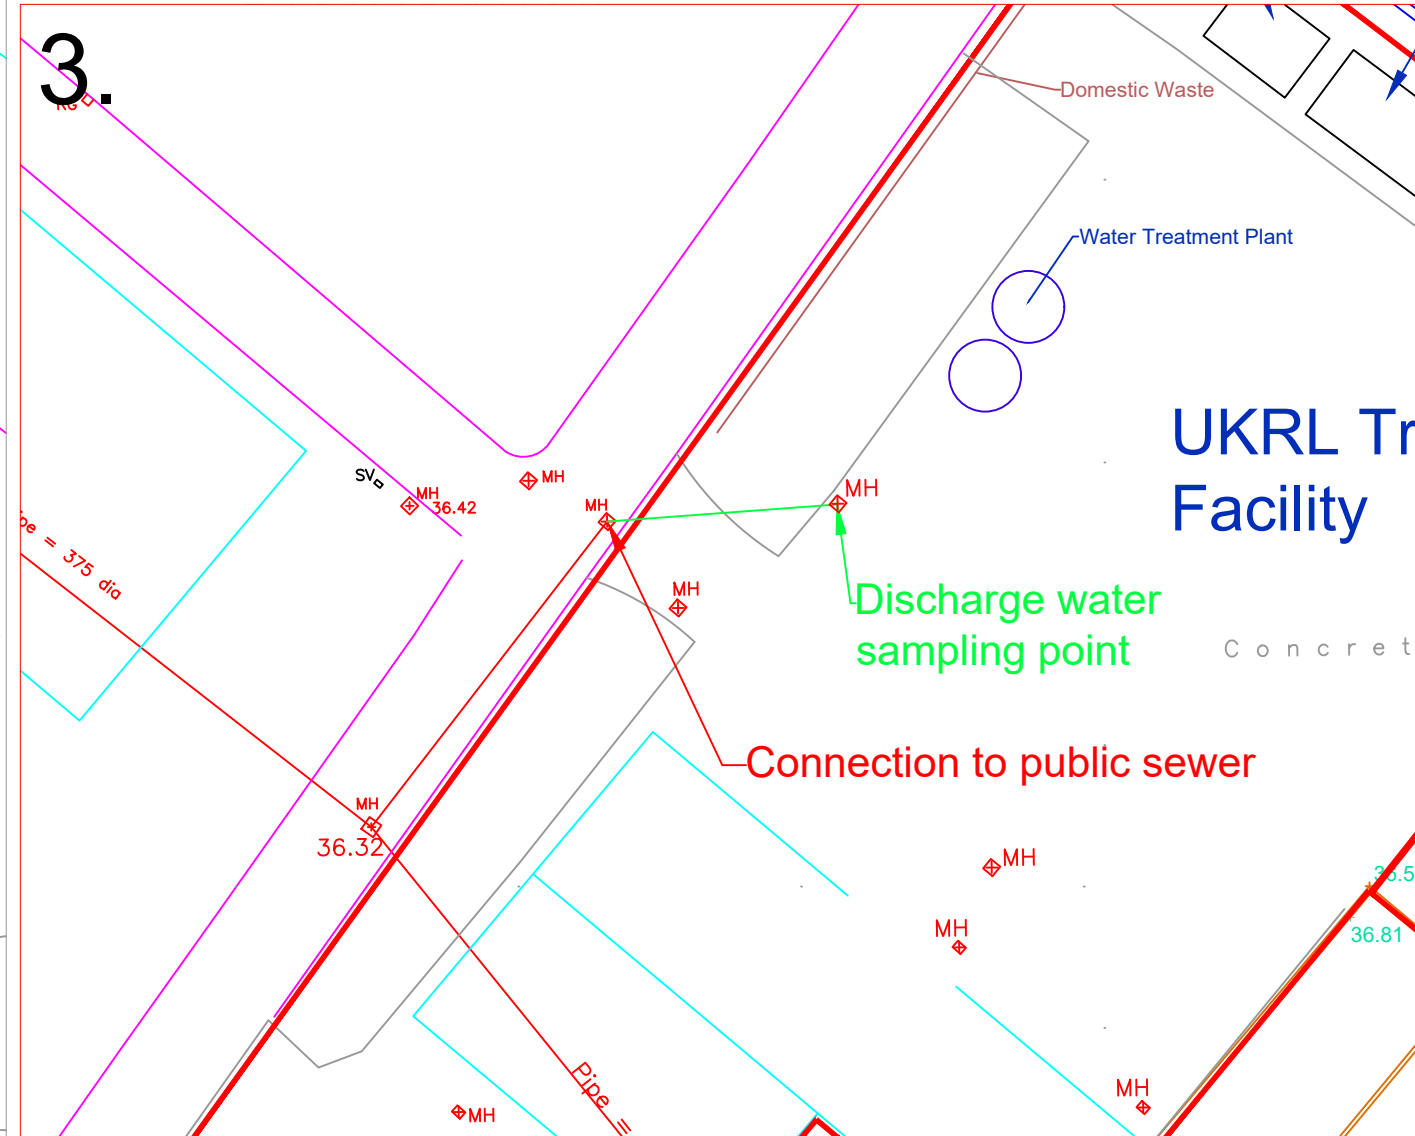

Viewport Key

1. Drainage overview
2. UKRL Site Plan
3. Connection to public sewer & location of sample point



3b Greystoke Business Centre,
Highstreet,
Portishead,
BS20 6PY,

T: 01179 244 990
E: enquiries@ukremediation.co.uk
W: www.ukremediation.co.uk

Drawing Title:
E7555UK.D05 - Drainage Plan

Drawing Number: E7555UK.D05	Rev: 01	Project Number: E7555UK
--------------------------------	------------	----------------------------

Client:
UK Remediation Ltd

Scale @ A3: NTS	Date: 20.03.25	Drawn: CB
--------------------	-------------------	--------------