



- Site Boundary
- Proposed Fence Line
- Retaining Wall
- Building Footprint
- Water Storage Tank (partially above ground)
- Concrete Slab
- Asphalt
- Compacted Type 1
- Mixed Scrub
- Retained Vegetation

Please refer to Drainage Layout Sheets 1-4 for details of drainage infrastructure

0344 8700 007
axis.co.uk



Client
Fortis IBA Ltd
Project
Hillhouse IBA
Drawing Title

Site Layout Plan

Scale
1:1500 @A3

Date
July 2024

Dwg no
3566-01-03

Status
--


Drawn
JD

Checked
LM

This drawing is the copyright of AXIS P.E.D Limited and may not be loaned, copied or reproduced in any way - or used for any offer, quote, tender or construction purposes without written consent of the company to do so. Follow any figured dimensions - do not scale for construction purposes. If in doubt ask.

Reproduced by permission of Ordnance Survey on behalf of HMSO. © Crown copyright & database right 2023. All rights reserved. Ordnance Survey Licence number AL 100036678



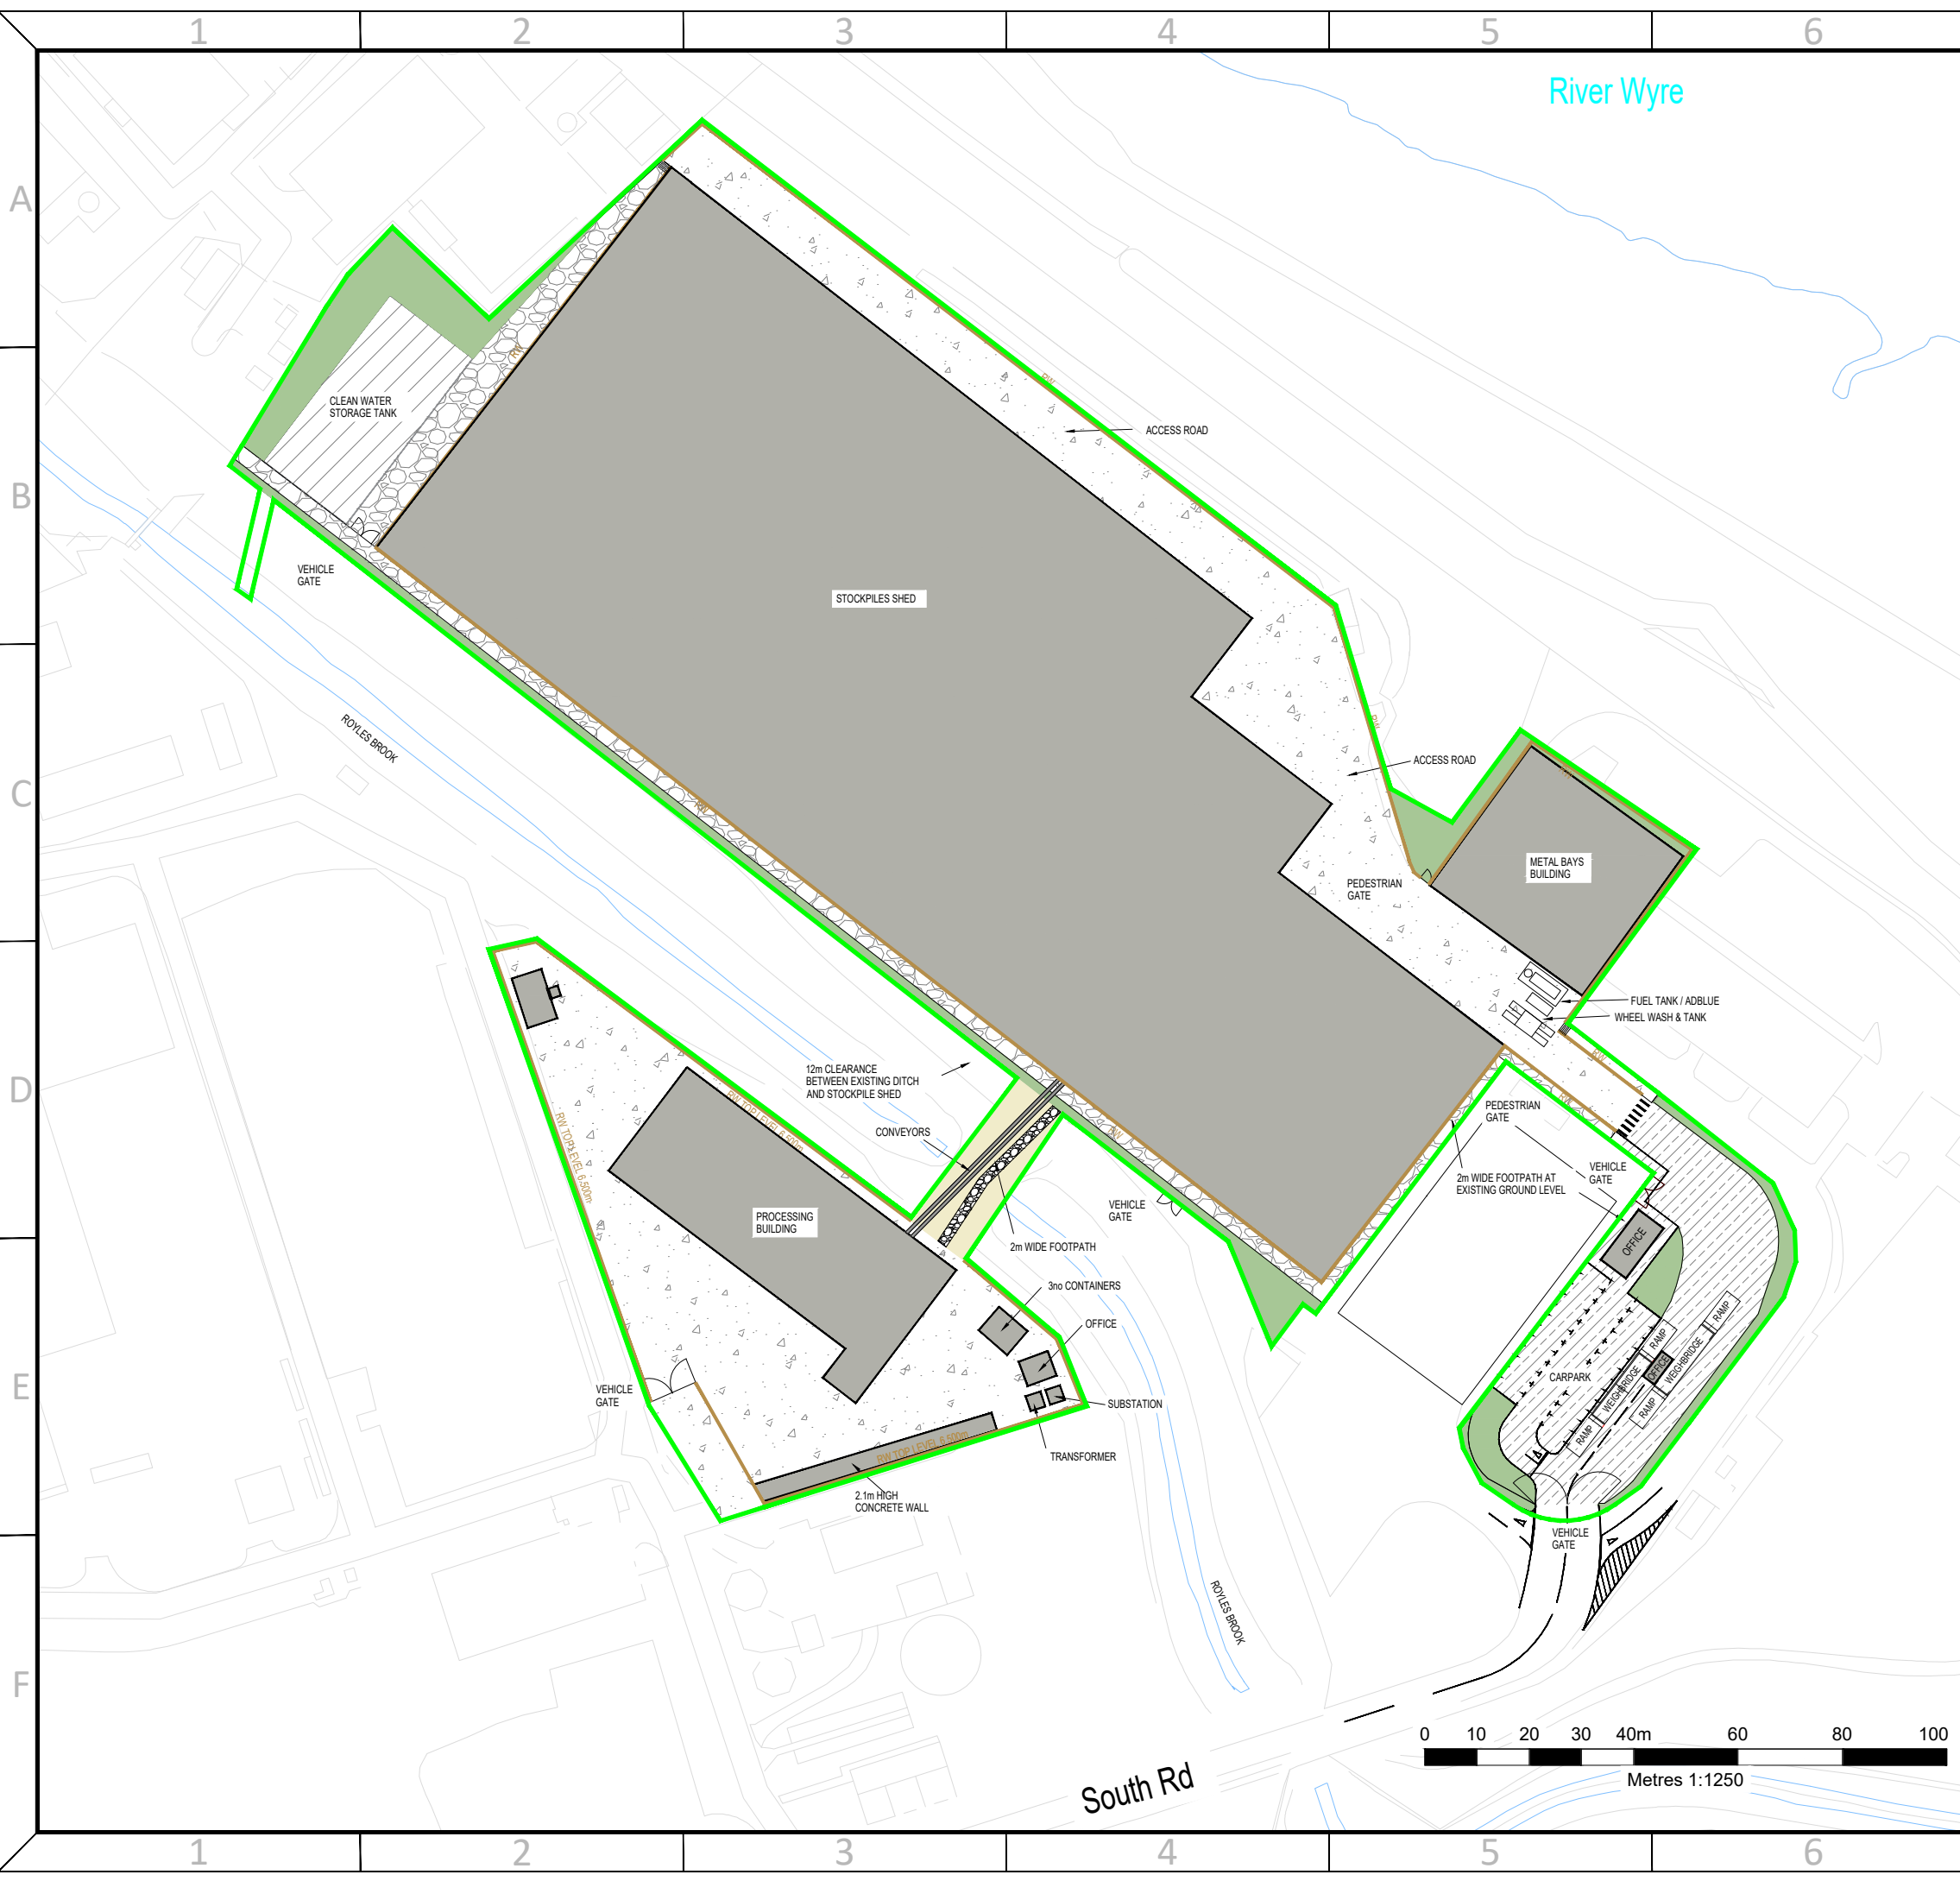

ALL INFORMATION ON THIS DRAWING IS INDICATIVE ONLY, AND MAY BE SUBJECT TO FURTHER DESIGN DEVELOPMENT.

DO NOT SCALE

NOTES:
— INSTALLATION BOUNDARY

R2.0	INSTALLATION BOUNDARY EDIT	EMC	DTW	SMN	27.08.24	
R1.0	PRELIMINARY		DTW	AO1	ACM	15.07.24
REV.	DETAILS OF REVISION	DRAWN	CHKD	APR	DATE	


FICHTNER
CONSULTING ENGINEERS LIMITED

Kingsgate, Wellington Road North,
Stockport, Cheshire, SK4 1LW, UK
Tel: 0161 476 0032
Website: www.fichtner.co.uk

CLIENT: FORTIS IBA LIMITED
SITE: HILLHOUSE
PROJECT: HILLHOUSE IBA
TITLE: INSTALLATION BOUNDARY

DRAWING STATUS:		PRELIMINARY
DRAWN BY:	DTW	DATE: 15.07.24
CHECKED BY:	AO1	DATE: 15.07.24
APPROVED BY:	ACM	DATE: 15.07.24
FILENAME:	4148-8310-0001DW INSTALLATION BOUNDARY R1.0	
OFFICE OF ISSUE:	STOCKPORT	
SHEET SIZE:	A3	SCALE: 1:1250

DRAWING No.: **4148-8310-0001** Sheet 1 Of 1 REVISION: **R2.0**

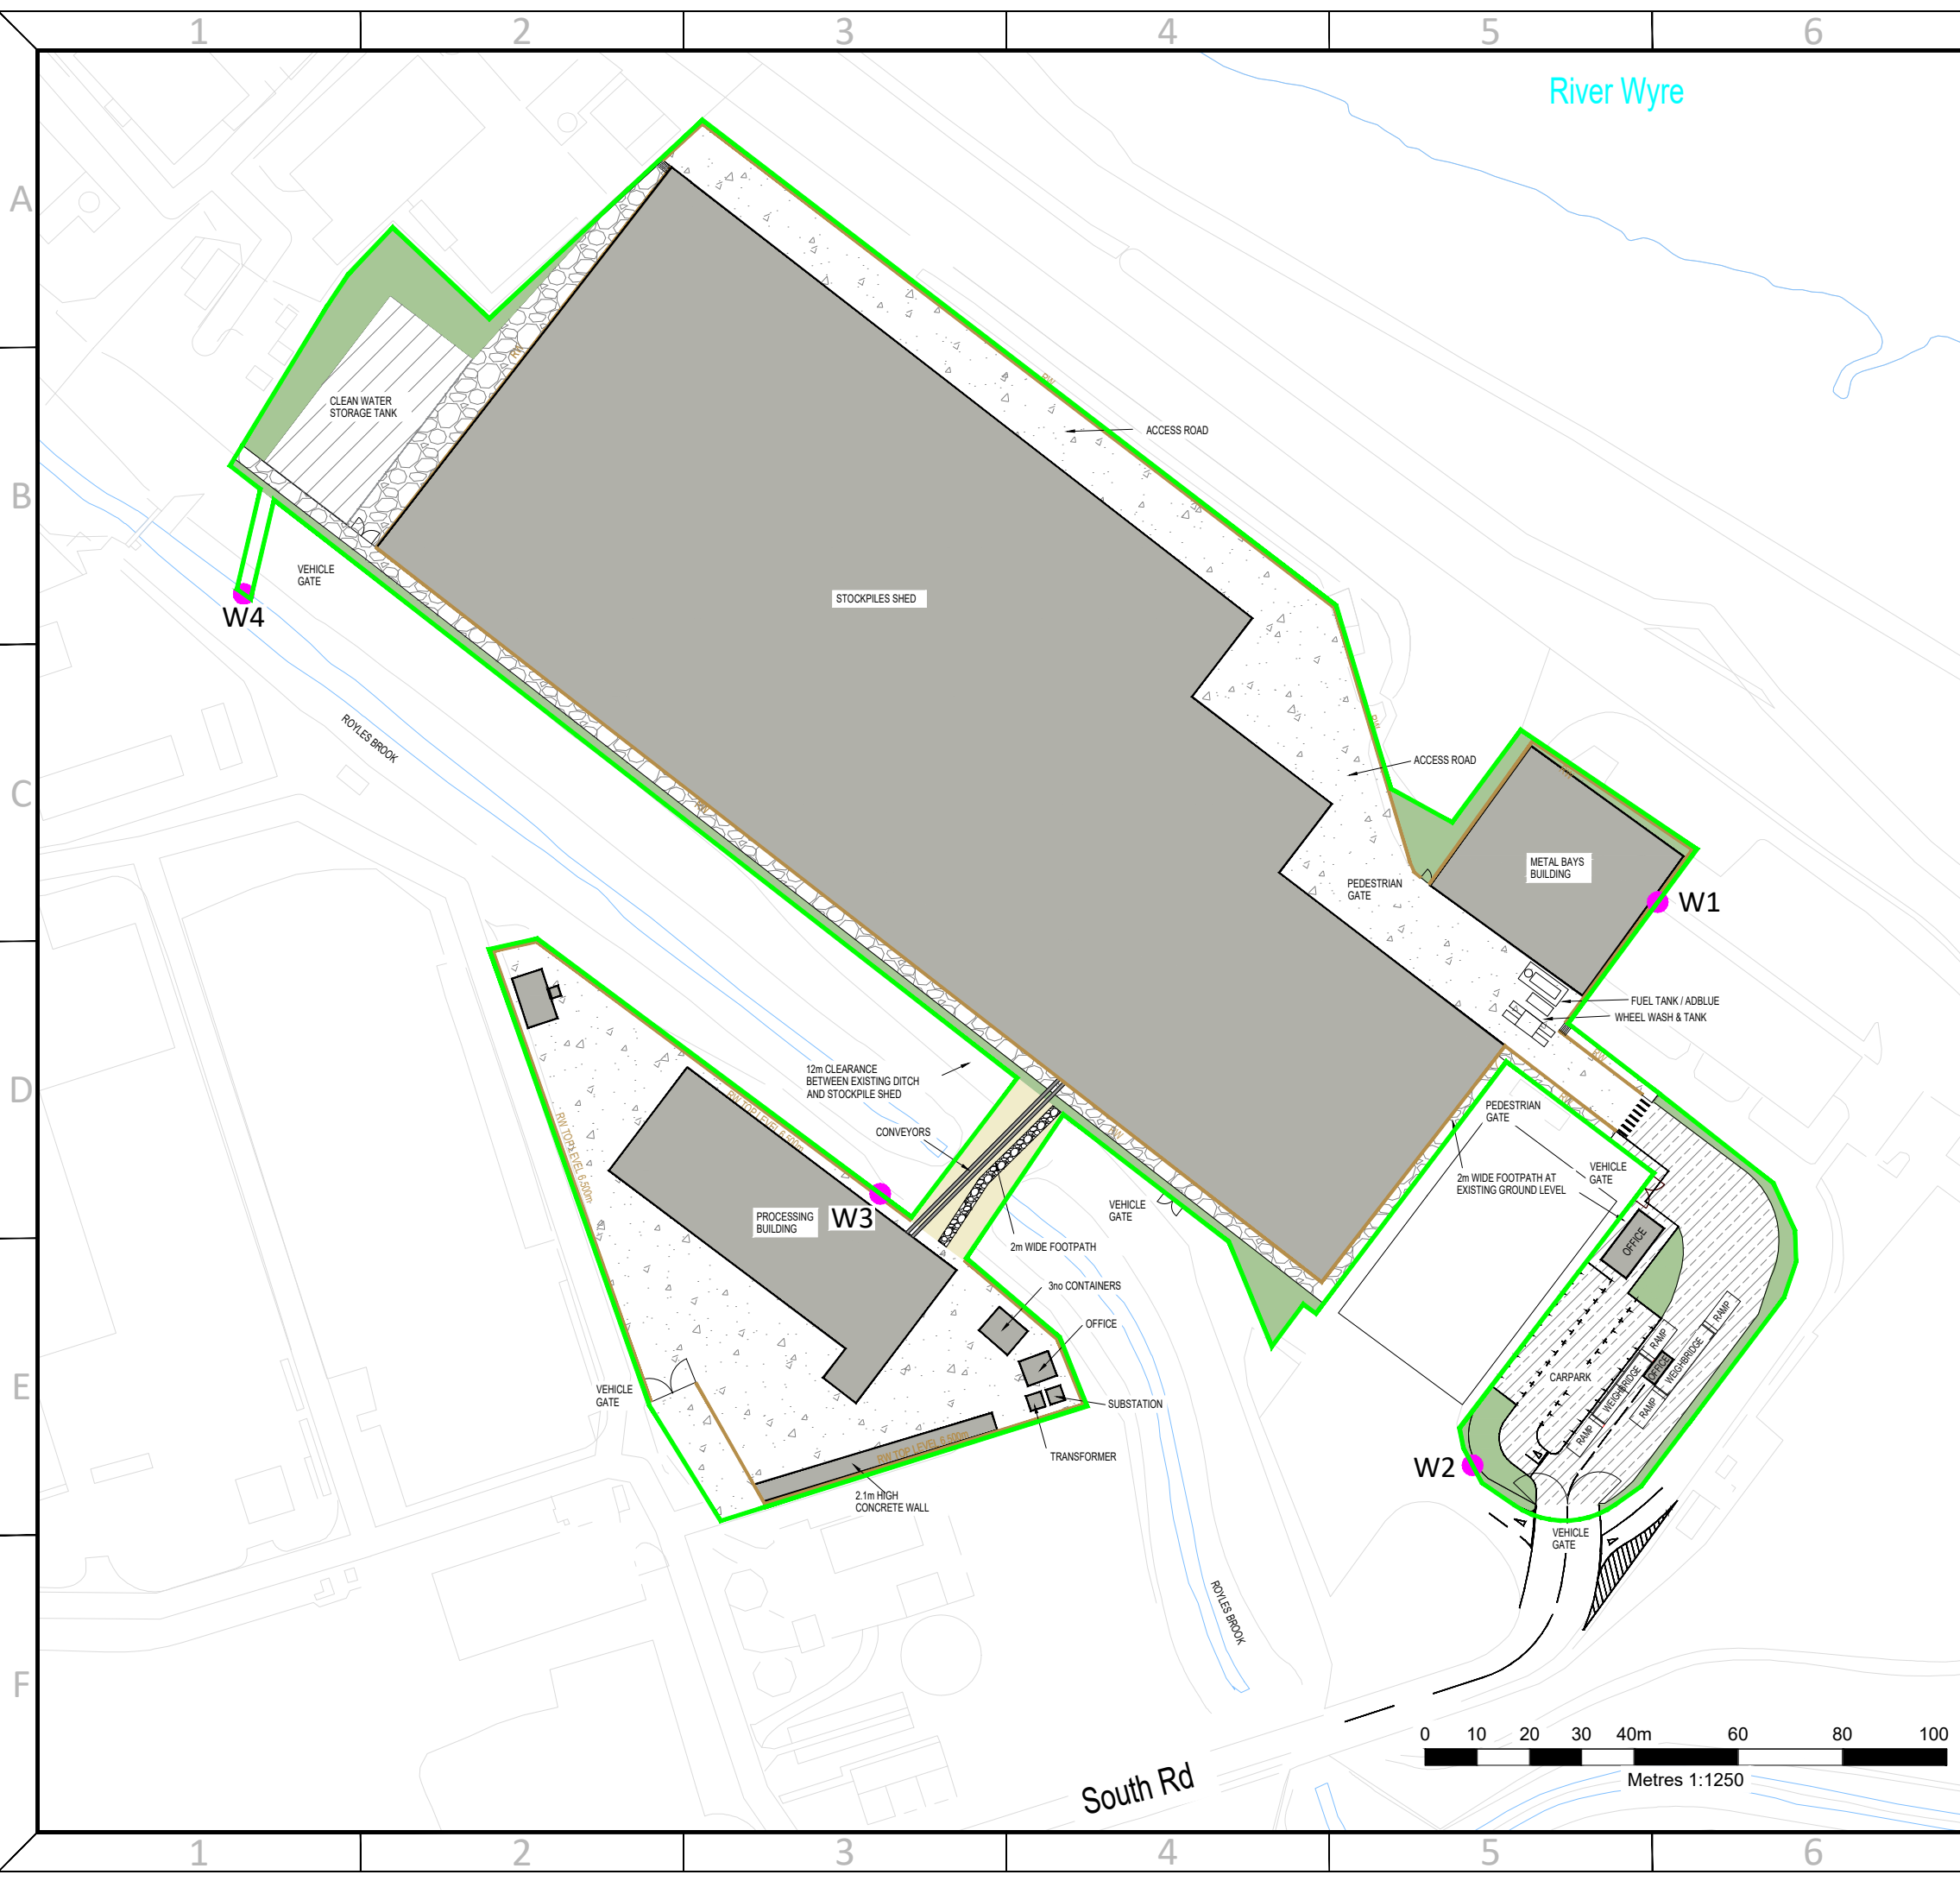

ALL INFORMATION ON THIS DRAWING IS INDICATIVE ONLY, AND MAY BE SUBJECT TO FURTHER DESIGN DEVELOPMENT.

DO NOT SCALE

NOTES:
— INSTALLATION BOUNDARY


R3.0	INSTALLATION BOUNDARY EDIT	EMC	DTW	SMN	27.08.24
R2.0	PRELIMINARY	EMC	DTW	ACM	19.08.24
R1.0	PRELIMINARY	DTW	AO1	ACM	15.07.24
REV.	DETAILS OF REVISION	DRAWN	CHKD	APR	DATE

FICHTNER
 CONSULTING ENGINEERS LIMITED
 Kingsgate, Wellington Road North,
 Stockport, Cheshire, SK4 1LW, UK
 Tel: 0161 476 0032
 Website: www.fichtner.co.uk

CLIENT: FORTIS IBA LIMITED
 SITE: HILLHOUSE
 PROJECT: HILLHOUSE IBA
 TITLE: EMISSIONS POINTS

DRAWING STATUS:		PRELIMINARY
DRAWN BY:	DTW	DATE: 15.07.24
CHECKED BY:	AO1	DATE: 15.07.24
APPROVED BY:	ACM	DATE: 15.07.24
FILENAME:	4148-8310-0002DW EMISSIONS POINTS R3.0	
OFFICE OF ISSUE:	STOCKPORT	
SHEET SIZE:	A3	SCALE: 1:1250

DRAWING No.: **4148-8310-0002** Sheet 1 Of 1 REVISION: **R3.0**

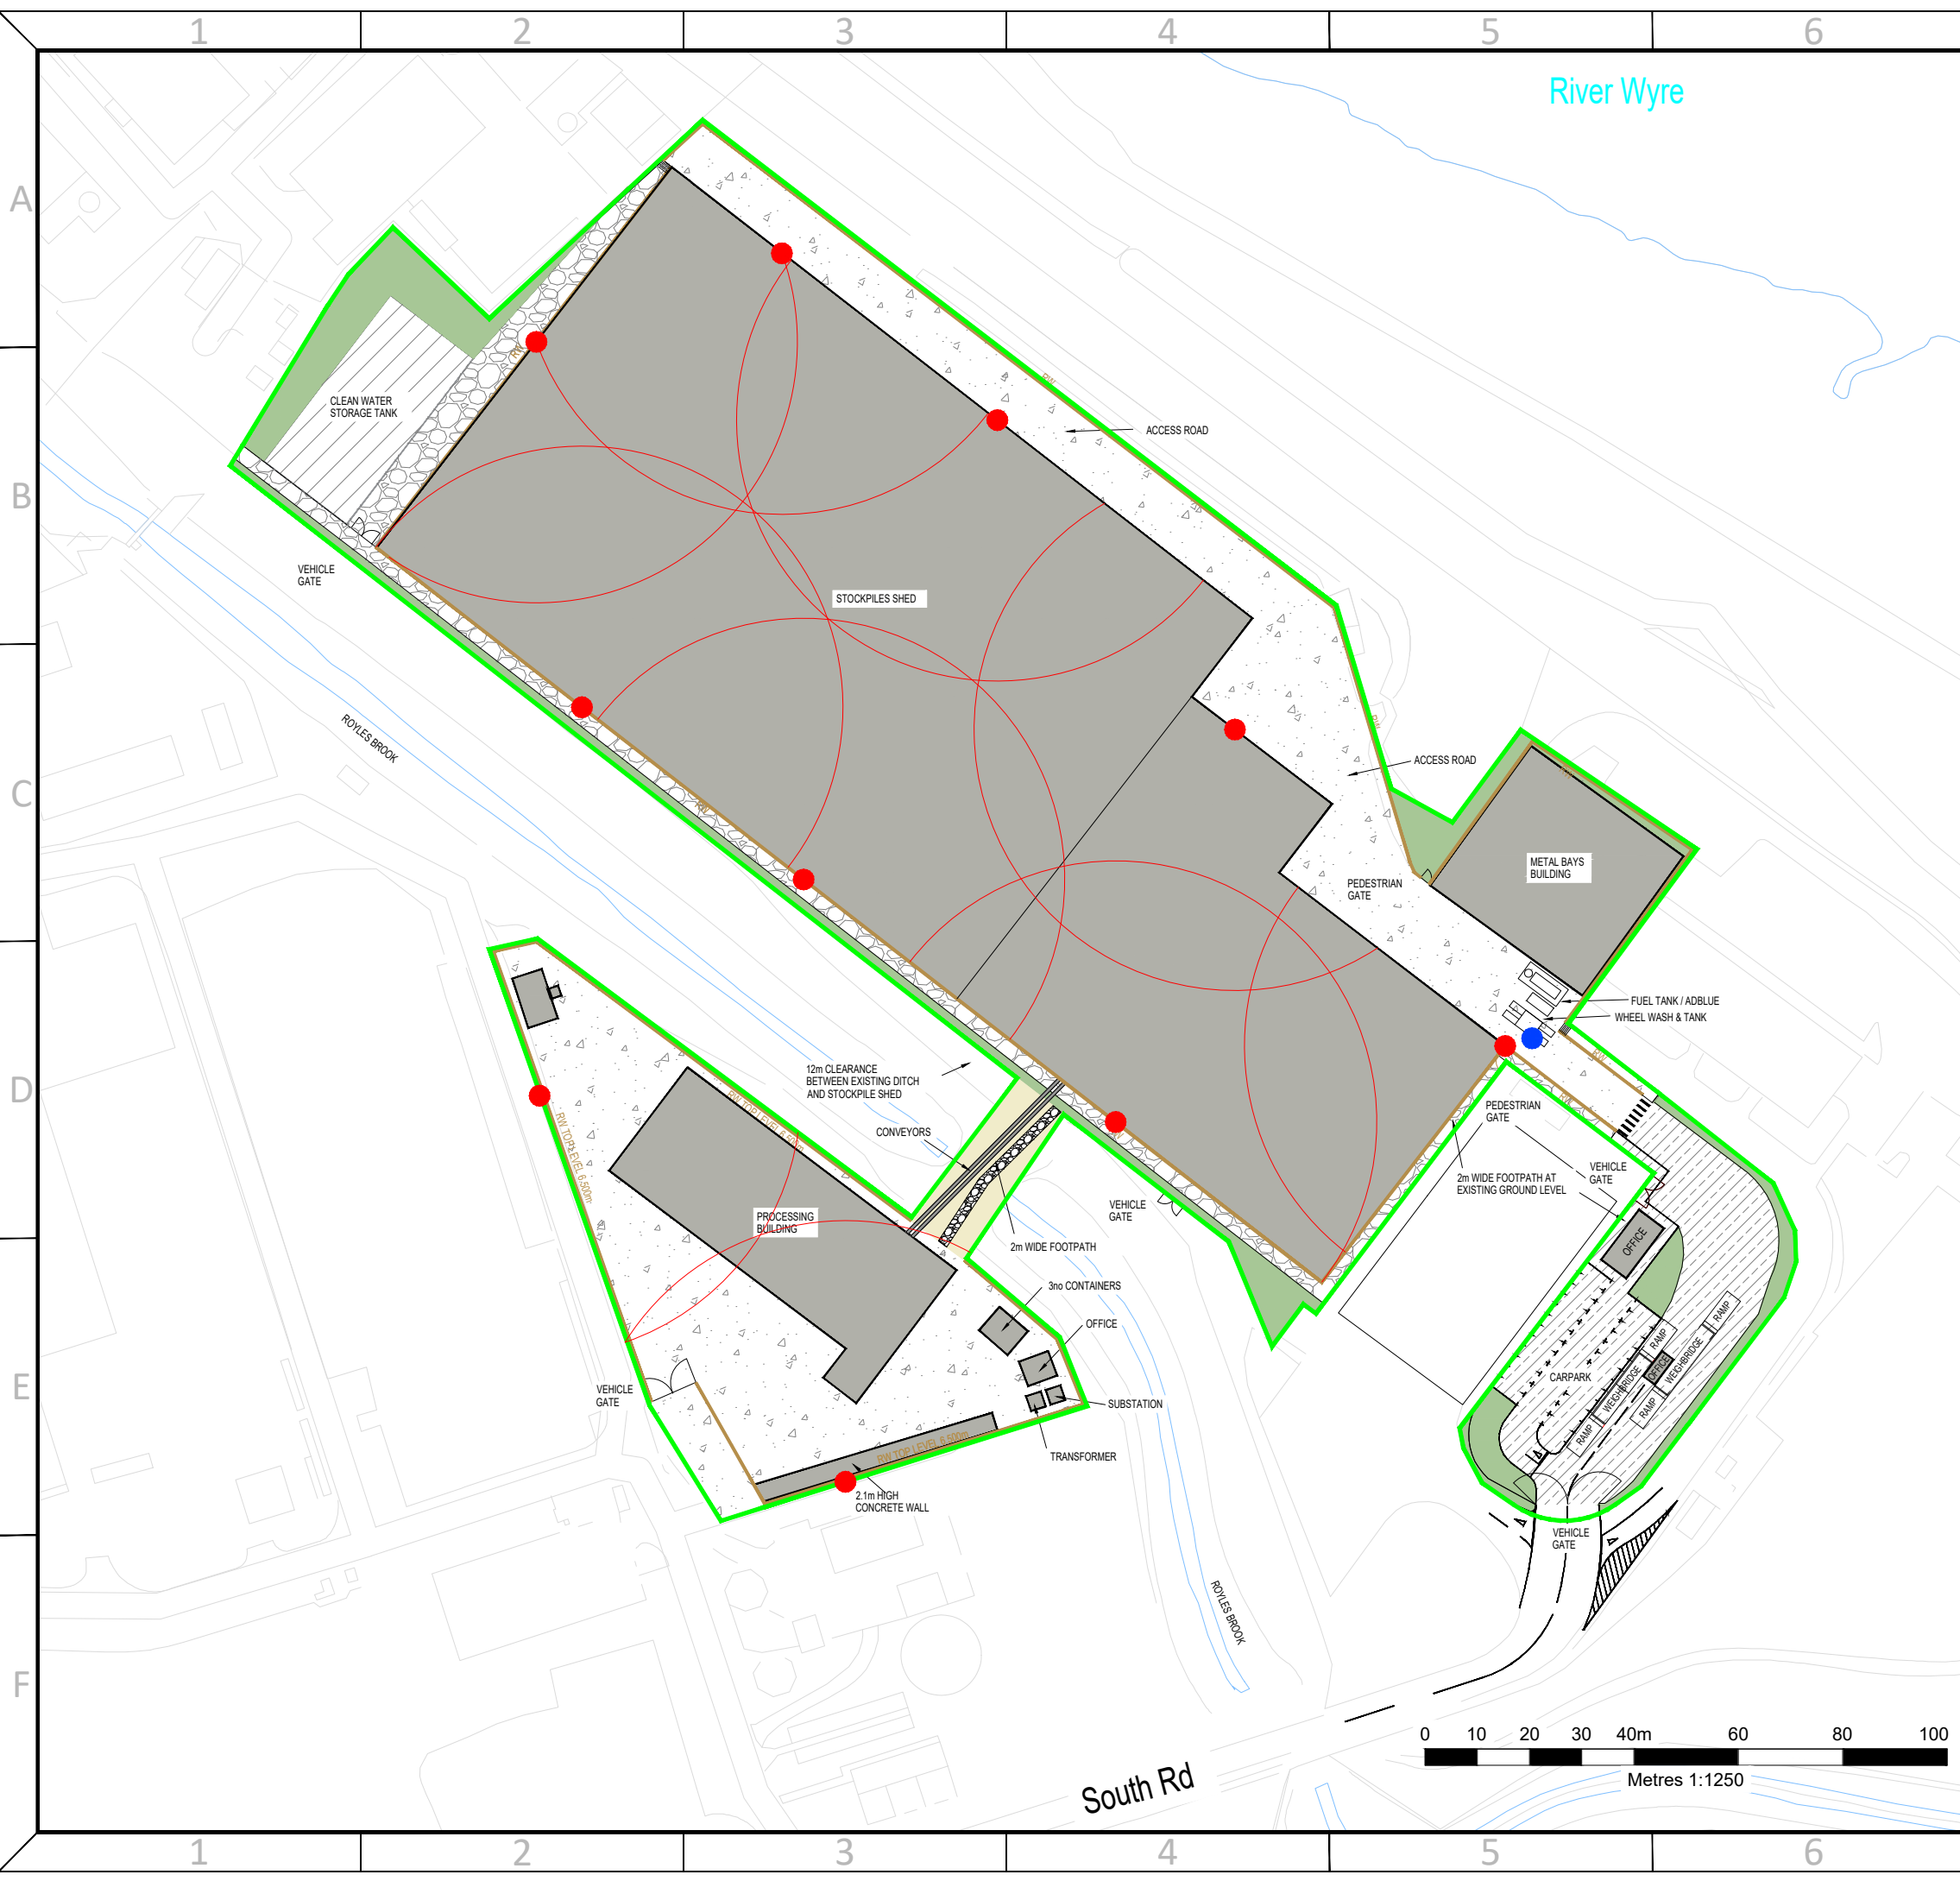

ALL INFORMATION ON THIS DRAWING IS INDICATIVE ONLY, AND MAY BE SUBJECT TO FURTHER DESIGN DEVELOPMENT.

DO NOT SCALE

NOTES:

- INSTALLATION BOUNDARY
- RAIN GUNS / RAIN GUN DUST SUPPRESSION AREA
- WHEEL WASH

R2.0	PRELIMINARY	EMC	DTW	SMN	28.08.24
R1.0	PRELIMINARY	DTW	AO1	ACM	17.07.24
REV.	DETAILS OF REVISION	DRAWN	CHKD	APR	DATE

FICHTNER
CONSULTING ENGINEERS LIMITED

Kingsgate, Wellington Road North,
Stockport, Cheshire, SK4 1LW, UK
Tel: 0161 476 0032
Website: www.fichtner.co.uk

CLIENT: **FORTIS IBA LIMITED**


SITE: **HILLHOUSE**

PROJECT: **HILLHOUSE IBA**

TITLE: **INDICATIVE DUST SUPPRESSION**

DRAWING STATUS: PRELIMINARY	
DRAWN BY: DTW	DATE: 17.07.24
CHECKED BY: AO1	DATE: 17.07.24
APPROVED BY: ACM	DATE: 17.07.24
FILENAME: 4148-8310-0003DW INDICATIVE DUST SUPPRESSION R2.0	
OFFICE OF ISSUE: STOCKPORT	
SHEET SIZE: A3	SCALE: 1:1250

 DRAWING No.: **4148-8310-0003** Sheet 1 Of 1 REVISION: **R2.0**





ALL INFORMATION ON THIS DRAWING IS INDICATIVE ONLY, AND MAY BE SUBJECT TO FURTHER DESIGN DEVELOPMENT.

DO NOT SCALE

- NOTES:
- INSTALLATION BOUNDARY
 - STORAGE AREAS

R2.0	INSTALLATION BOUNDARY EDIT	EMC	DTW	SMN	27.08.24	
R1.0	PRELIMINARY		DTW	AO1	ACM	23.07.24
REV.	DETAILS OF REVISION	DRAWN	CHKD	APR	DATE	


FICHTNER
CONSULTING ENGINEERS LIMITED

Kingsgate, Wellington Road North,
Stockport, Cheshire, SK4 1LW, UK
Tel: 0161 476 0032
Website: www.fichtner.co.uk

CLIENT:	FORTIS IBA LIMITED
SITE:	HILLHOUSE
PROJECT:	HILLHOUSE IBA
TITLE:	STORAGE AREAS

DRAWING STATUS:	PRELIMINARY	
DRAWN BY:	DTW	DATE: 23.07.24
CHECKED BY:	AO1	DATE: 23.07.24
APPROVED BY:	ACM	DATE: 23.07.24
FILENAME:	4148-8310-0004DW STORAGE AREAS R2.0	
OFFICE OF ISSUE:	STOCKPORT	
SHEET SIZE:	A3	SCALE: 1:1250

DRAWING No.: **4148-8310-0004** Sheet 1 Of 1 REVISION: **R2.0**

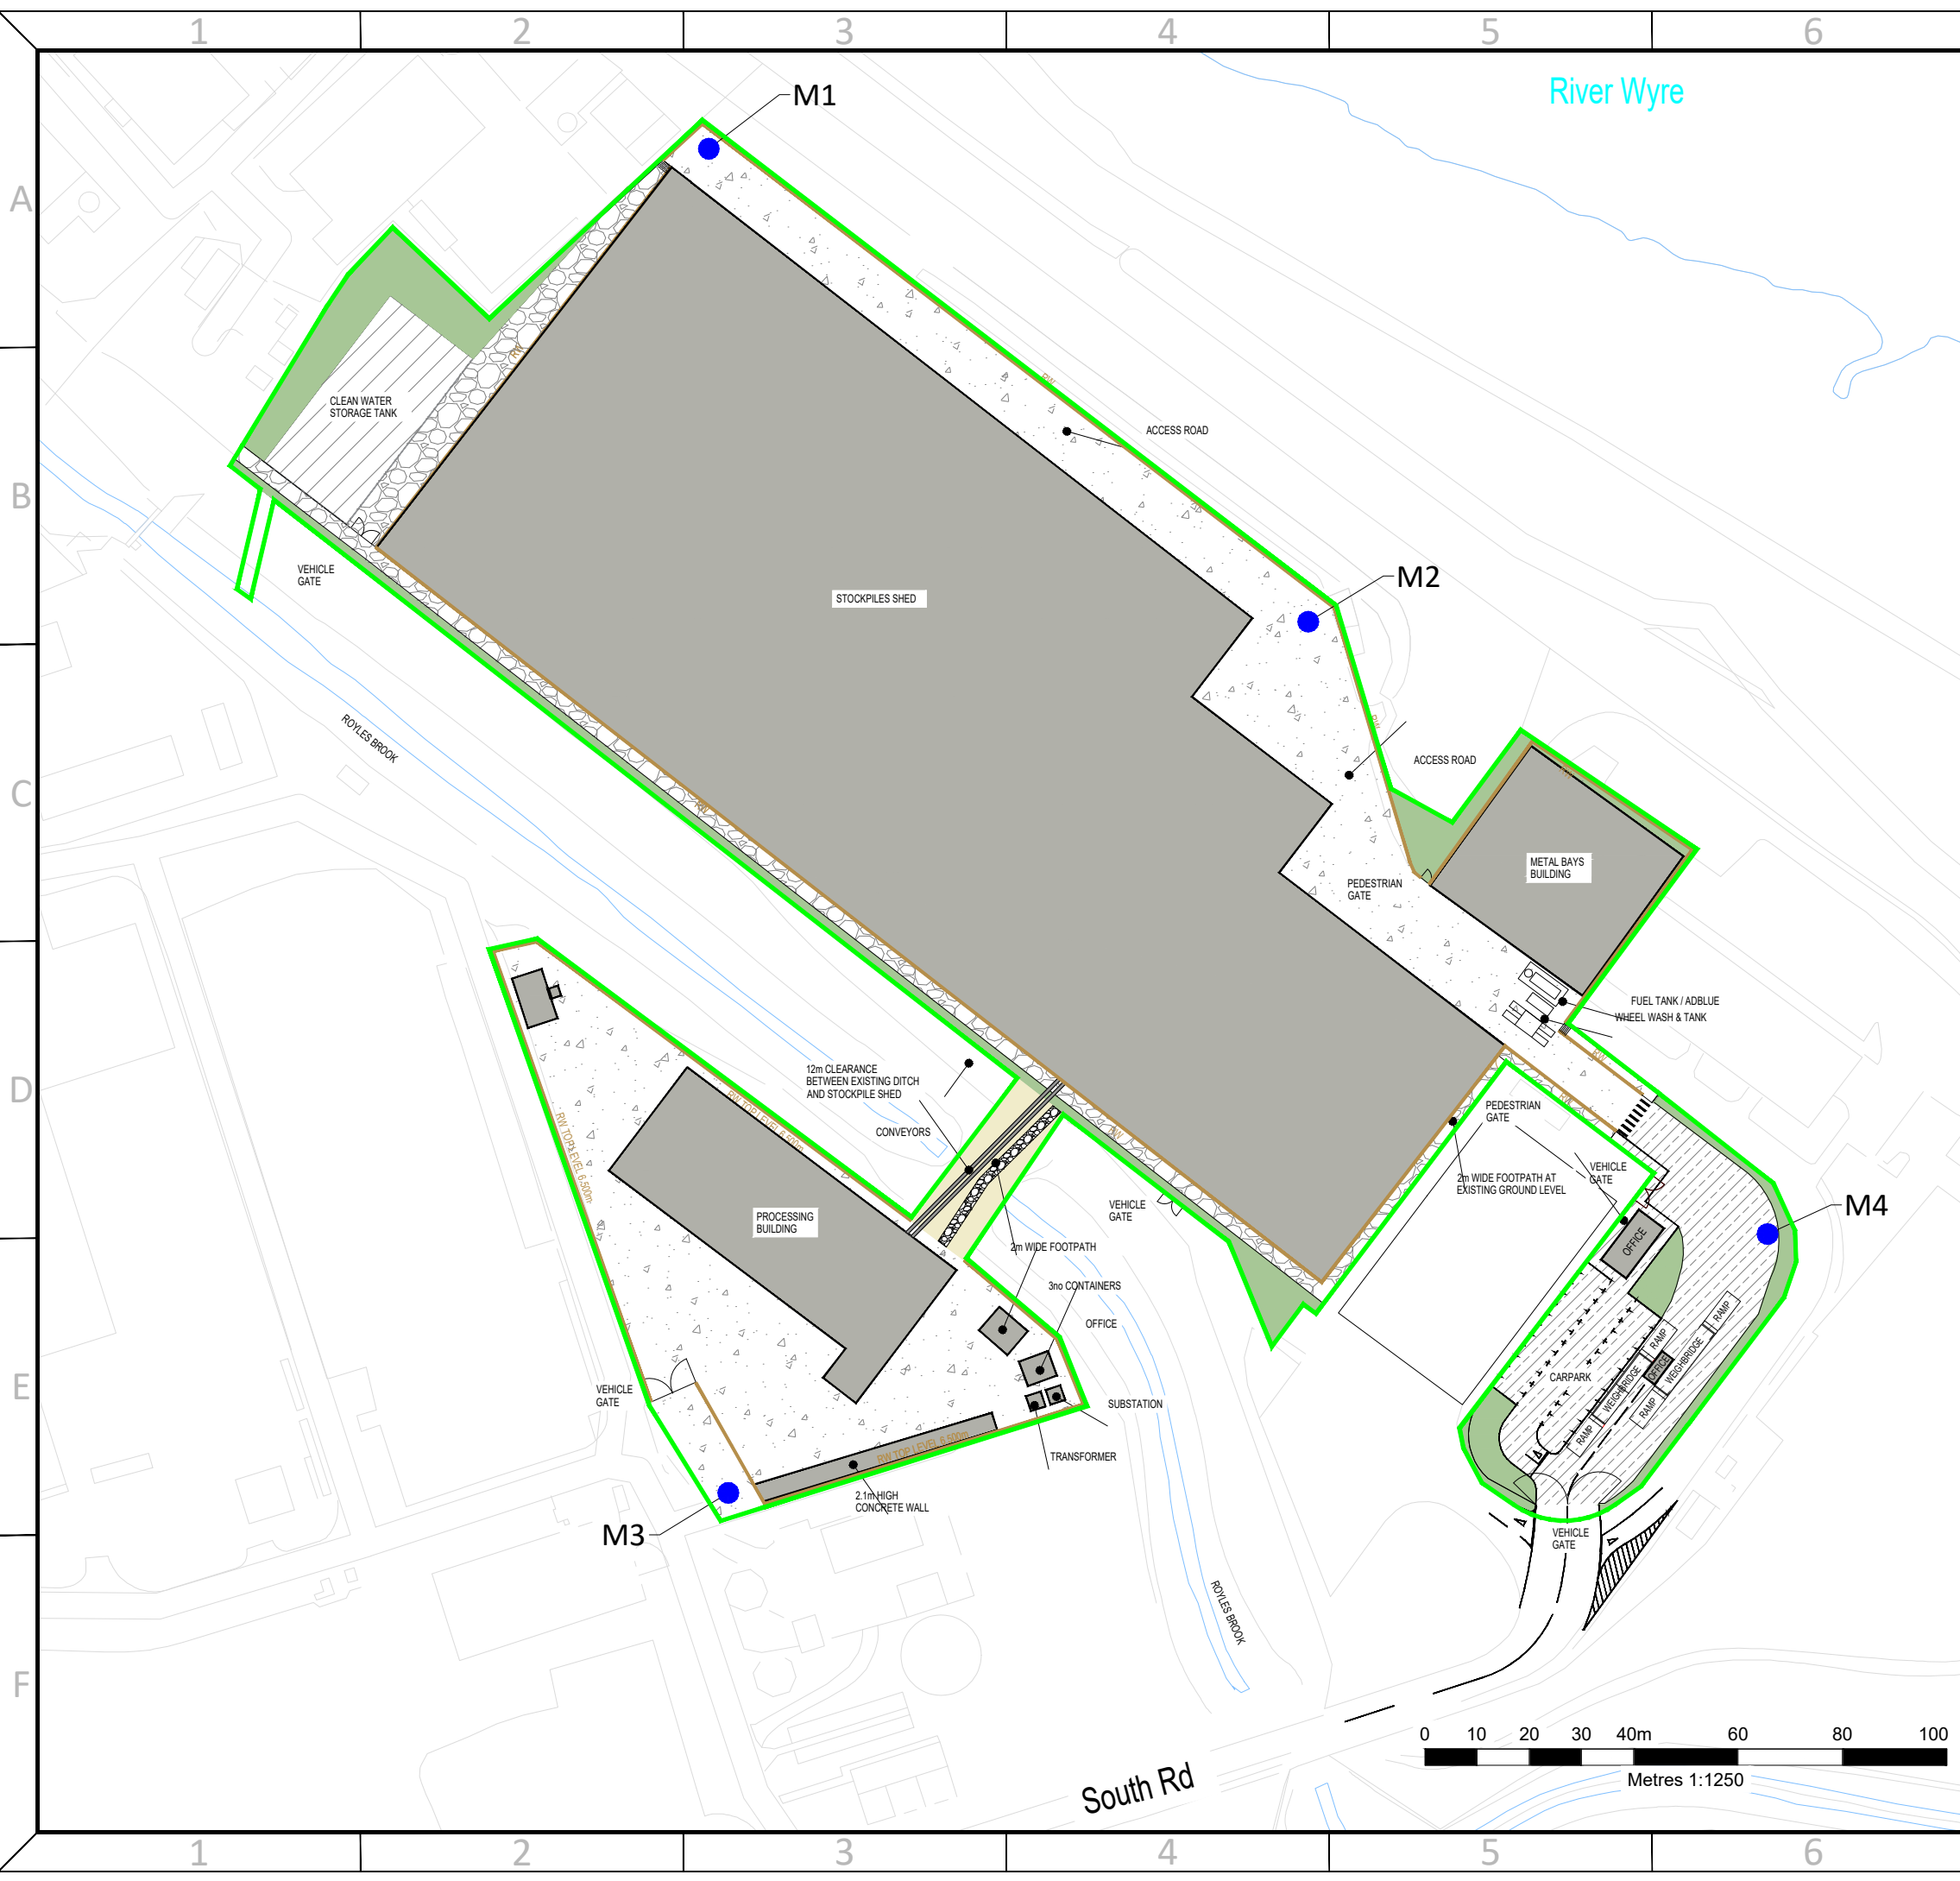

ALL INFORMATION ON THIS DRAWING IS INDICATIVE ONLY, AND MAY BE SUBJECT TO FURTHER DESIGN DEVELOPMENT.

DO NOT SCALE

- NOTES:
- INSTALLATION BOUNDARY
 - VISUAL MONITORING LOCATIONS

R2.0	INSTALLATION BOUNDARY EDIT	EMC	DTW	SMN	27.08.24
R1.0	PRELIMINARY	EMC	DTW	ACM	25.07.24
REV.	DETAILS OF REVISION	DRAWN	CHKD	APR	DATE

FICHTNER
CONSULTING ENGINEERS LIMITED

Kingsgate, Wellington Road North,
Stockport, Cheshire, SK4 1LW, UK
Tel: 0161 476 0032
Website: www.fichtner.co.uk

CLIENT:	FORTIS IBA LIMITED				
SITE:	HILLHOUSE				
PROJECT:	HILLHOUSE IBA				
TITLE:	DUST MONITORING LOCATIONS				

DRAWING STATUS:	PRELIMINARY				
DRAWN BY:	EMC	DATE:	25.07.24		
CHECKED BY:	DTW	DATE:	25.07.24		
APPROVED BY:	ACM	DATE:	25.07.24		
FILENAME:	4148-8310-0005EMC DUST MONITORING R2.0				
OFFICE OF ISSUE:	STOCKPORT				
SHEET SIZE:	A3	SCALE:	1:1250		

DRAWING No.: **4148-8310-0005** Sheet 1 Of 1 REVISION: **R2.0**

Figure 1: Process flow diagram

