


### Legend

- Green Line Boundary
- A1,1 Installation Points
- Proposed Digester Bund
- ← Storm Drainage
- ← Foul Drainage

Emissions Ref	Emissions Points	Assets Ref	Assets	x	y
A1	CHP 1	1	CHP 1	352070	238844
A2	CHP 2	2	CHP 2	352070	238844
A3	Boiler 1	3	Boiler 1	352060	238856
A4	Boiler 2	4	Boiler 2	352070	238844
A5	Gas Flare Stacks	5	Gas Flare Stacks	352112	238847
A6	Gas Flare Stacks	6	Gas Flare Stacks	352114	238845
A7	Generator 1	7	Generator 1	352085	238867
A8	Generator 2	8	Generator 2	352079	238873
A9	OCU	9	OCU	352088	238809
A10	Digester 1 Wessoe Valve	10	Digester 1	352110	238800
A11	Digester 2 Wessoe Valve	11	Digester 2	352098	238791
A12	Gas Bag Wessoe Valve	12	Gas Bag	352101	238821
		13	Cake Silo	352035	238901
		14	Centrifuges	352035	238891
		15	Strainpresses	352092	238850
		16	Sludge Thickening	352064	238851
		17	Thickened Sludge Tank	352088	238856
		18	Screened Sludge Tank 1	352098	238842
		19	Screened Sludge Tank 2	352085	238833
		20	Centrifuge Feed Tank	352123	238785
		21	SBR Balance Tank	352109	238776
		22	SBR Basin 1	352136	238769
		23	SBR Basin 2	352123	238759
W1	Centrifuge Centrate	24	Centrate discharge point	352022	238877
W2	Thickener Liquors	25	Sludge thickener Liquor Discharge	352079	238853
W3	Storm runoff	26	Site drainage discharge point	352041	238858
W4	SBR treated effluent	27	SBR discharge Point	352115	238755
W5	Digester bund storm runoff	28	Digester bund discharge point	352143	238726
W6	Foul drainage emission point	29	STW inlet pump station	351999	238822
W7	Storm returns emission point	29	STW inlet pump station	351999	238822
		30	Digester Bund return pump station	352127	238801

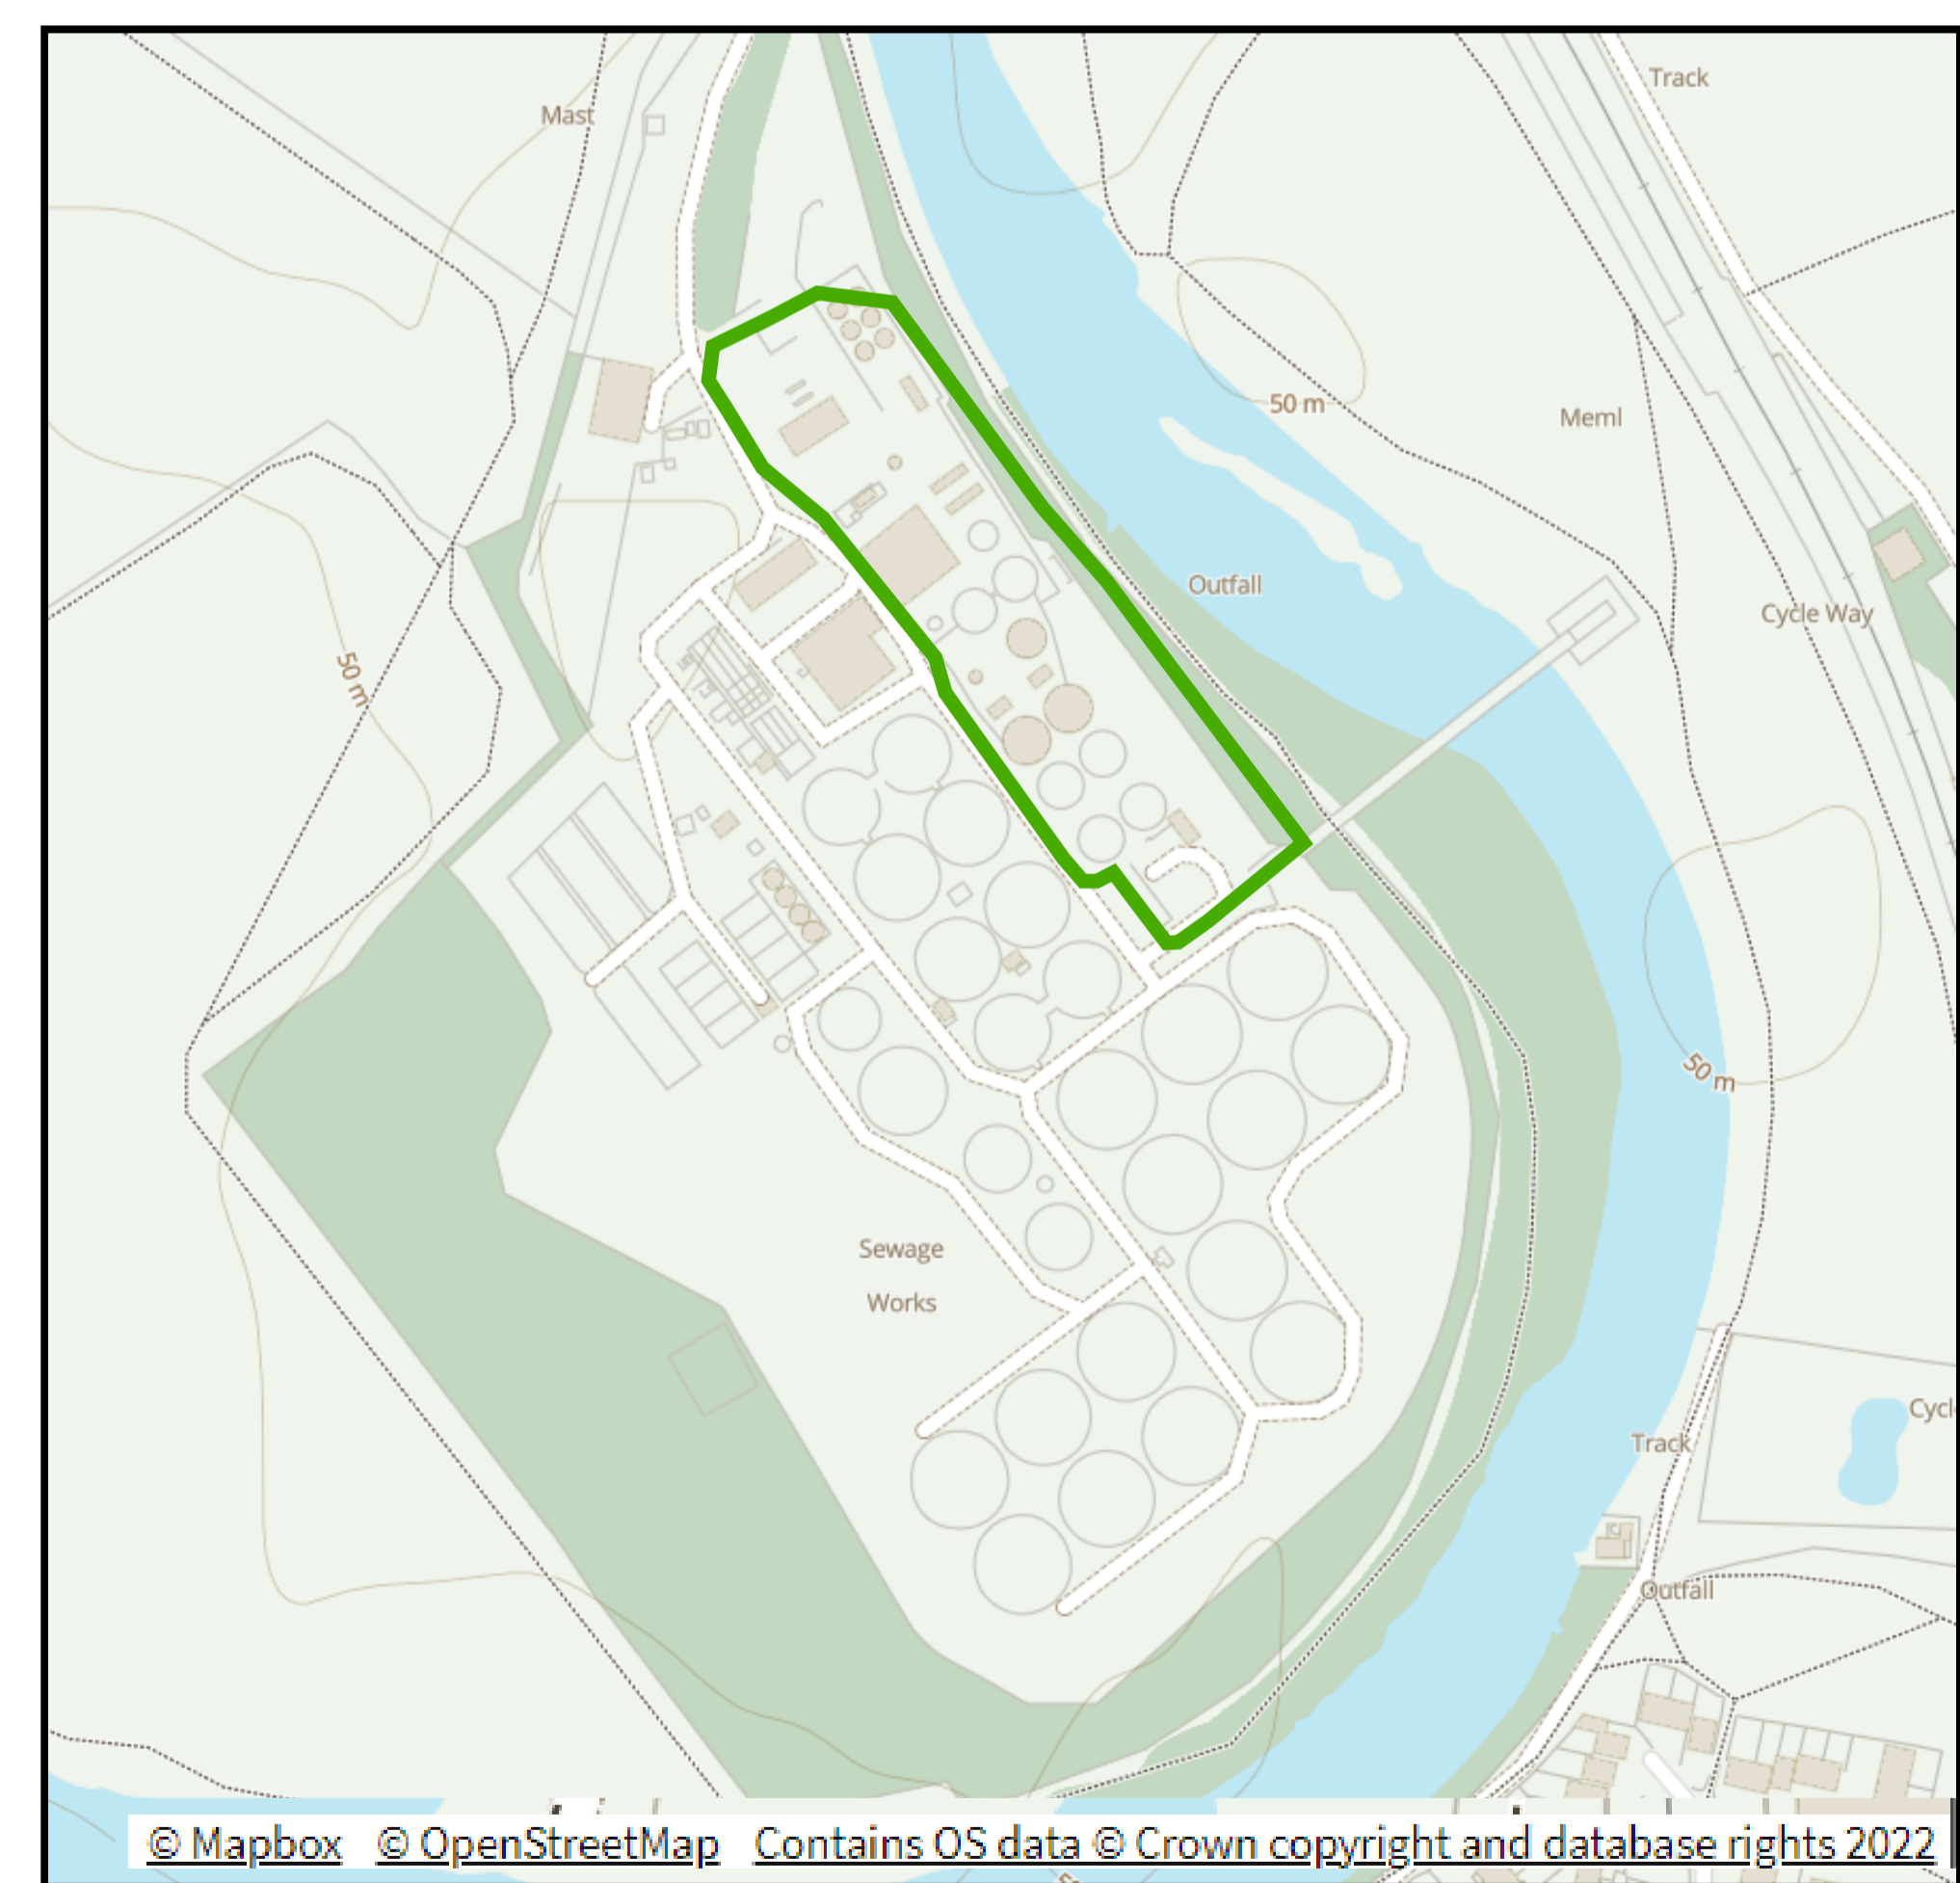

© Mapbox © OpenStreetMap Contains OS data © Crown copyright and database rights 2022

P1	24.11.22	RC	FIRST ISSUE	AM	24.11.22
Rev.	Date	Drawn	Description	Chkd	Appd
 <b>Cynghair Cyflawni Cyfalaf</b> Ty Awon, Spooner Close, Coad Kernew, Newport, NP108FZ					
Project Name: EIGN IED					
Drawing Title: SITE LAYOUT, EMISSIONS AND DRAINAGE PLAN					
Suitability: FOR INFORMATION					Suitability Code: S2
Originator:	Designer:	Date:			
Internal Project Number: 287298	Scale:	Rev:			
Drawing Number: B16564-0AG964-ZZ-XX-DR-ZA-DH0010					