


Bournes Farm

Stage

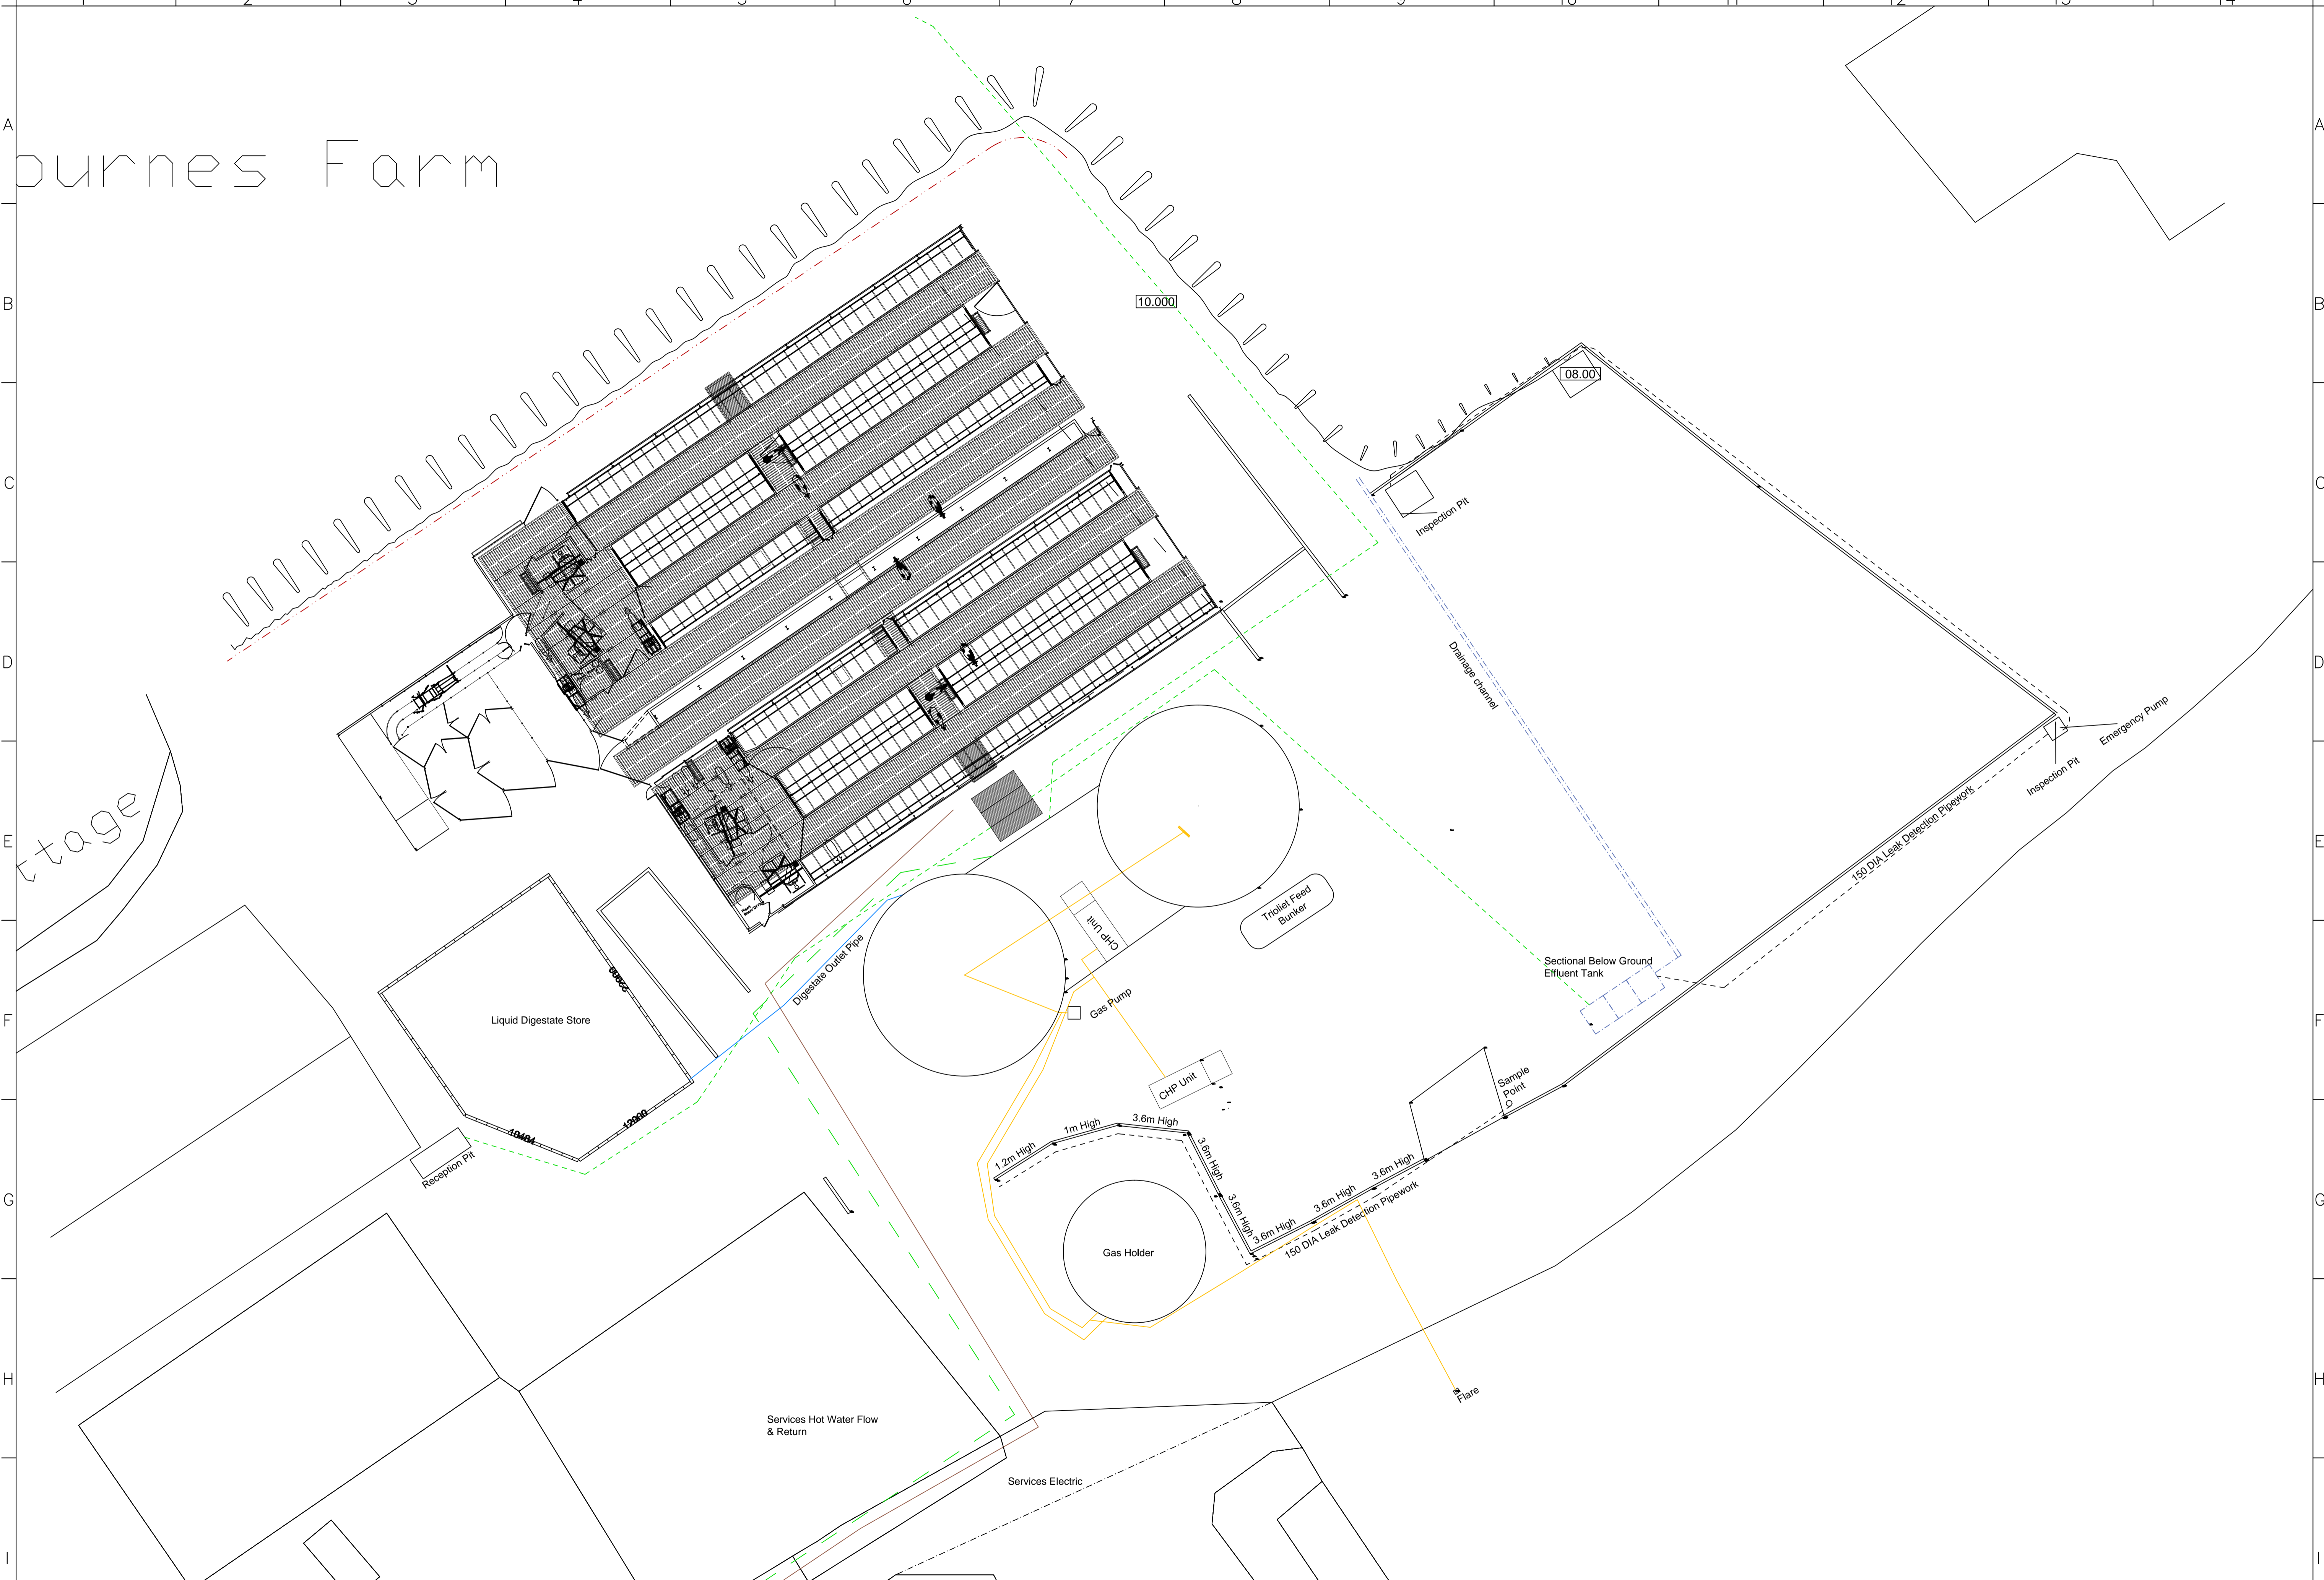

PAPER SIZE A1	Surface Water 150mm	Electricity Supply	1 100mm Ducts
	Roof Water Catchment	Gas Supply	2 100mm Ducts
	Dairy & Robot Washings	Mains Water 63mm	3 100mm Ducts
	French Drain	Mains Water 32mm	4 100mm Ducts
	Roofwater Alternative	Leak Detection	Surface Water Slotted Drain 225mm
	Foul Sewer 150mm	Telecom's	

B	Feedstock Area Moved In Line With Cubical Building	6.03.18W	LM
C	Hedge Specification updated as per Hereford Council	07.04.18	AW

THIS DRAWING IS COPYRIGHT. IT MUST NOT BE COPIED, USED OR DISCLOSED TO THIRD PARTIES WITHOUT PRIOR PERMISSION.
 ALL DIMENSIONS TO BE CHECKED ON SITE PRIOR TO COMMENCEMENT.
 ANY DISCREPANCIES TO BE BROUGHT TO THE ATTENTION OF CLIENTS ABSENT IMMEDIATELY.
 ALL DRAWINGS TO BE READ IN STRICT CONJUNCTION WITH THE RELEVANT ENGINEERING DRAWINGS WHERE APPLICABLE. FULL APPROVAL OF ANY WORK AS STATED OR UNDERTAKEN TO BE OBTAINED BY EITHER EA OR LOCAL AUTHORITY BUILDING INSPECTOR.
DO NOT SCALE - IF IN DOUBT - ASK

ATSS
 COLLINGSBOURNE DUGES
 MARLBOROUGH
 WILTS, SN8 3EQ
 TEL 01264 850446 - EMAIL INFO@ATSSLTD.COM

TITLE Site Plan With Services	DRN BY LM	DATE 8.2.18	CHK BY JD	SCALE 1:250
NUMBER - REV - CLIENT - PROJECT 01180-00 - F - Nigel Green - Much Fawley Farm	SHEET 2			