



DIRTY/STORM WATER ISOLATION VALVE ARRANGEMENT

SCALE - 1:20

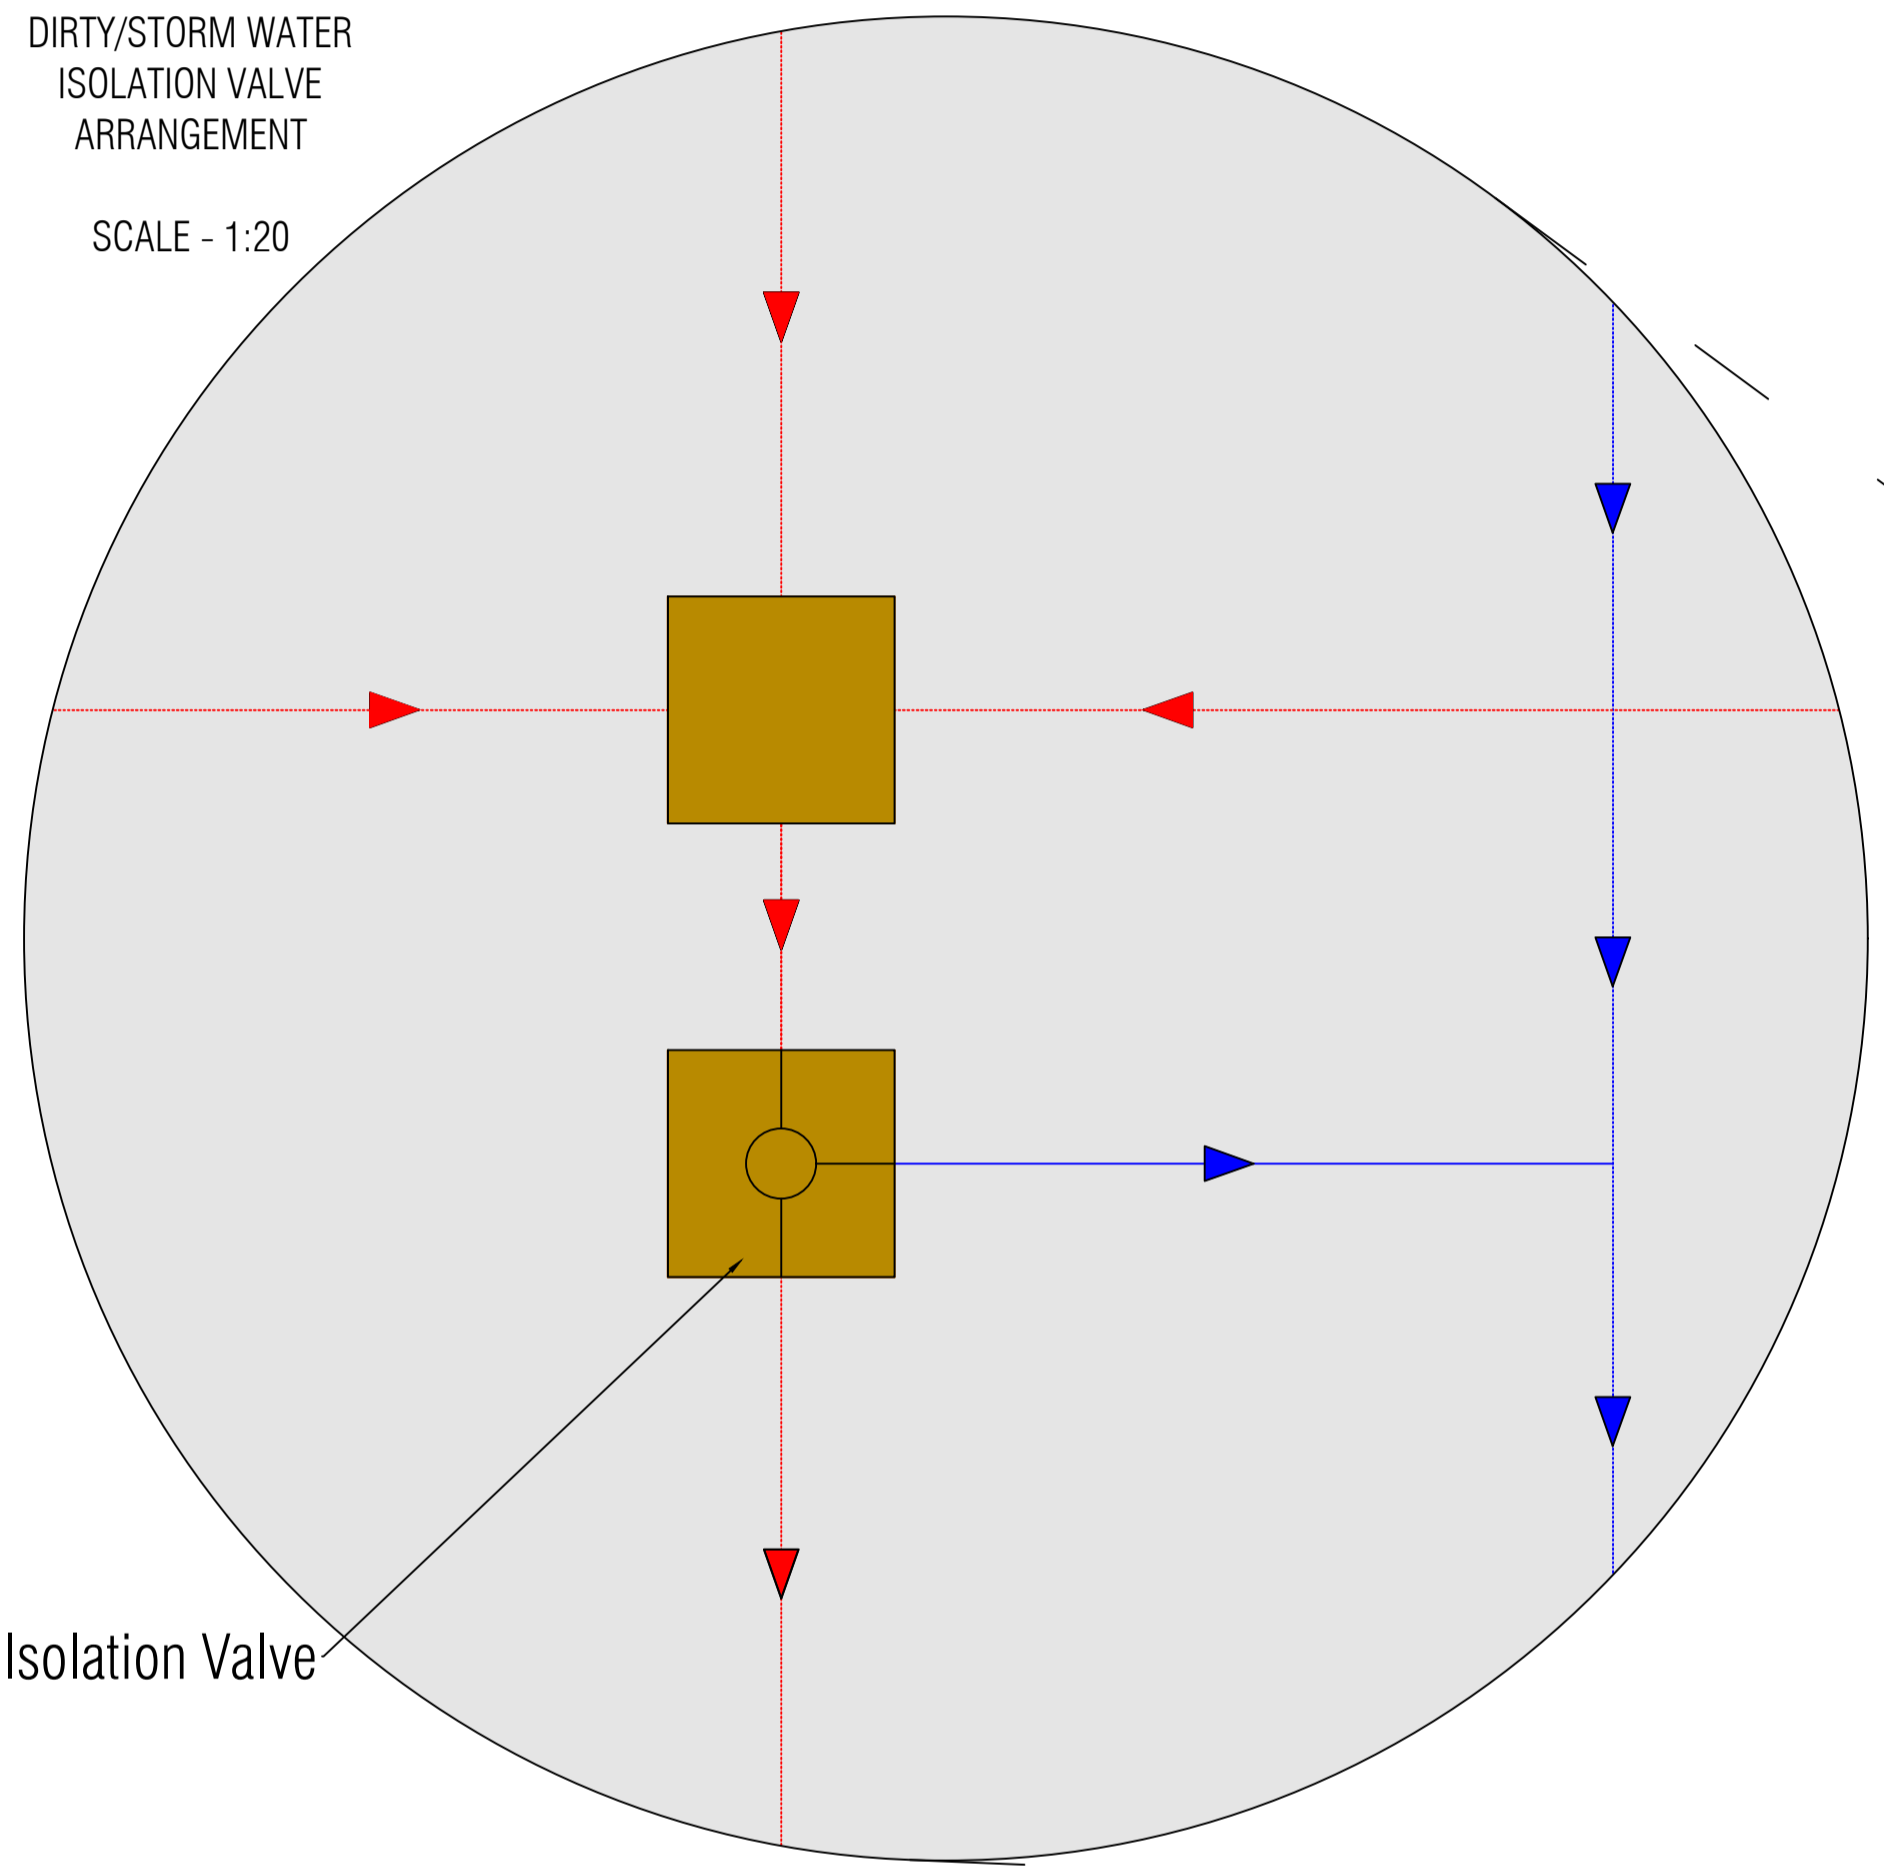

Isolation Valve

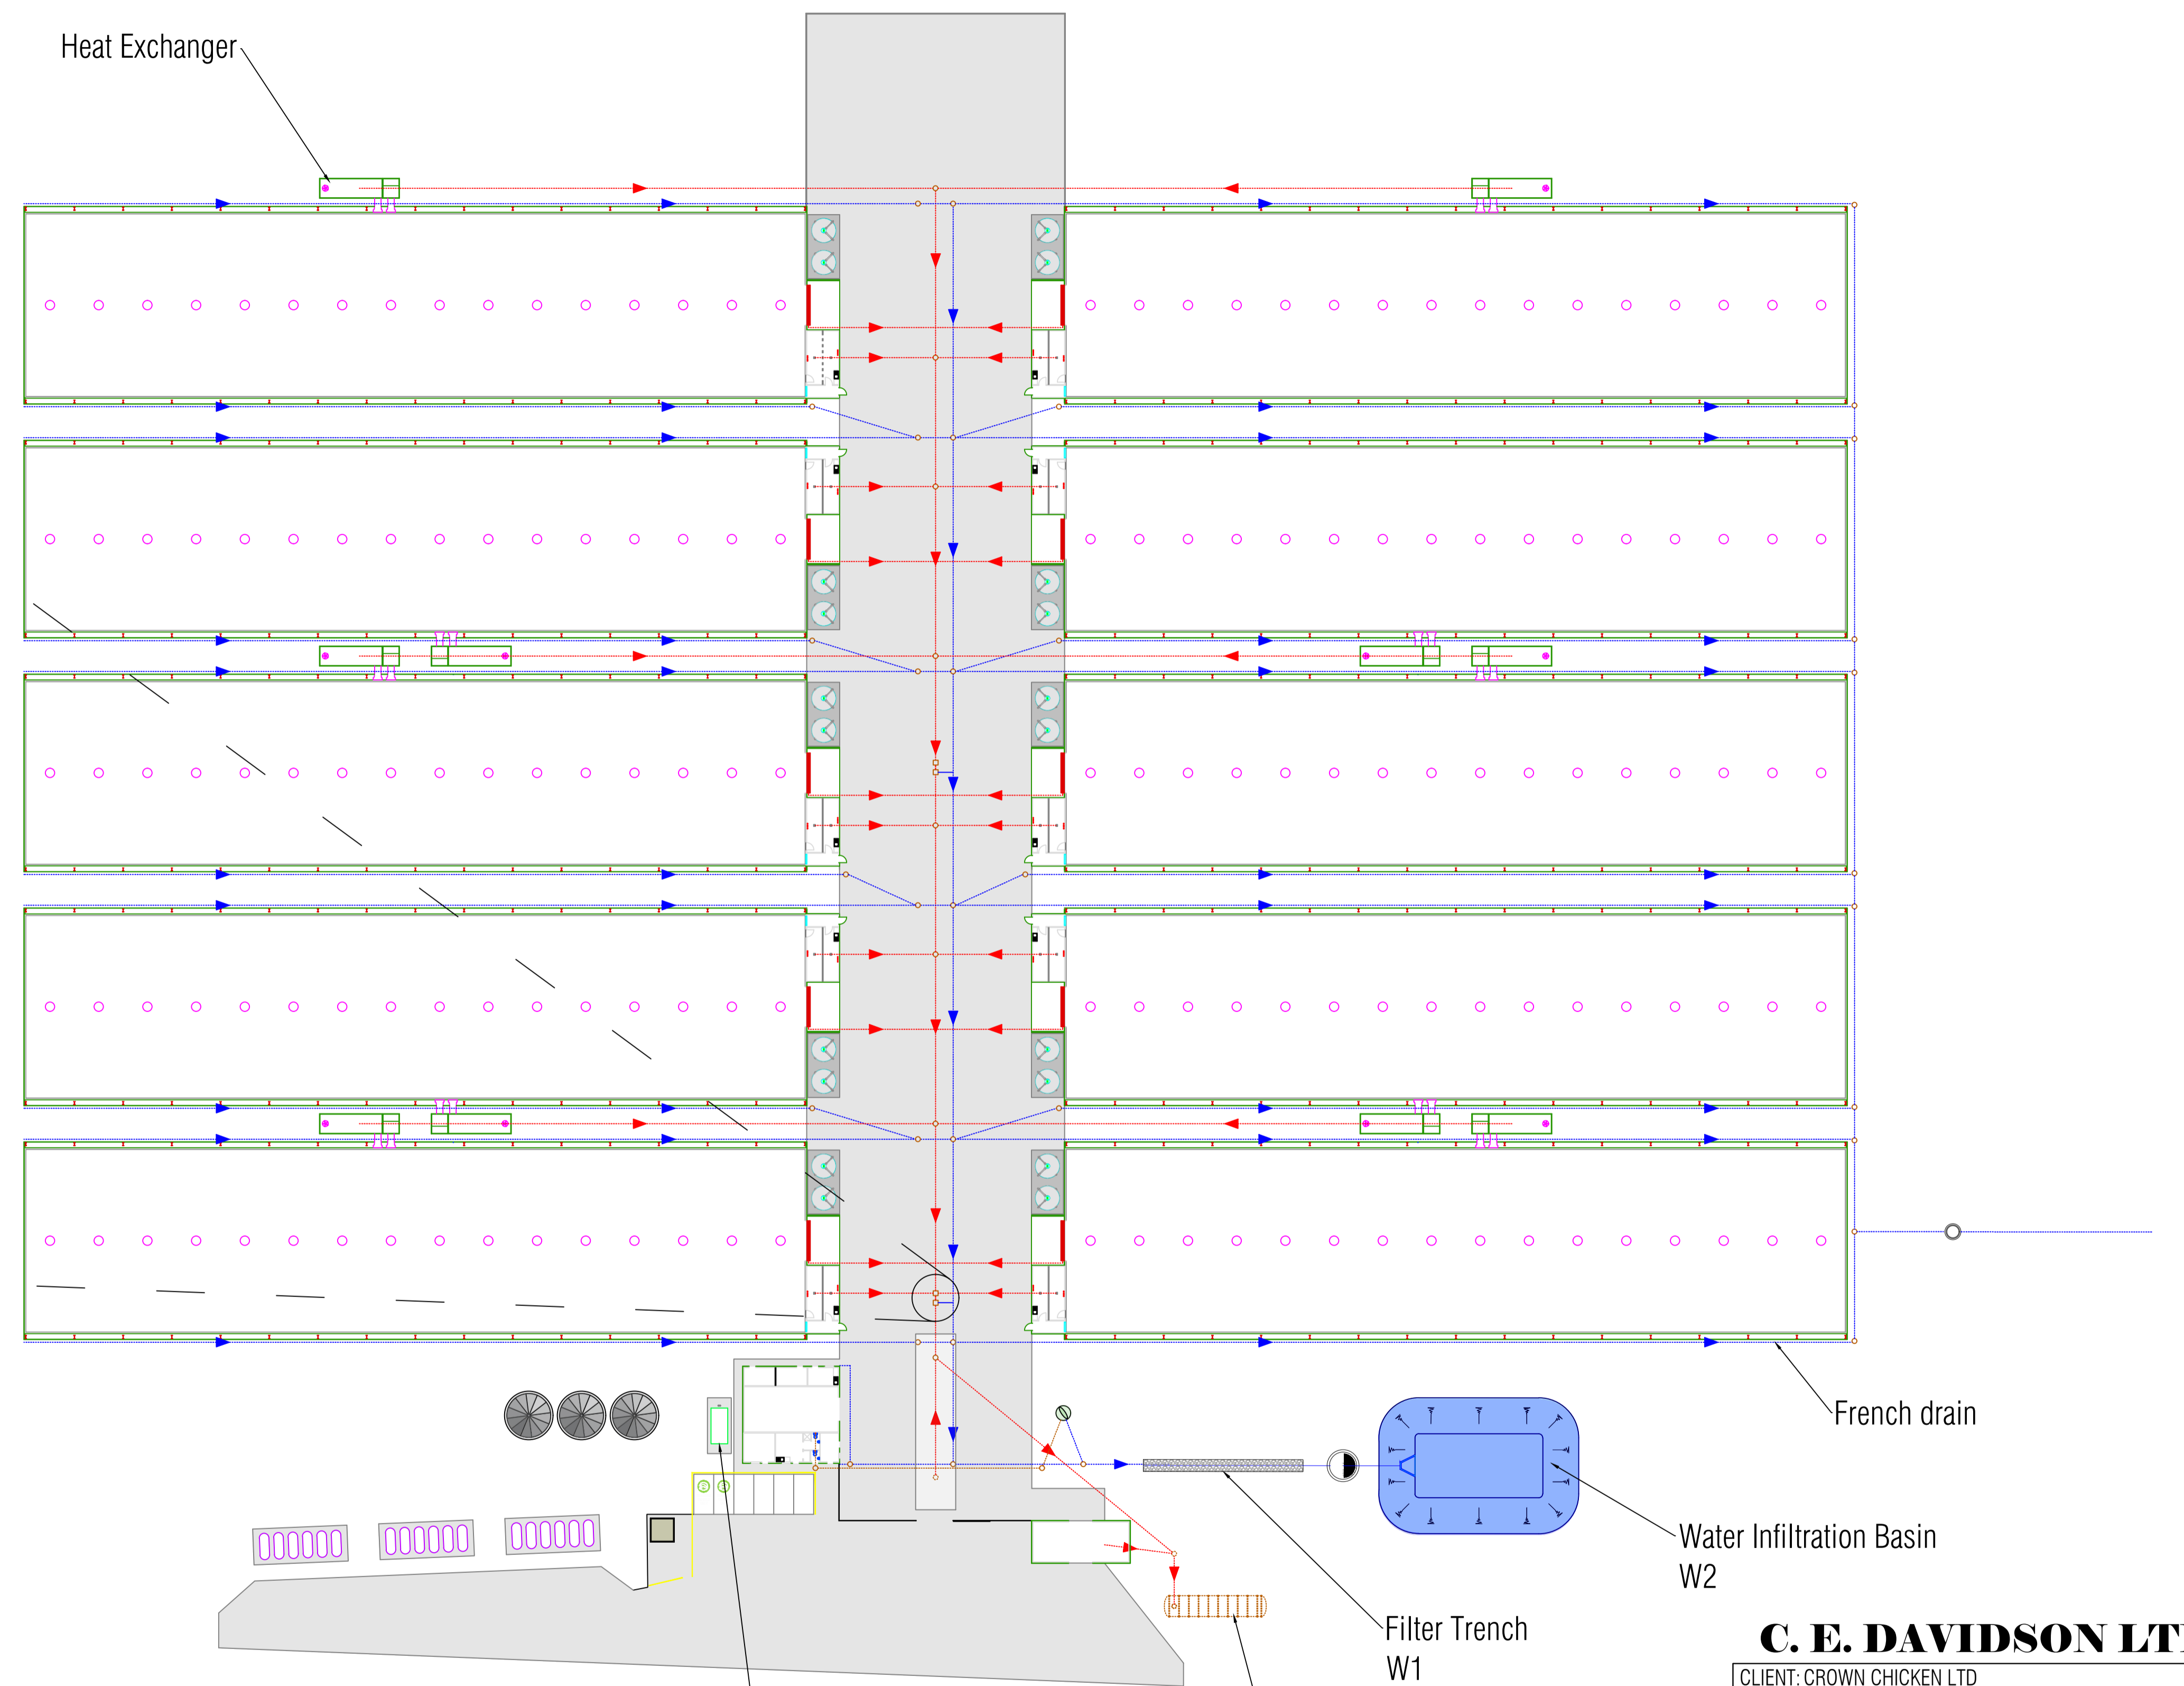

French drain






Water Infiltration Basin W2

Filter Trench W1

Generator & Diesel Tank

60,000 litre underground, concrete encased, dirty water tank

KEY:

-  Dirty
-  Storm
-  Foul
-  Catch Pit
-  Manhole

C. E. DAVIDSON LTD

CLIENT: CROWN CHICKEN LTD			
DATE: JANUARY 2023			
SUBJECT: BRECKLAND FARM, BRANDON ROAD, METHWOLD, IP26 4RJ - POULTRY FARM REDEVELOPMENT			
DRAWING NO: BRECK-DRAIN-N			
SCALE: 1:500, 1:20 AT A1			
APPROVED BY:		PGD	DRAWN BY: CPD
REV	DATE	DESCRIPTION	
1	31-08-2023	NORTH SITE DRAINAGE LAYOUT	