

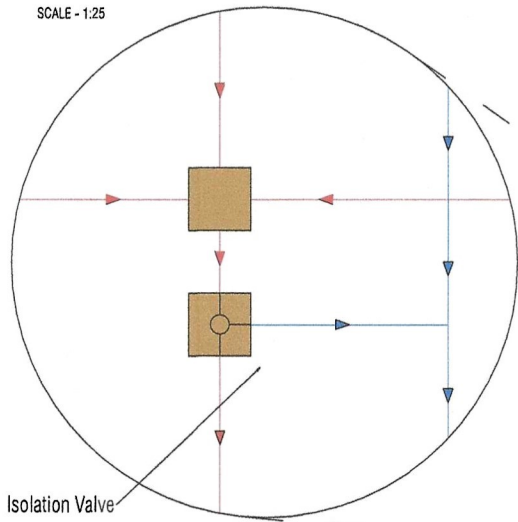


DIRTY/STORM WATER ISOLATION VALVE ARRANGEMENT


SCALE - 1:25

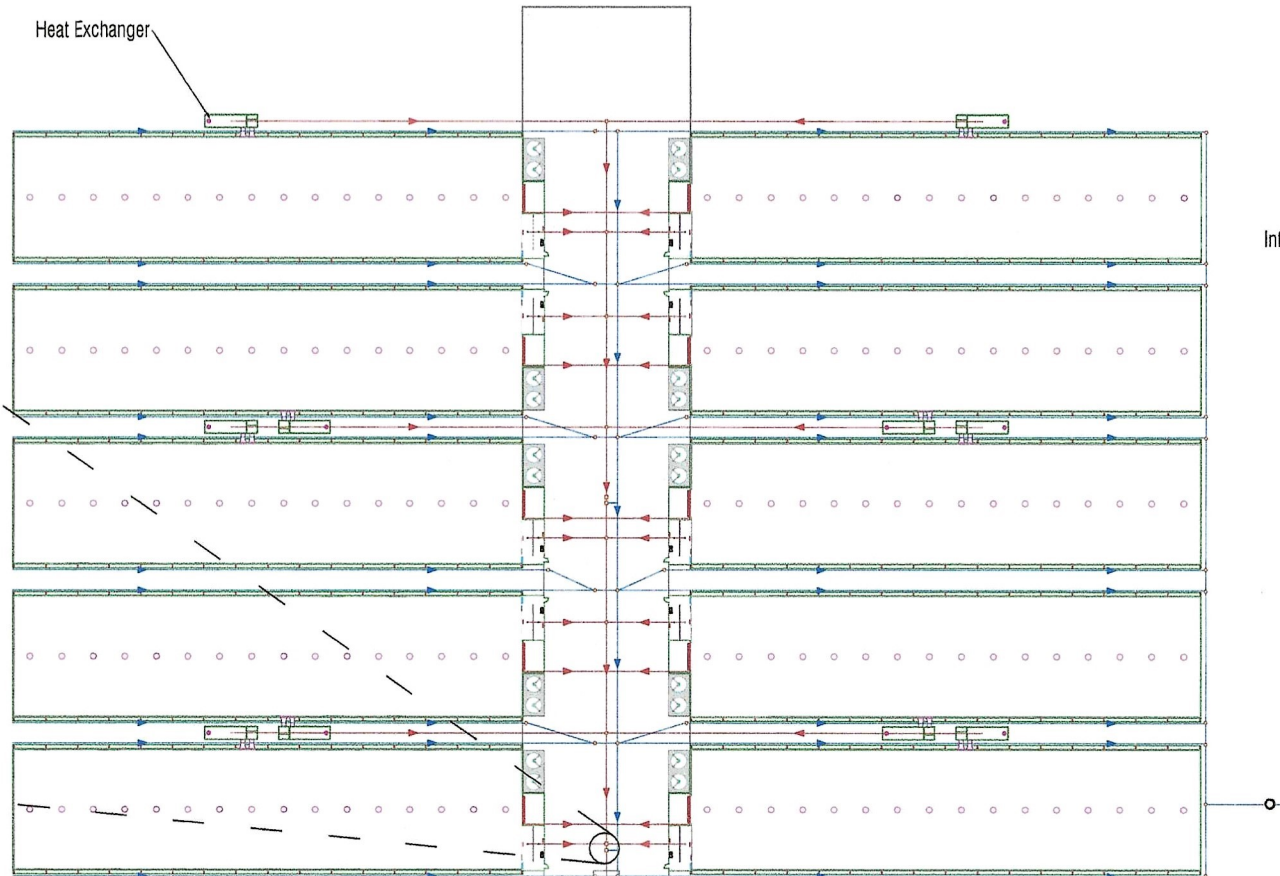

Isolation Valve

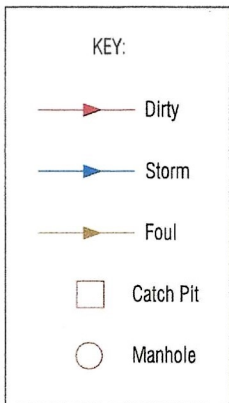

Infiltration Basin W3

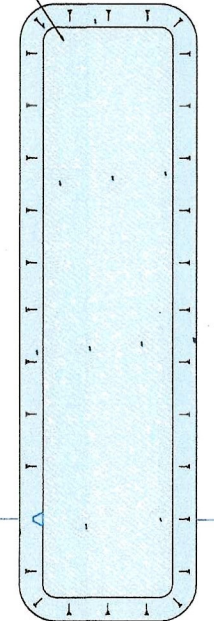

wheel wash area

chemical store

60,000 litre underground, concrete encased, dirty water tank

Filter Trench W1

Water Infiltration Basin W2


C. E. DAVIDSON LTD

CLIENT: CROWN CHICKEN LTD			
DATE: JANUARY 2023			
SUBJECT: BRECKLAND FARM, BRANDON ROAD, METHWOLD, IP26 4RJ - POULTRY FARM REDEVELOPMENT			
DRAWING NO: BRECK-DRAIN-N			
SCALE: 1:500, 1:25 AT A1			
APPROVED BY:		PGD	DRAWN BY: CPD
REV	DATE	DESCRIPTION	
1	31-08-2023	NORTH SITE DRAINAGE LAYOUT	
2	07-11-2023	NORTH SITE DRAINAGE LAYOUT	


Heat Exchanger

DIRTY/STORM WATER ISOLATION VALVE ARRANGEMENT


SCALE - 1:25

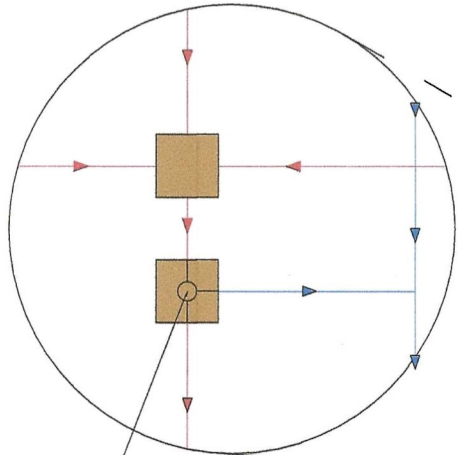

Isolation Valve

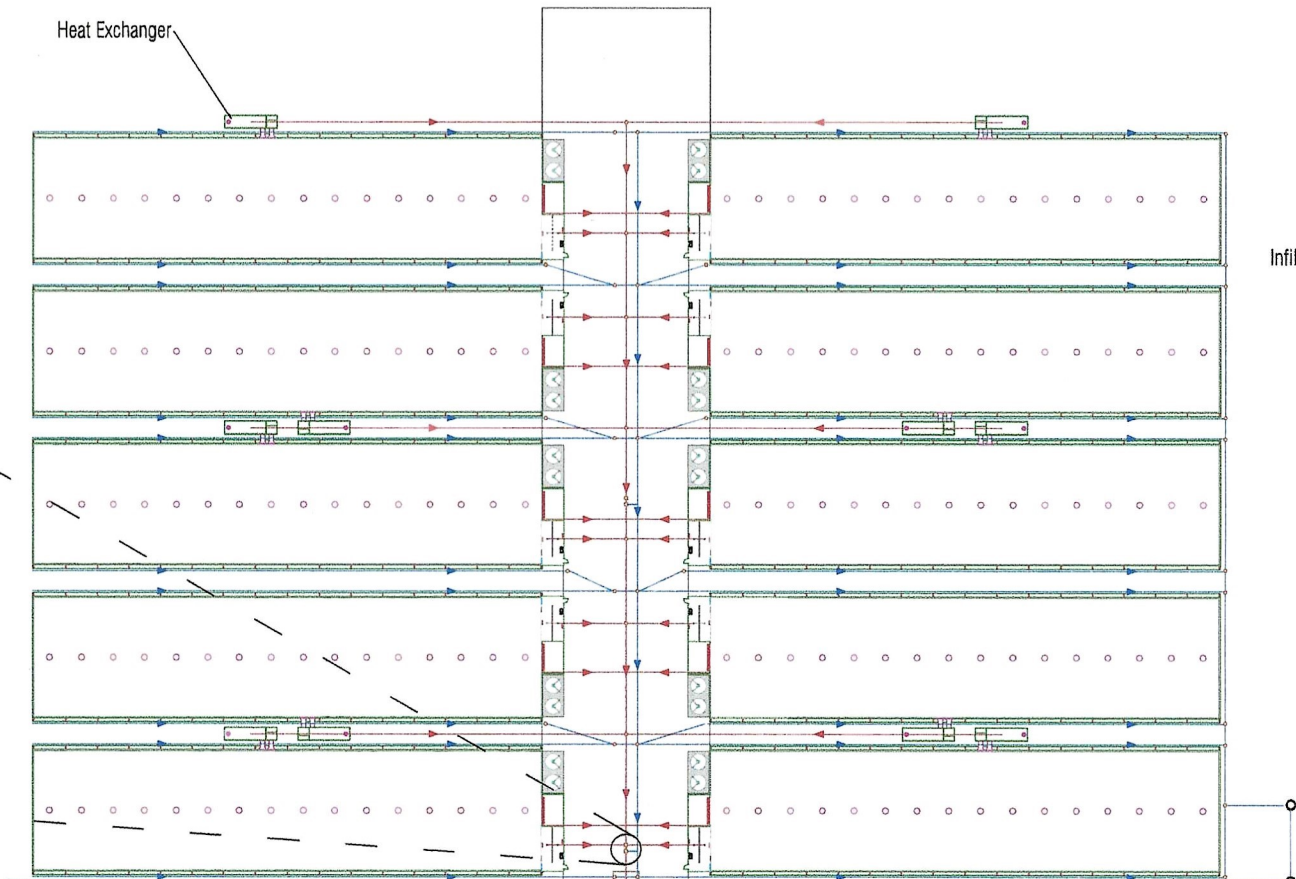

Infiltration Basin W6

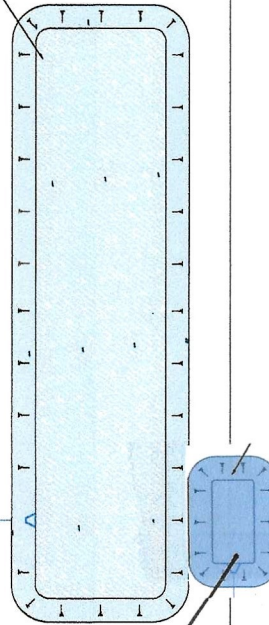


Infiltration basin W7

KEY:

	Dirty
	Storm
	Foul
	Catch Pit
	Manhole

wheel wash area

Chemical store
Generator & Diesel Tank

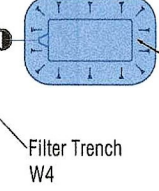

60,000 litre underground, concrete encased, dirty water tank

Water Infiltration Basin W5

C. E. DAVIDSON LTD

CLIENT: CROWN CHICKEN LTD
 DATE: JANUARY 2023
 SUBJECT: BRECKLAND FARM, BRANDON ROAD, METHWOLD, IP26 4RJ - POULTRY FARM REDEVELOPMENT
 DRAWING NO: BRECK-DRAIN-S
 SCALE: 1:500, 1:25 AT A1

APPROVED BY:	PGD	DRAWN BY:	CPD
REV	DATE	DESCRIPTION	
1	31-08-2023	SOUTH SITE DRAINAGE LAYOUT	
2	07-11-2023	SOUTH SITE DRAINAGE LAYOUT	