


NOTES

This drawing is the sole copyright of the University of Liverpool and may not be reproduced in any form without prior written consent.

The University of Liverpool are not responsible for the accuracy of information received from others.  
Do not scale from this drawing.  
All dimensions are shown in millimeters and are approximate and subject to review.  
All dimensions and levels must be checked by the contractor(s) on site and any discrepancies must be reported in writing to the Project Manager prior to the commencement of any work on site and prior to commencement of the Works on site and any ordering of materials.

All drawings/designs are subject to Building Control & Fire Officers Approval.  
All Works to comply with current Building Regulations, Fire Officer requirements and the particular guidance of any other statutory and advisory bodies.

RISKS TO HEALTH & SAFETY  
In addition to complying with statutory requirements, use products, methods of works and protective measures which will minimise health & safety hazards.

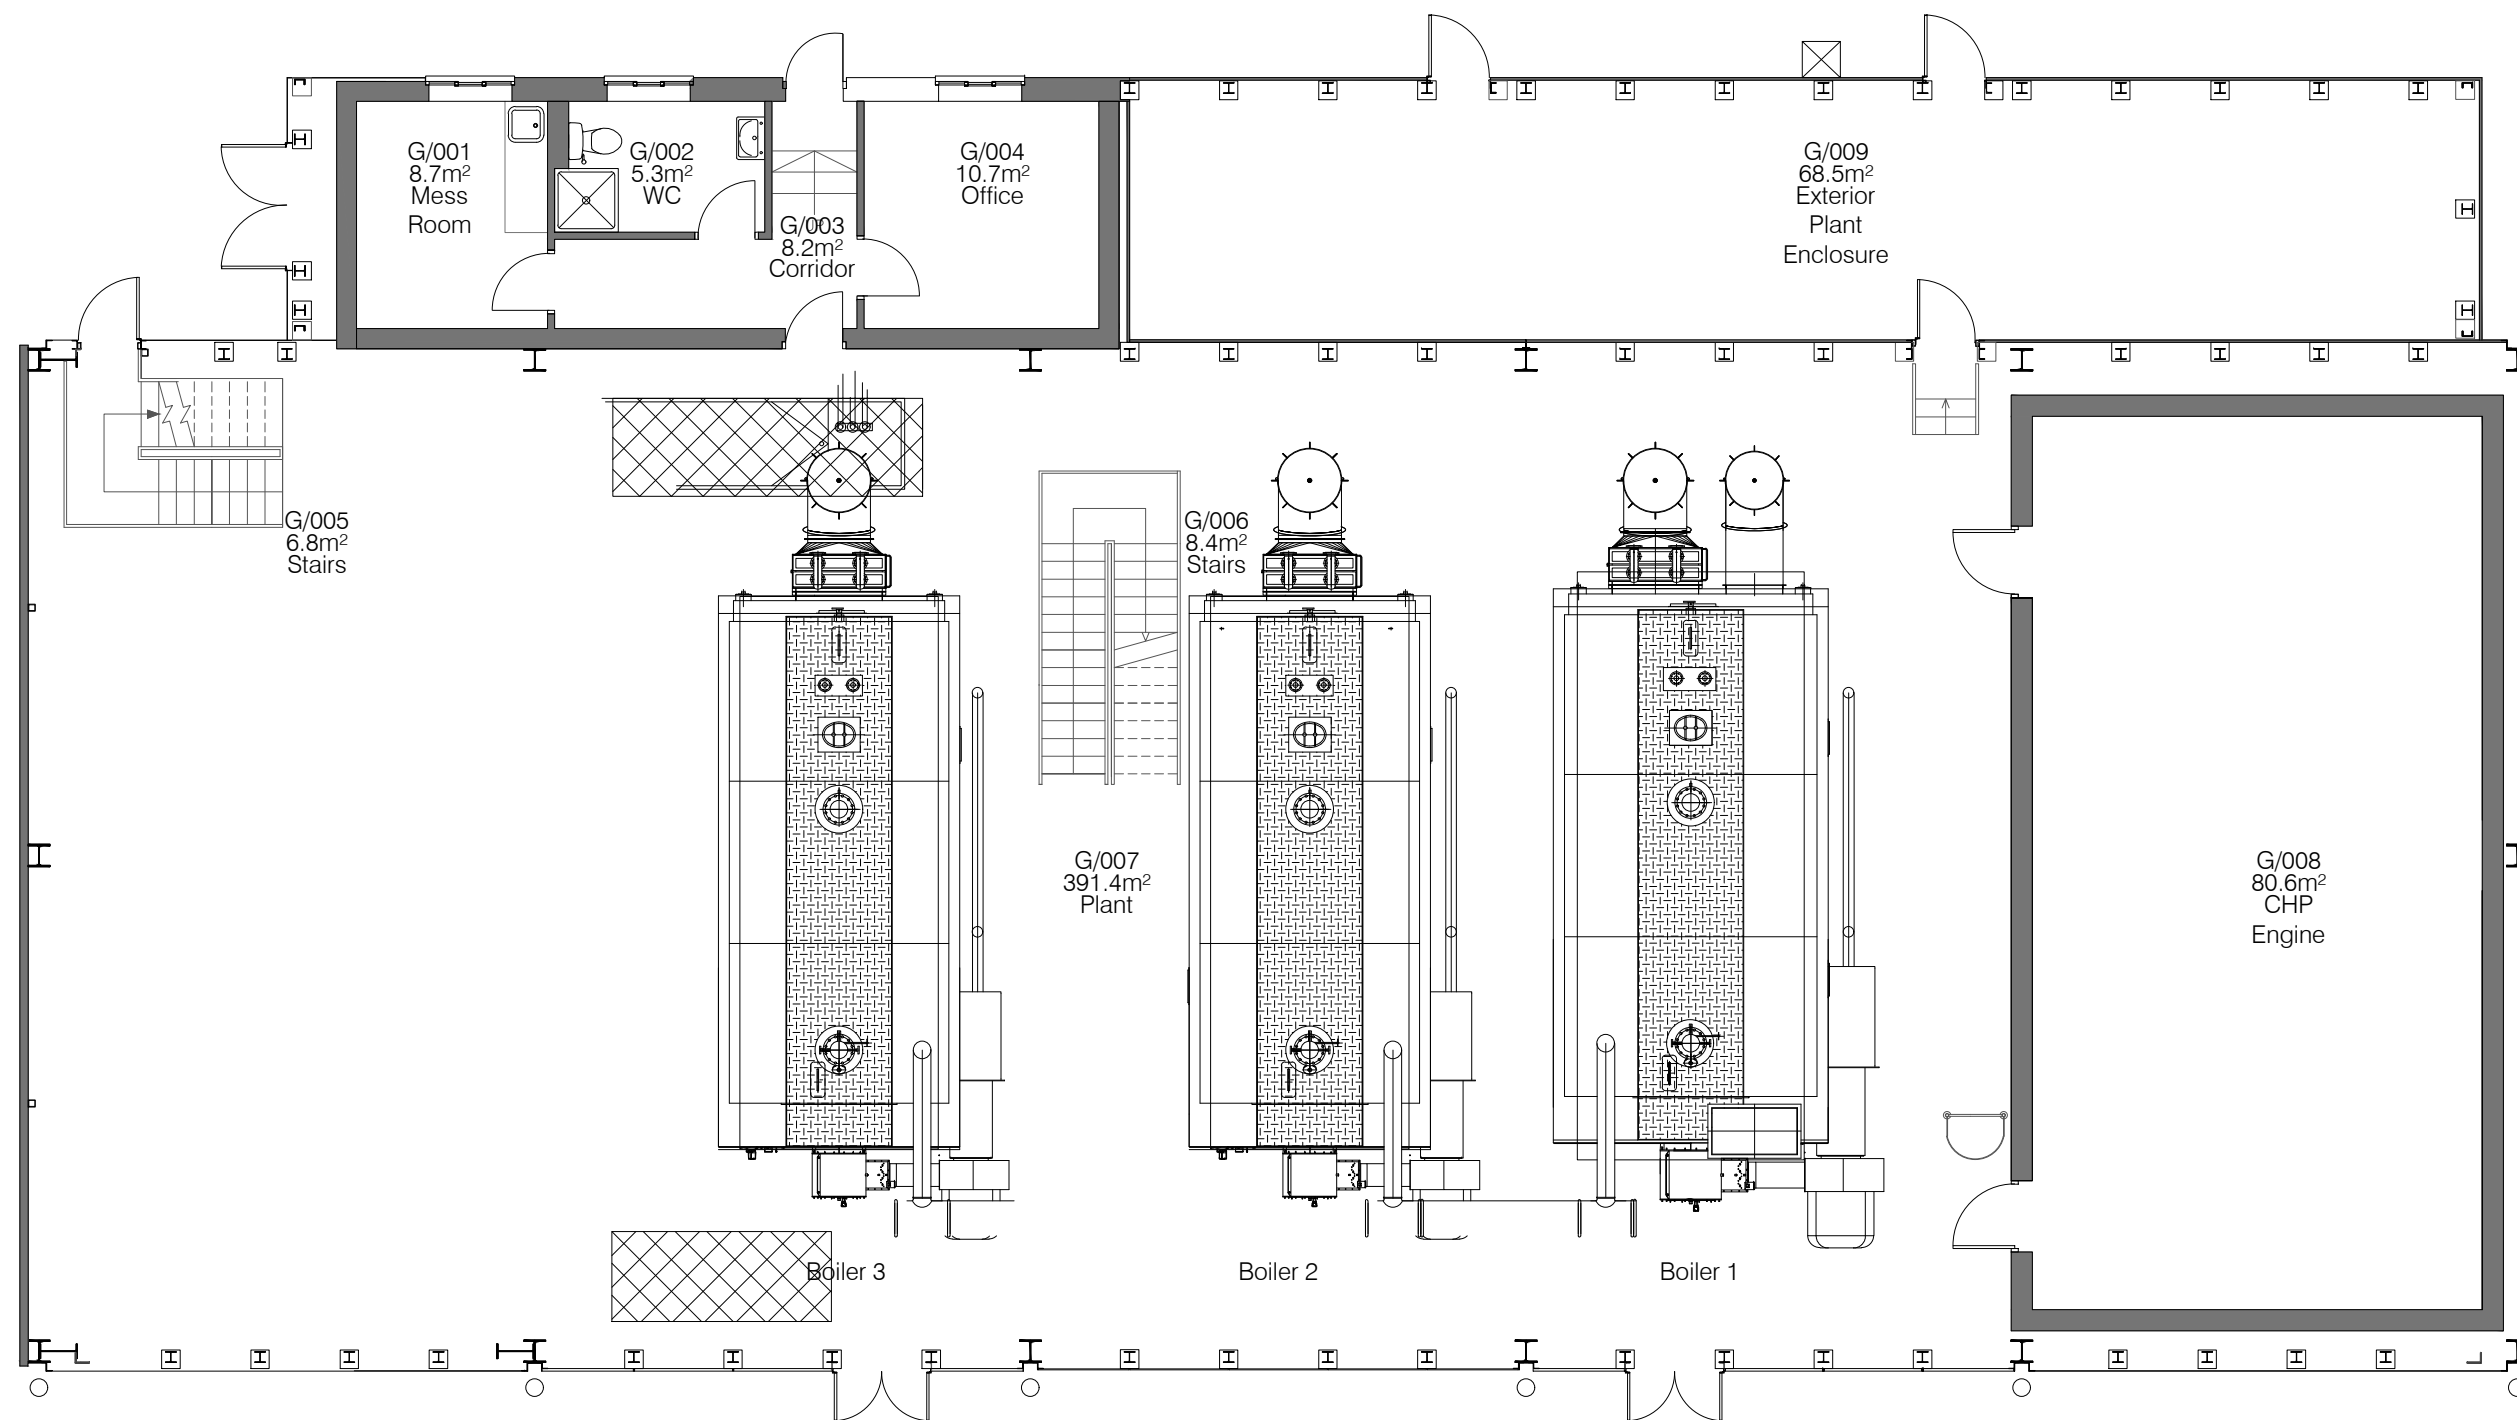

NOTE:



**FACILITIES, RESIDENTIAL AND COMMERCIAL SERVICES**

Bedford House, Oxford Street, Liverpool, L69 7ZP  
Tele: 0151 795 9065  
Email: fmsec1@liverpool.ac.uk

PROJECT: ENERGY CENTRE ASHTON STREET LIVERPOOL L69 3GF

BUILDING REF:  
**415**

DRAWING TITLE:  
GROUND FLOOR PLAN

DRAWING STATUS:  
**FOR INFORMATION**

DATE JAN 2019	SCALE NTS	PAPER SIZE A3	
PROJECT MANAGER	DRAWN BY	CHECK BY	APPROVED BY

PROJECT	ORIGINATOR	VOL	LEVEL	TYPE	ROLE	NUMBER	REV
MCN-415-0000-GA							

CAD REF:  
PROJECT MANAGER: [Name]