


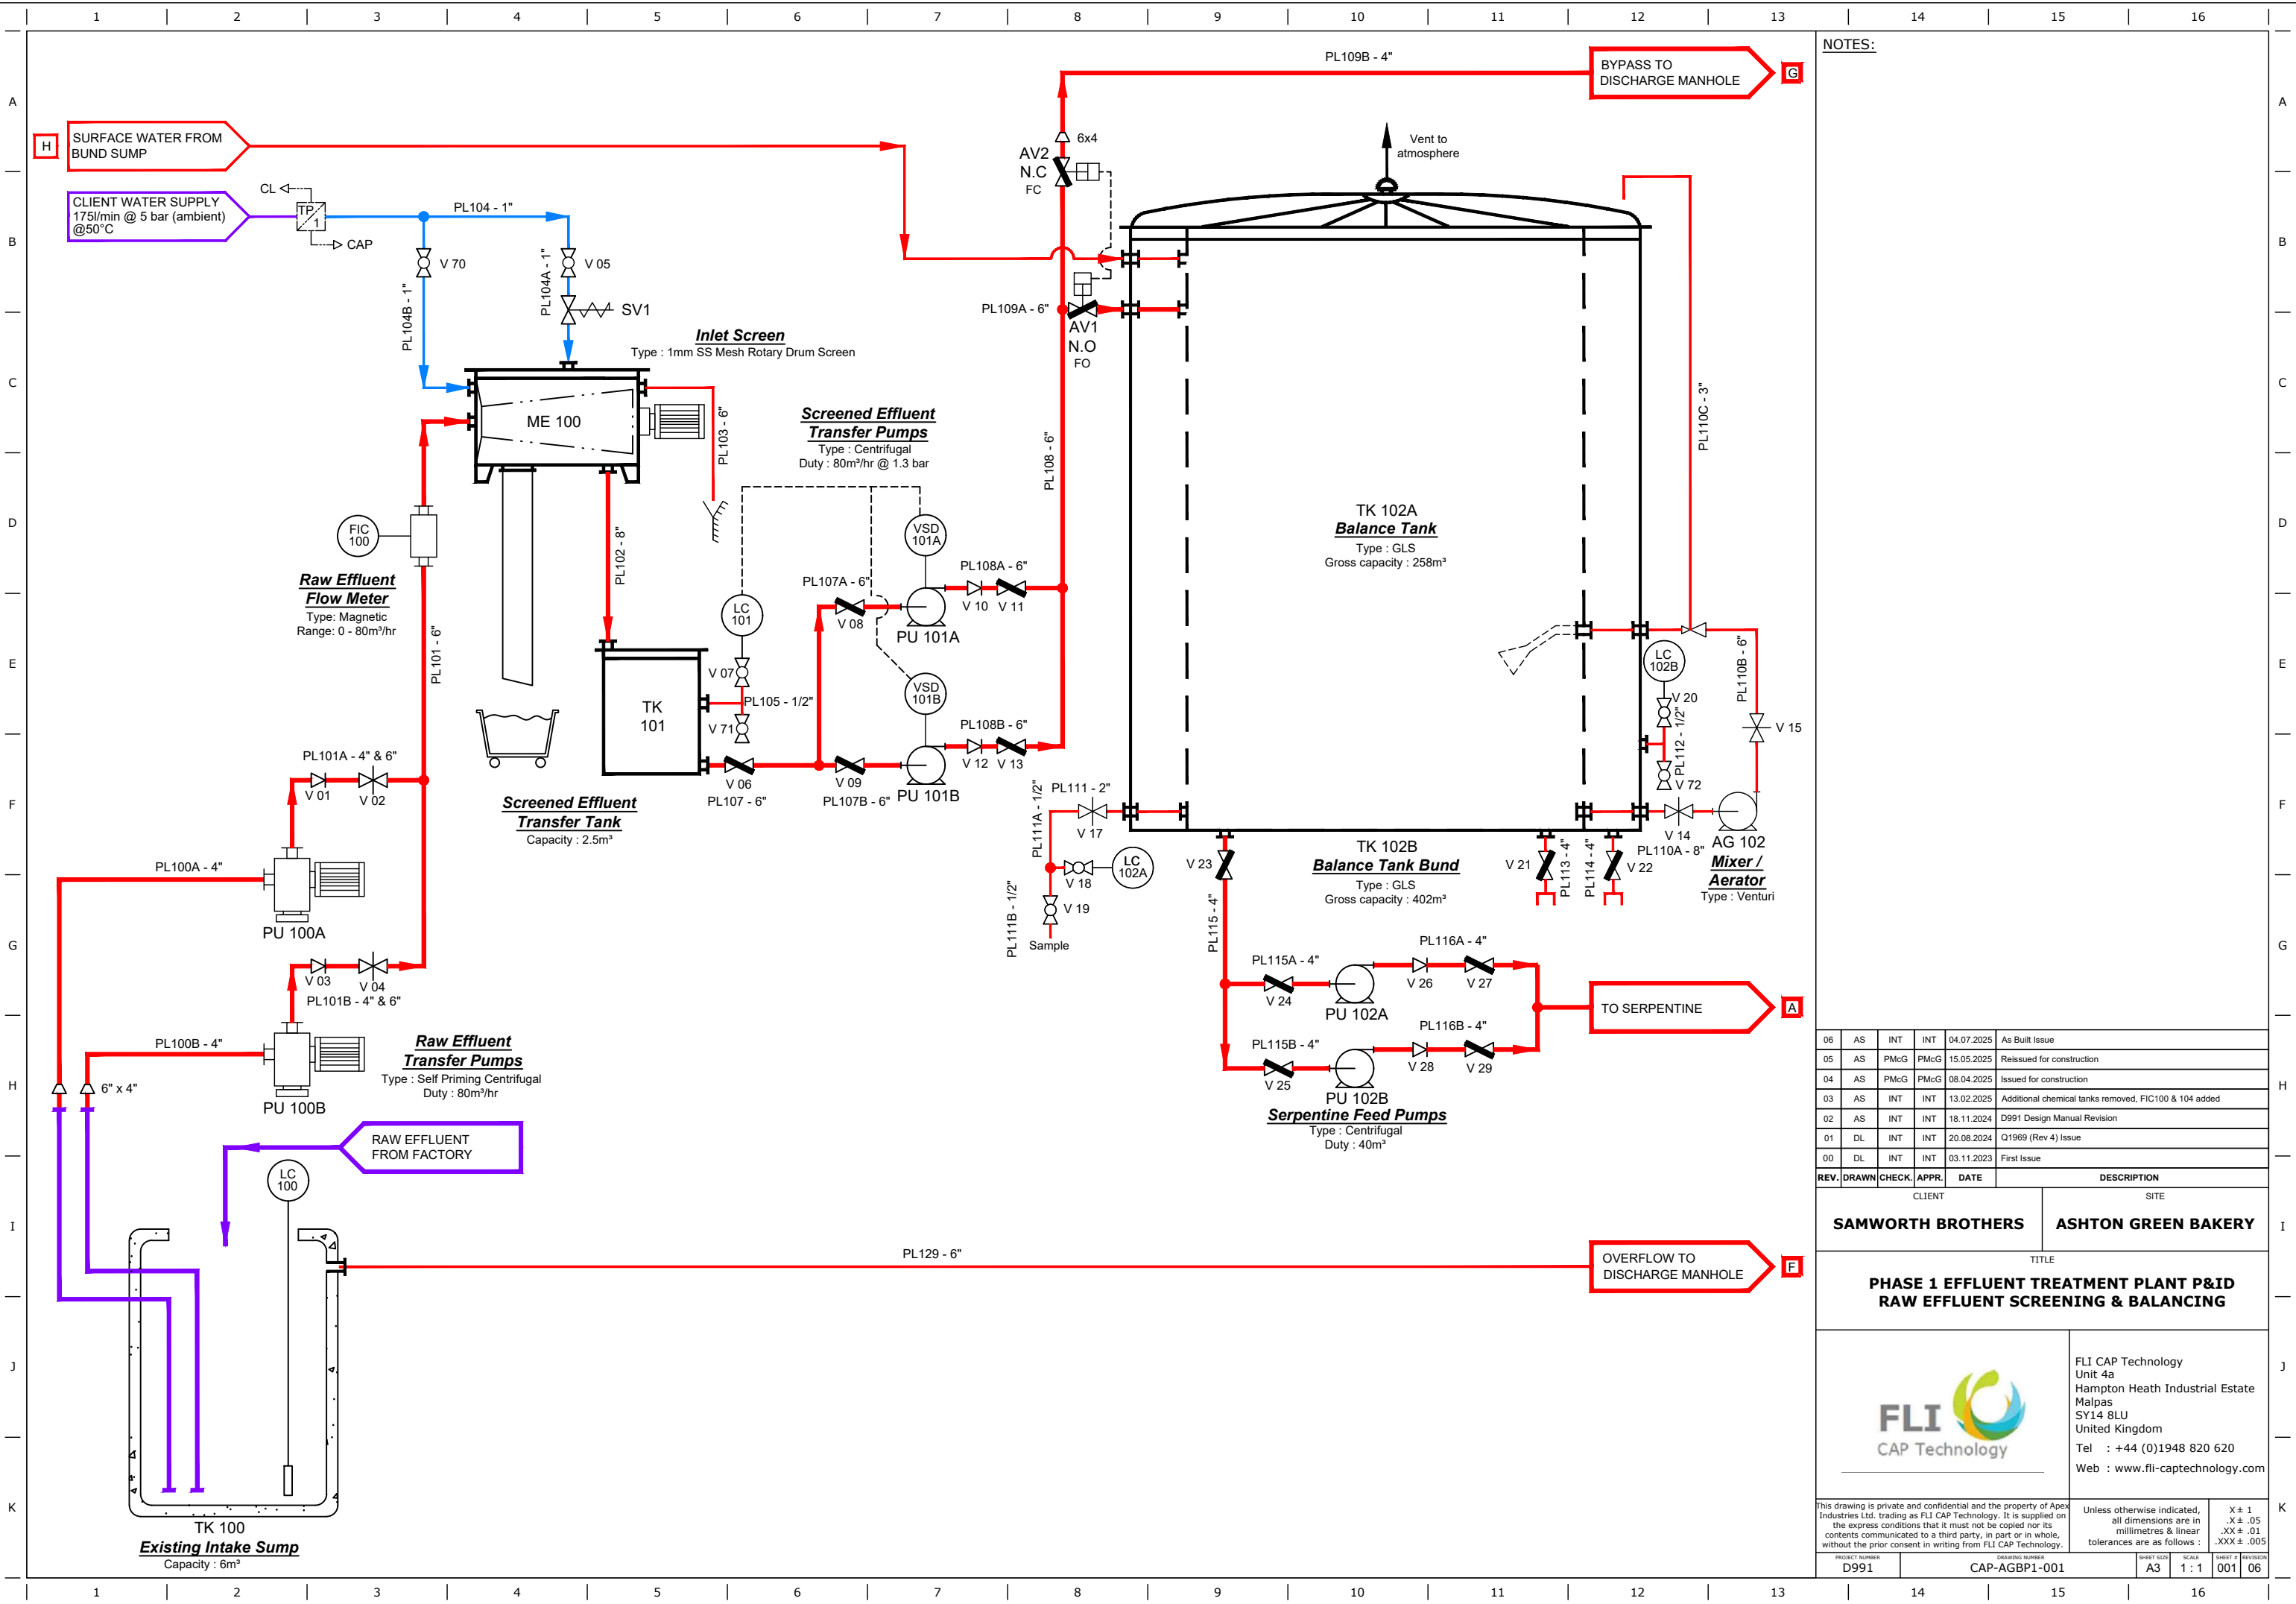

NOTES:

06	AS	INT	INT	04.07.2025	As Built Issue
05	AS	PMcG	PMcG	15.05.2025	Reissued for construction
04	AS	PMcG	PMcG	08.04.2025	Issued for construction
03	AS	INT	INT	13.02.2025	Additional chemical tanks removed, FIC100 & 104 added
02	AS	INT	INT	18.11.2024	D991 Design Manual Revision
01	DL	INT	INT	20.08.2024	Q1969 (Rev 4) Issue
00	DL	INT	INT	03.11.2023	First Issue
REV.	DRAWN	CHECK	APPR.	DATE	DESCRIPTION

CLIENT	SITE
SAMWORTH BROTHERS	ASHTON GREEN BAKERY

TITLE
PHASE 1 EFFLUENT TREATMENT PLANT P&ID RAW EFFLUENT SCREENING & BALANCING

	FLI CAP Technology Unit 4a Hampton Heath Industrial Estate Malpas SY14 8LU United Kingdom Tel : +44 (0)1948 820 620 Web : www.fli-captechnology.com
---	--

This drawing is private and confidential and the property of Apex Industries Ltd. trading as FLI CAP Technology. It is supplied on the express conditions that it must not be copied nor its contents communicated to a third party, in part or in whole, without the prior consent in writing from FLI CAP Technology.	Unless otherwise indicated, all dimensions are in millimetres & linear tolerances are as follows :	X ± 1 .X ± .05 .XX ± .01 .XXX ± .005
---	--	---

PROJECT NUMBER D991	DRAWING NUMBER CAP-AGBP1-001	SHEET SIZE A3	SCALE 1 : 1	SHEET # 001	REVISION 06
------------------------	---------------------------------	------------------	----------------	----------------	----------------

