


**PRIVATE DRAINAGE KEY**

	SCOPE OF WORKS BOUNDARY
	FOUL WATER DRAIN
	FOUL WATER RISING MAIN
	SURFACE WATER DRAIN
	SURFACE WATER RISING MAIN
	SURFACE WATER HIGH CAPACITY DRAINAGE GUTTER
	SURFACE WATER HIGH CAPACITY DRAINAGE CHANNEL
	3 x 100 Ø RIGIDDUCT FOR POWER & DATA
	SURFACE WATER DRAIN
	EXISTING SURFACE WATER DRAIN
	DRAIN TO BE ABANDONED
	SURFACE WATER MANHOLE
	SURFACE WATER PISC - 450mm DSA
	FOUL WATER PISC - 450mm DSA
	ACCESS BOX UP TO 225 (D450) ACC000118
	ACCESS BOX UP TO 600 (D450) ACC000122
	1000 Ø 1:100
	SUSPENDED SURFACE WATER

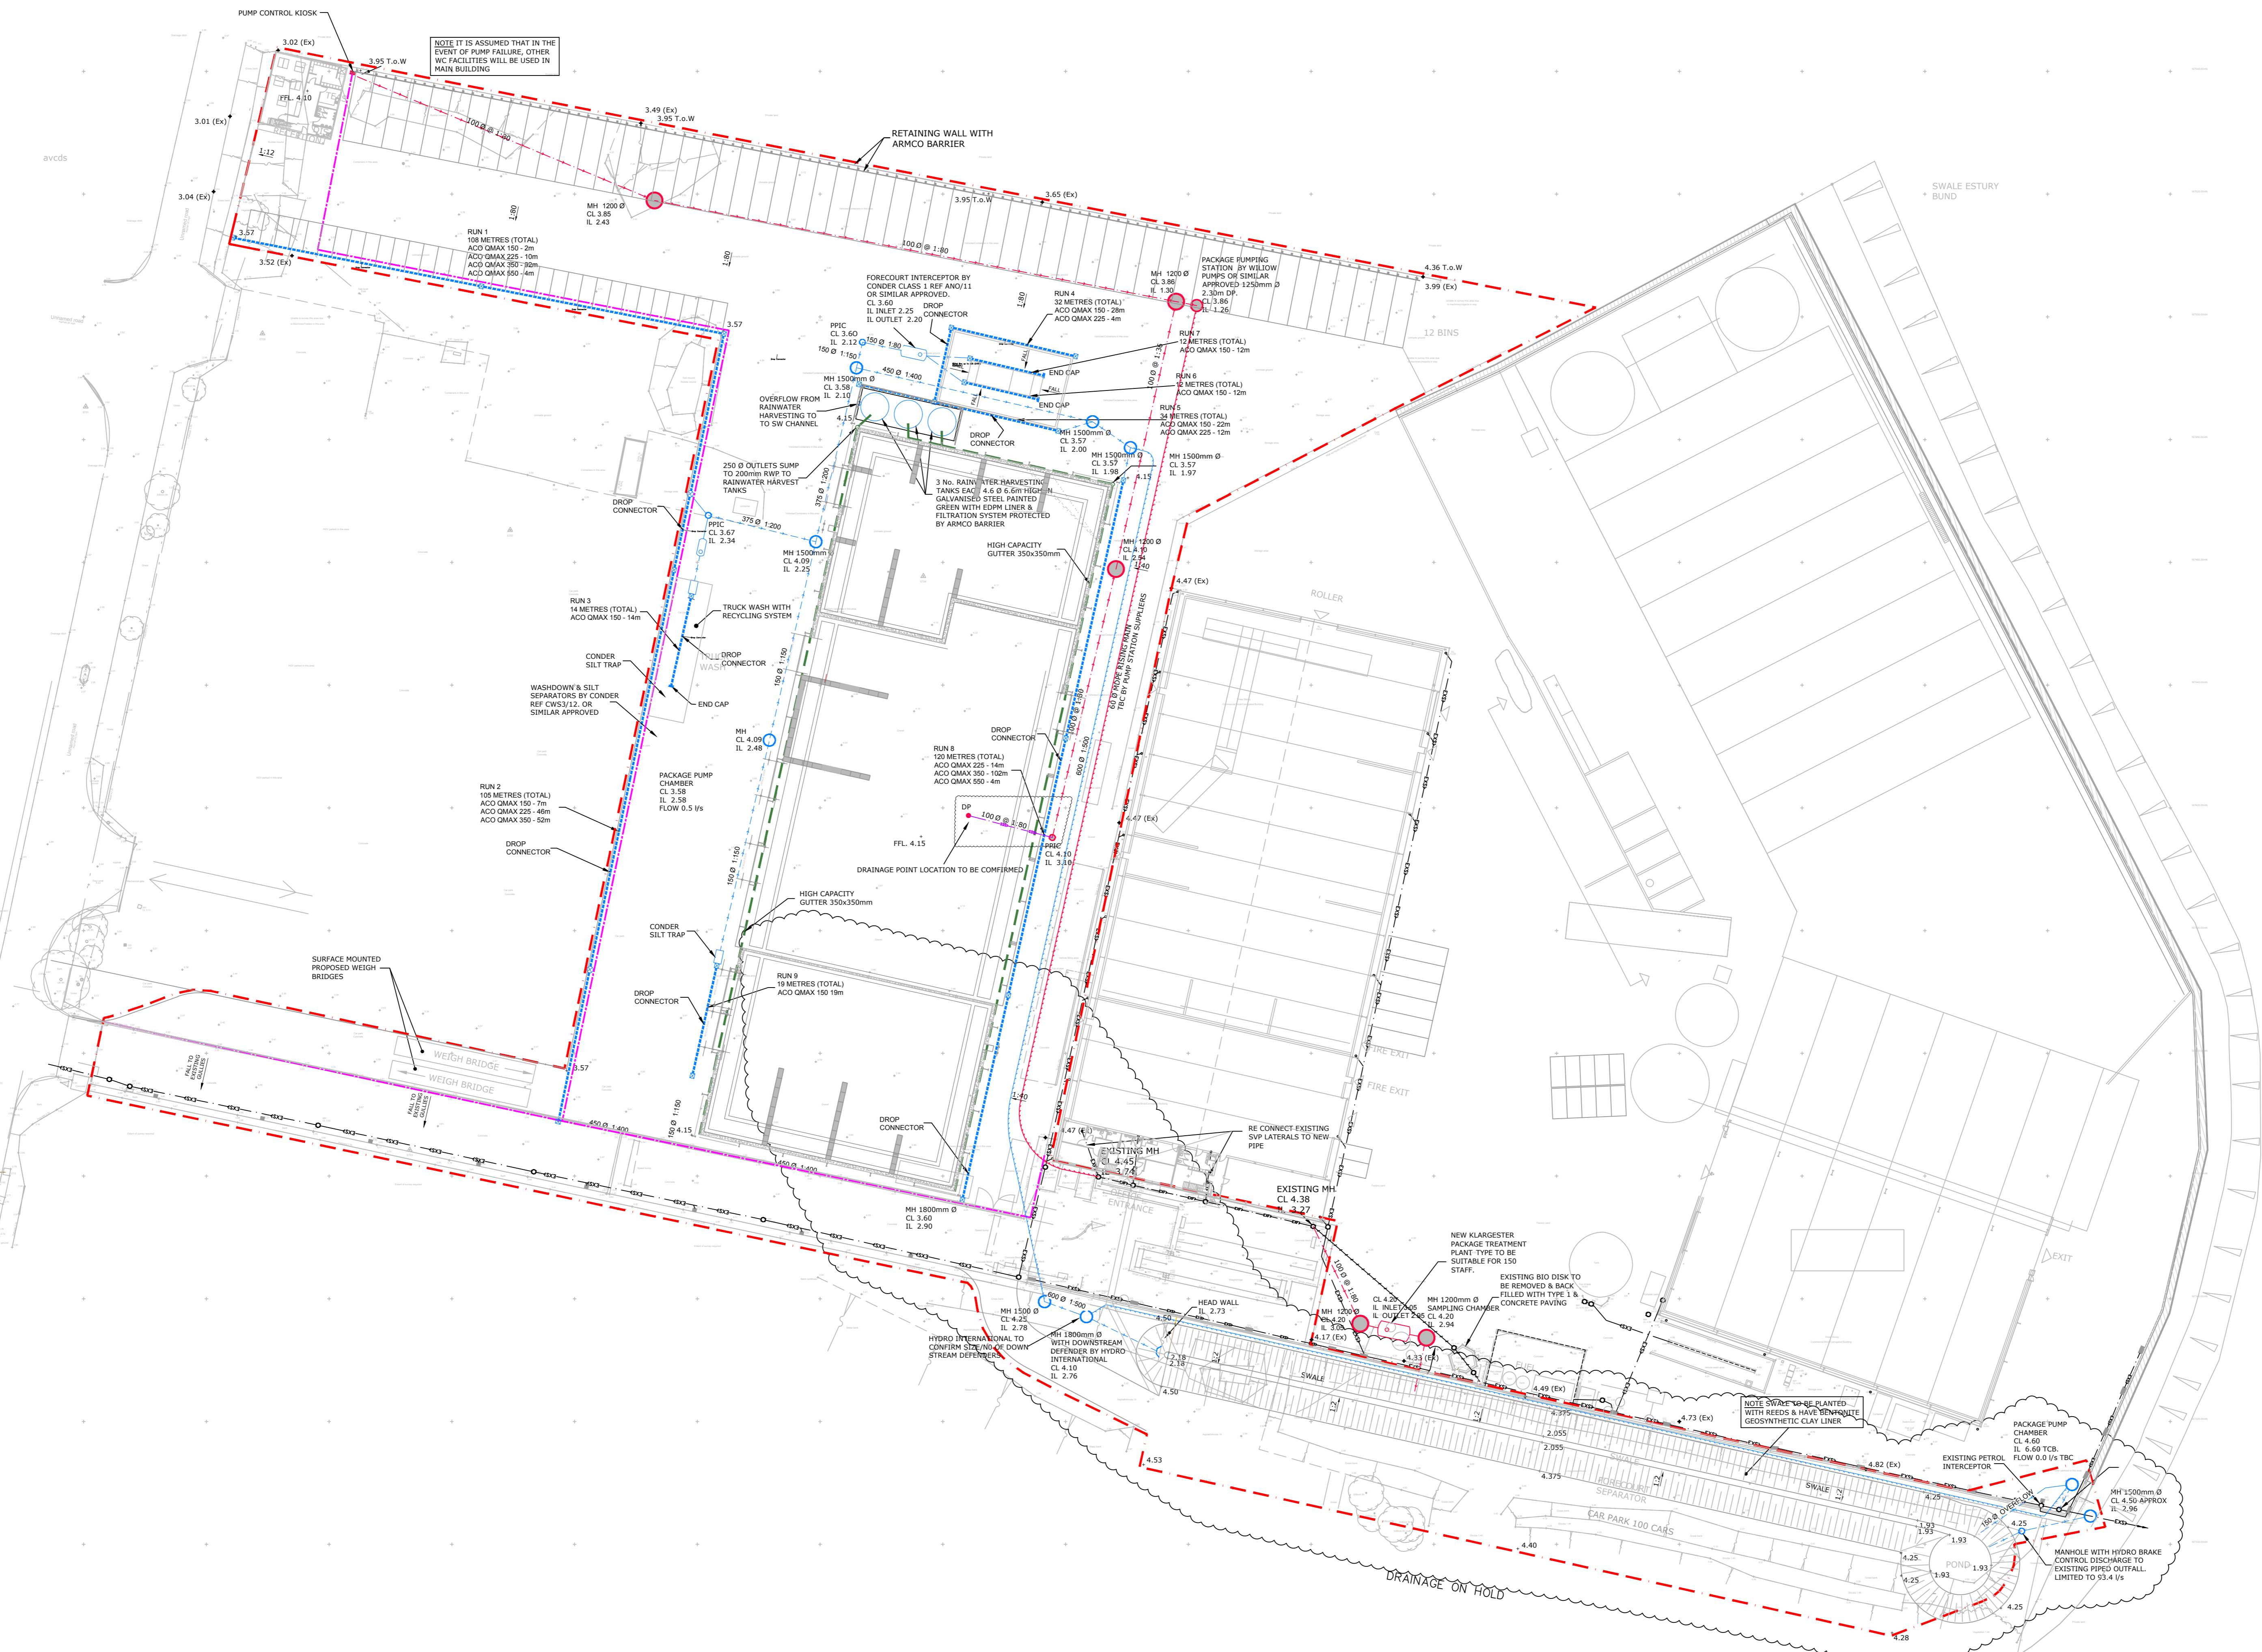

**NOTES**

1. THIS DRAWING IS TO BE READ IN CONJUNCTION WITH ALL RELEVANT ENGINEER'S, ARCHITECT'S AND SPECIALIST'S DRAWINGS AND THE SPECIFICATION.
2. **DO NOT SCALE** FROM THIS DRAWING MANUALLY OR ELECTRONICALLY. WRITTEN PERMISSION MUST BE OBTAINED FROM MLM PRIOR TO SCALING ELECTRONICALLY OR USING THIS ELECTRONIC FILE.

**CONSTRUCTION (DESIGN AND MANAGEMENT) REGULATIONS 2015**  
**DESIGNERS HAZARD INFORMATION FOR CONSTRUCTION**

1. IF YOU DO NOT FULLY UNDERSTAND THE RISKS INVOLVED DURING THE CONSTRUCTION OF THE ITEMS INDICATED ON THIS DRAWING ASK YOUR MANAGER, HEALTH & SAFETY ADVISOR OR A MEMBER OF THE DESIGN TEAM BEFORE PROCEEDING.

THE ABOVE NOTES REFER SPECIFICALLY TO THE INFORMATION SHOWN ON THIS DRAWING.  
 REFER TO THE HEALTH AND SAFETY PLAN FOR FURTHER INFORMATION.

C2	15.11.16	DRAINAGE UPDATED	LA	JEB
C1	20.10.16	DRAINAGE UPDATED	LA	JEB
P1	10.08.16	FIRST ISSUE	PSA	JEB

Issue	Date	Description	Made	Checked

Drawing Status: **CONSTRUCTION**

**MLM**  
 Multidisciplinary Consulting  
 190 Eureka Park, Upper Pemberton, Ashford, Kent TN25 4AZ  
 Tel: 01233 610530 Fax: 01233 618299  
 Website: www.mlm.uk.com



Client: **COUNTRY style RECYCLING**

Project: **PROJECT SPA**

Drawing Title: **DRAINAGE LAYOUT**

Drawn/Design	PSA	Date	03.08.16	Scale	1:500 @ A0	
Checked	JEB	Approved	JEB		1:1000 @ A2	
Drawing No.	617551/CIV/003				Rev	C2