


SYMBOLS									
	PLUG VALVE		METER		BOOSTER/COMPRESSOR		MANUAL VALVE		REDUCER
	BALL VALVE		PRESSURE TRANSMITTER		PUMP		PRESSURE CONTROL VALVE		
	SLAM SHUT VALVE		TEMPERATURE TRANSMITTER		CHILLER/HEATER		NORMALLY CLOSED		
	ACTUATED VALVE		HEAT EXCHANGER		GATE VALVE		NORMALLY OPEN		
	NON RETURN VALVE								
	RELIEF VALVE								
	FILTER								
	STATIC MIXER								

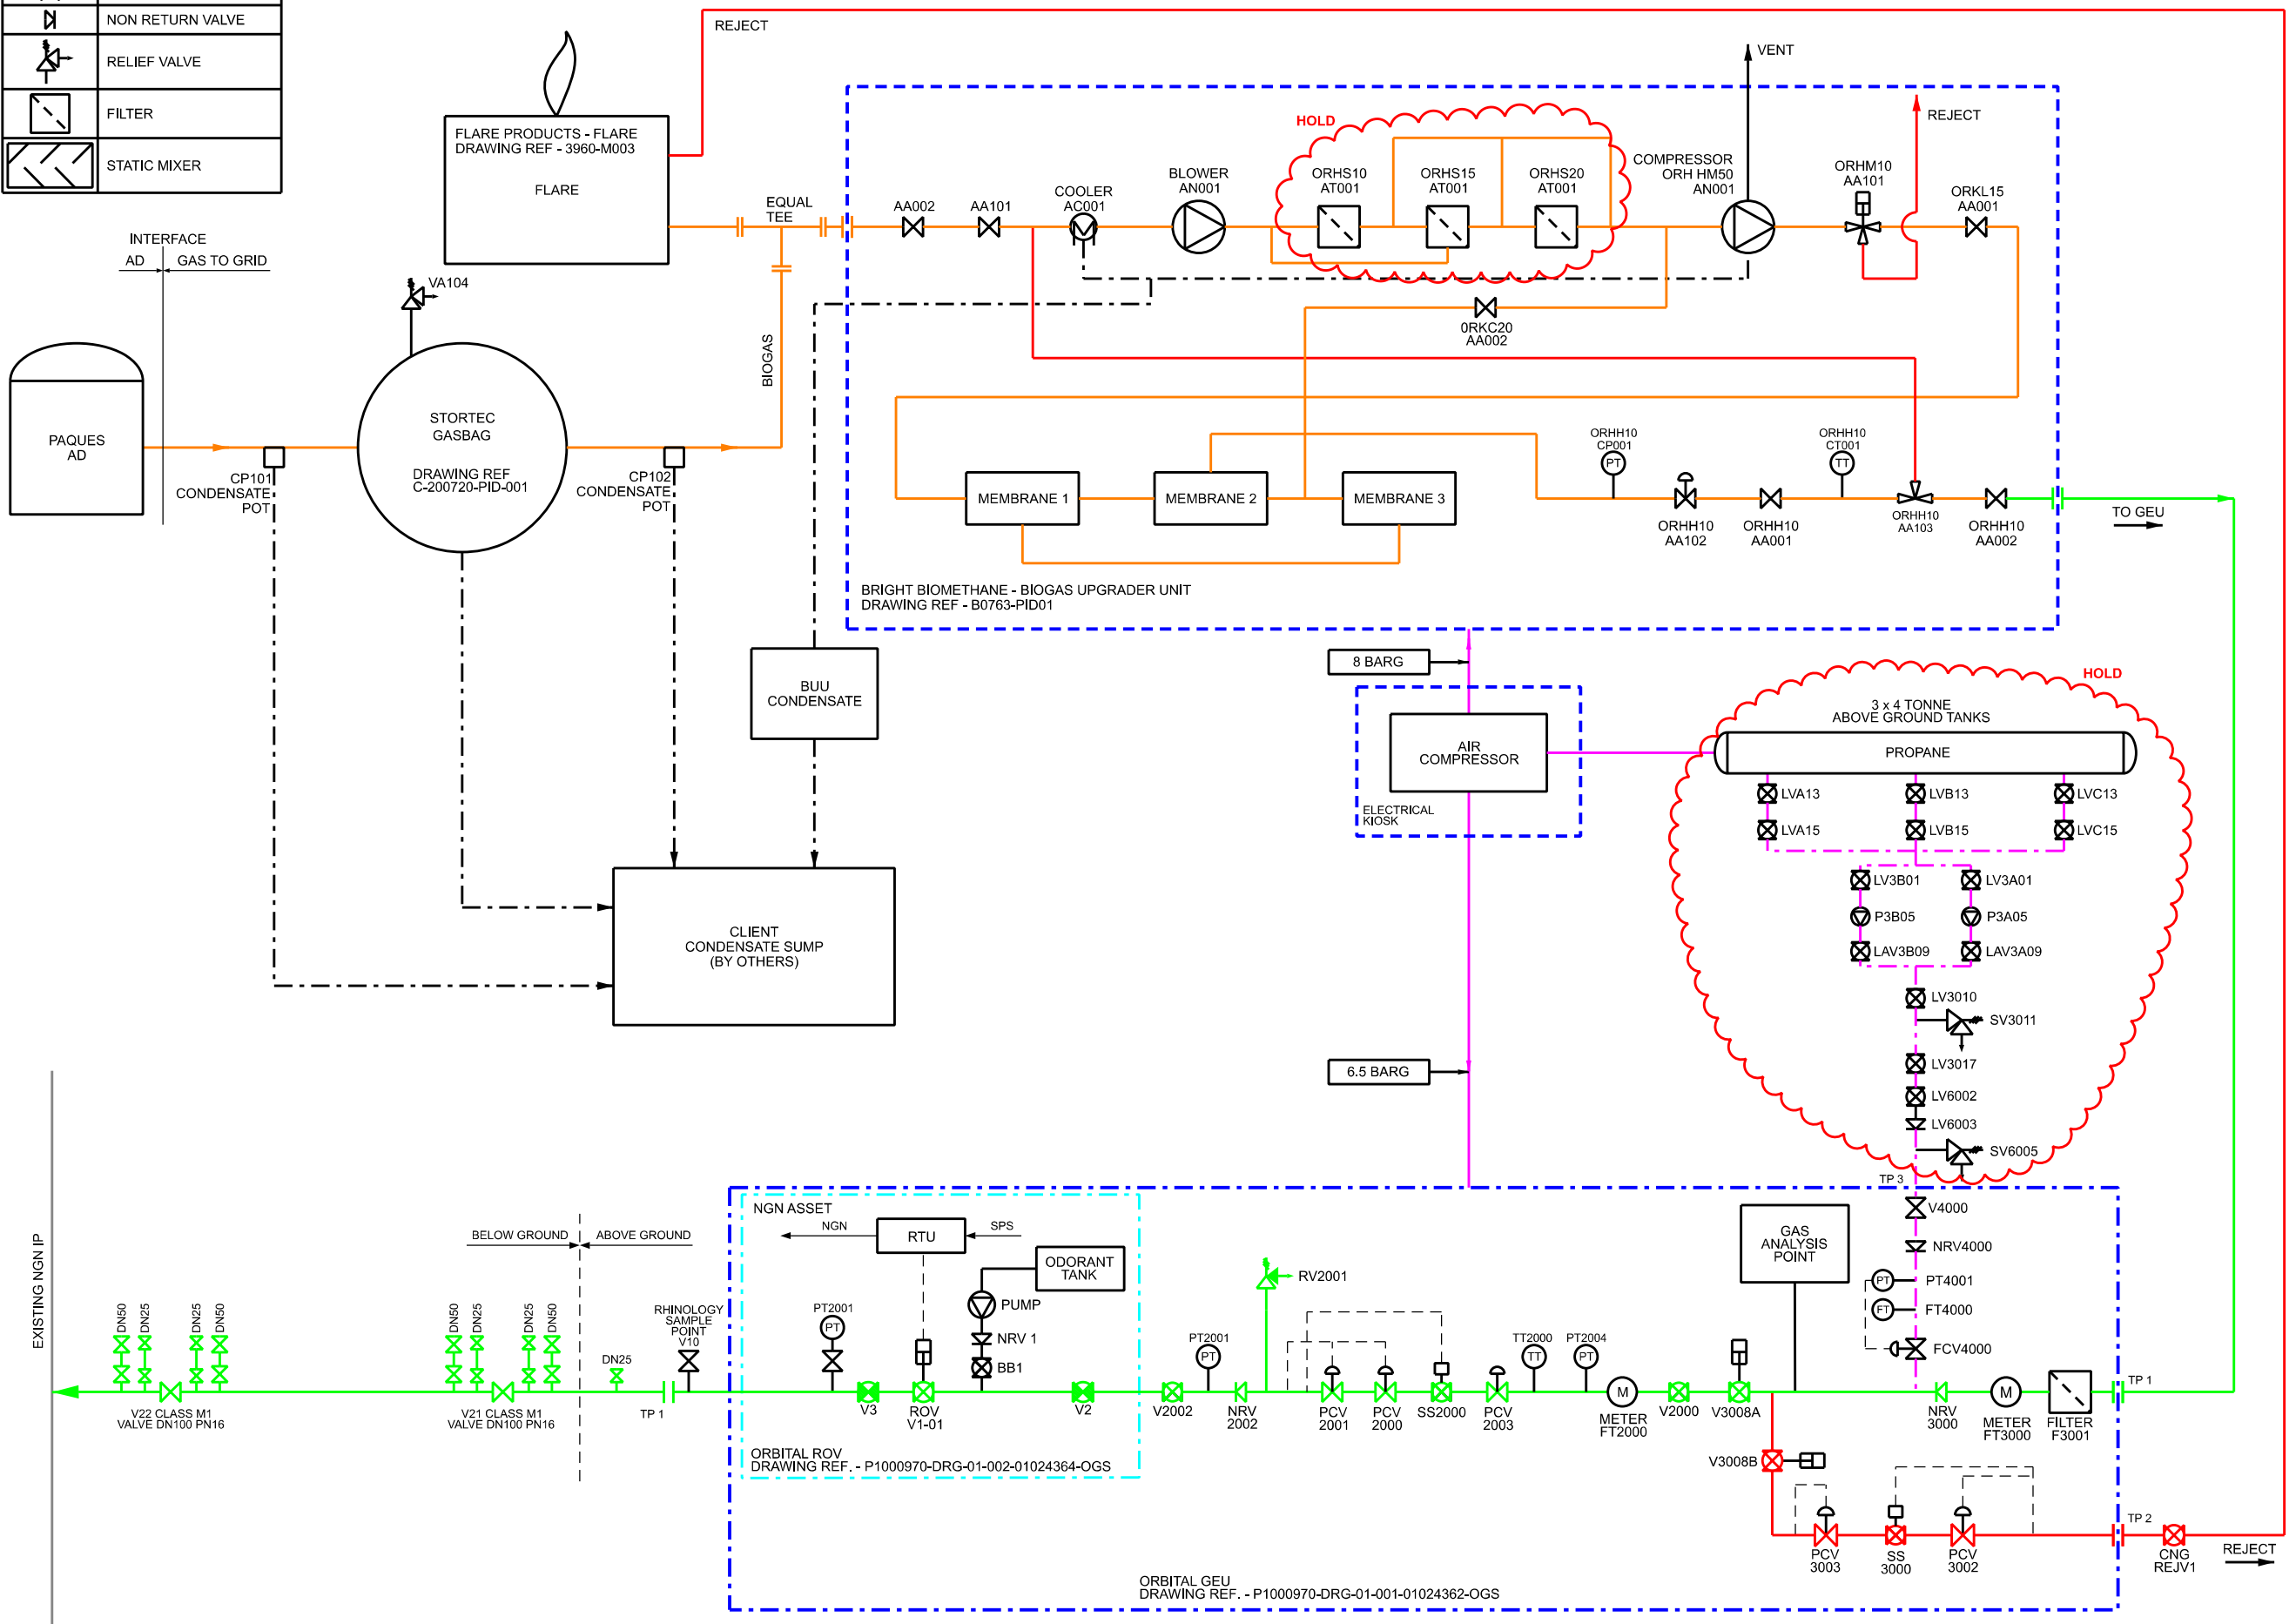

PRELIMINARY ISSUE FOR DISCUSSION ONLY

REVISIONS:				
REV	DESCRIPTION	DATE	CHK	APP
A	INITIAL ISSUE	14/04/21	MB	NR

NOTES

KEY

- REJECT LINE
- BIOMETHANE LINE
- BIOGAS LINE
- COMPRESSED AIR LINE
- CONDENSATE LINE
- PROPANE LINE

FS - FLOW SWITCH
P - PRESSURE
T - TEMPERATURE
F - FLOW
OP - OPERATING PRESSURE
DP - DESIGN PRESSURE
NOP - NORMAL OPERATING PRESSURE
NOT - NORMAL OPERATING TEMPERATURE
PSD - PROCESS SHUT DOWN
TAH - TEMPERATURE ALARM HIGH
TAHH - TEMPERATURE ALARM HIGH / HIGH
TALL - TEMPERATURE ALARM LOW / LOW

CLIENT:
STERLING PHARMA SOLUTIONS LTD

PROJECT:
STERLING PHARMA BTG PROJECT

TITLE:
PROCESS FLOW DIAGRAM

SCALE: N.T.S. @ A3 DRAWN: GW
CHECKED: MB CAD: DATE: 14/04/2021
APPROVED: DM SHEET: 1 OF 1

PROJECT No: 783

DRAWING No: 783-01-BMDR-009

REVISION: A

cng services ltd
VIRGINIA HOUSE
56 WARWICK ROAD
OLTON
SOLIHULL
B92 7HX
COPYRIGHT © 2011-2018
CNG SERVICES LTD
TEL: 0121 2478160
WEB: www.cngservices.co.uk