



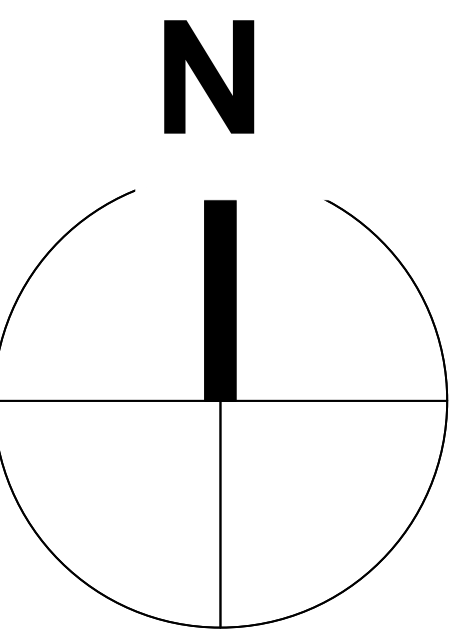

SECURITY LEGEND	
	INTRUDER ALARM PANEL
	DOOR CONTACT
	DUAL TECH PIR DETECTOR
	PUSH TO EXIT BUTTON W/BREAK GLASS
	CARD READER
	MAG LOCK
	VIDEO INTERCOM
	SHUTTER CONTACT
	EXTERNAL BELL BOX
	REMOTE INPUT/OUTPUT
	ACCESS CONTROL DOOR
	COLUMN MOUNTED REDWALL SIP

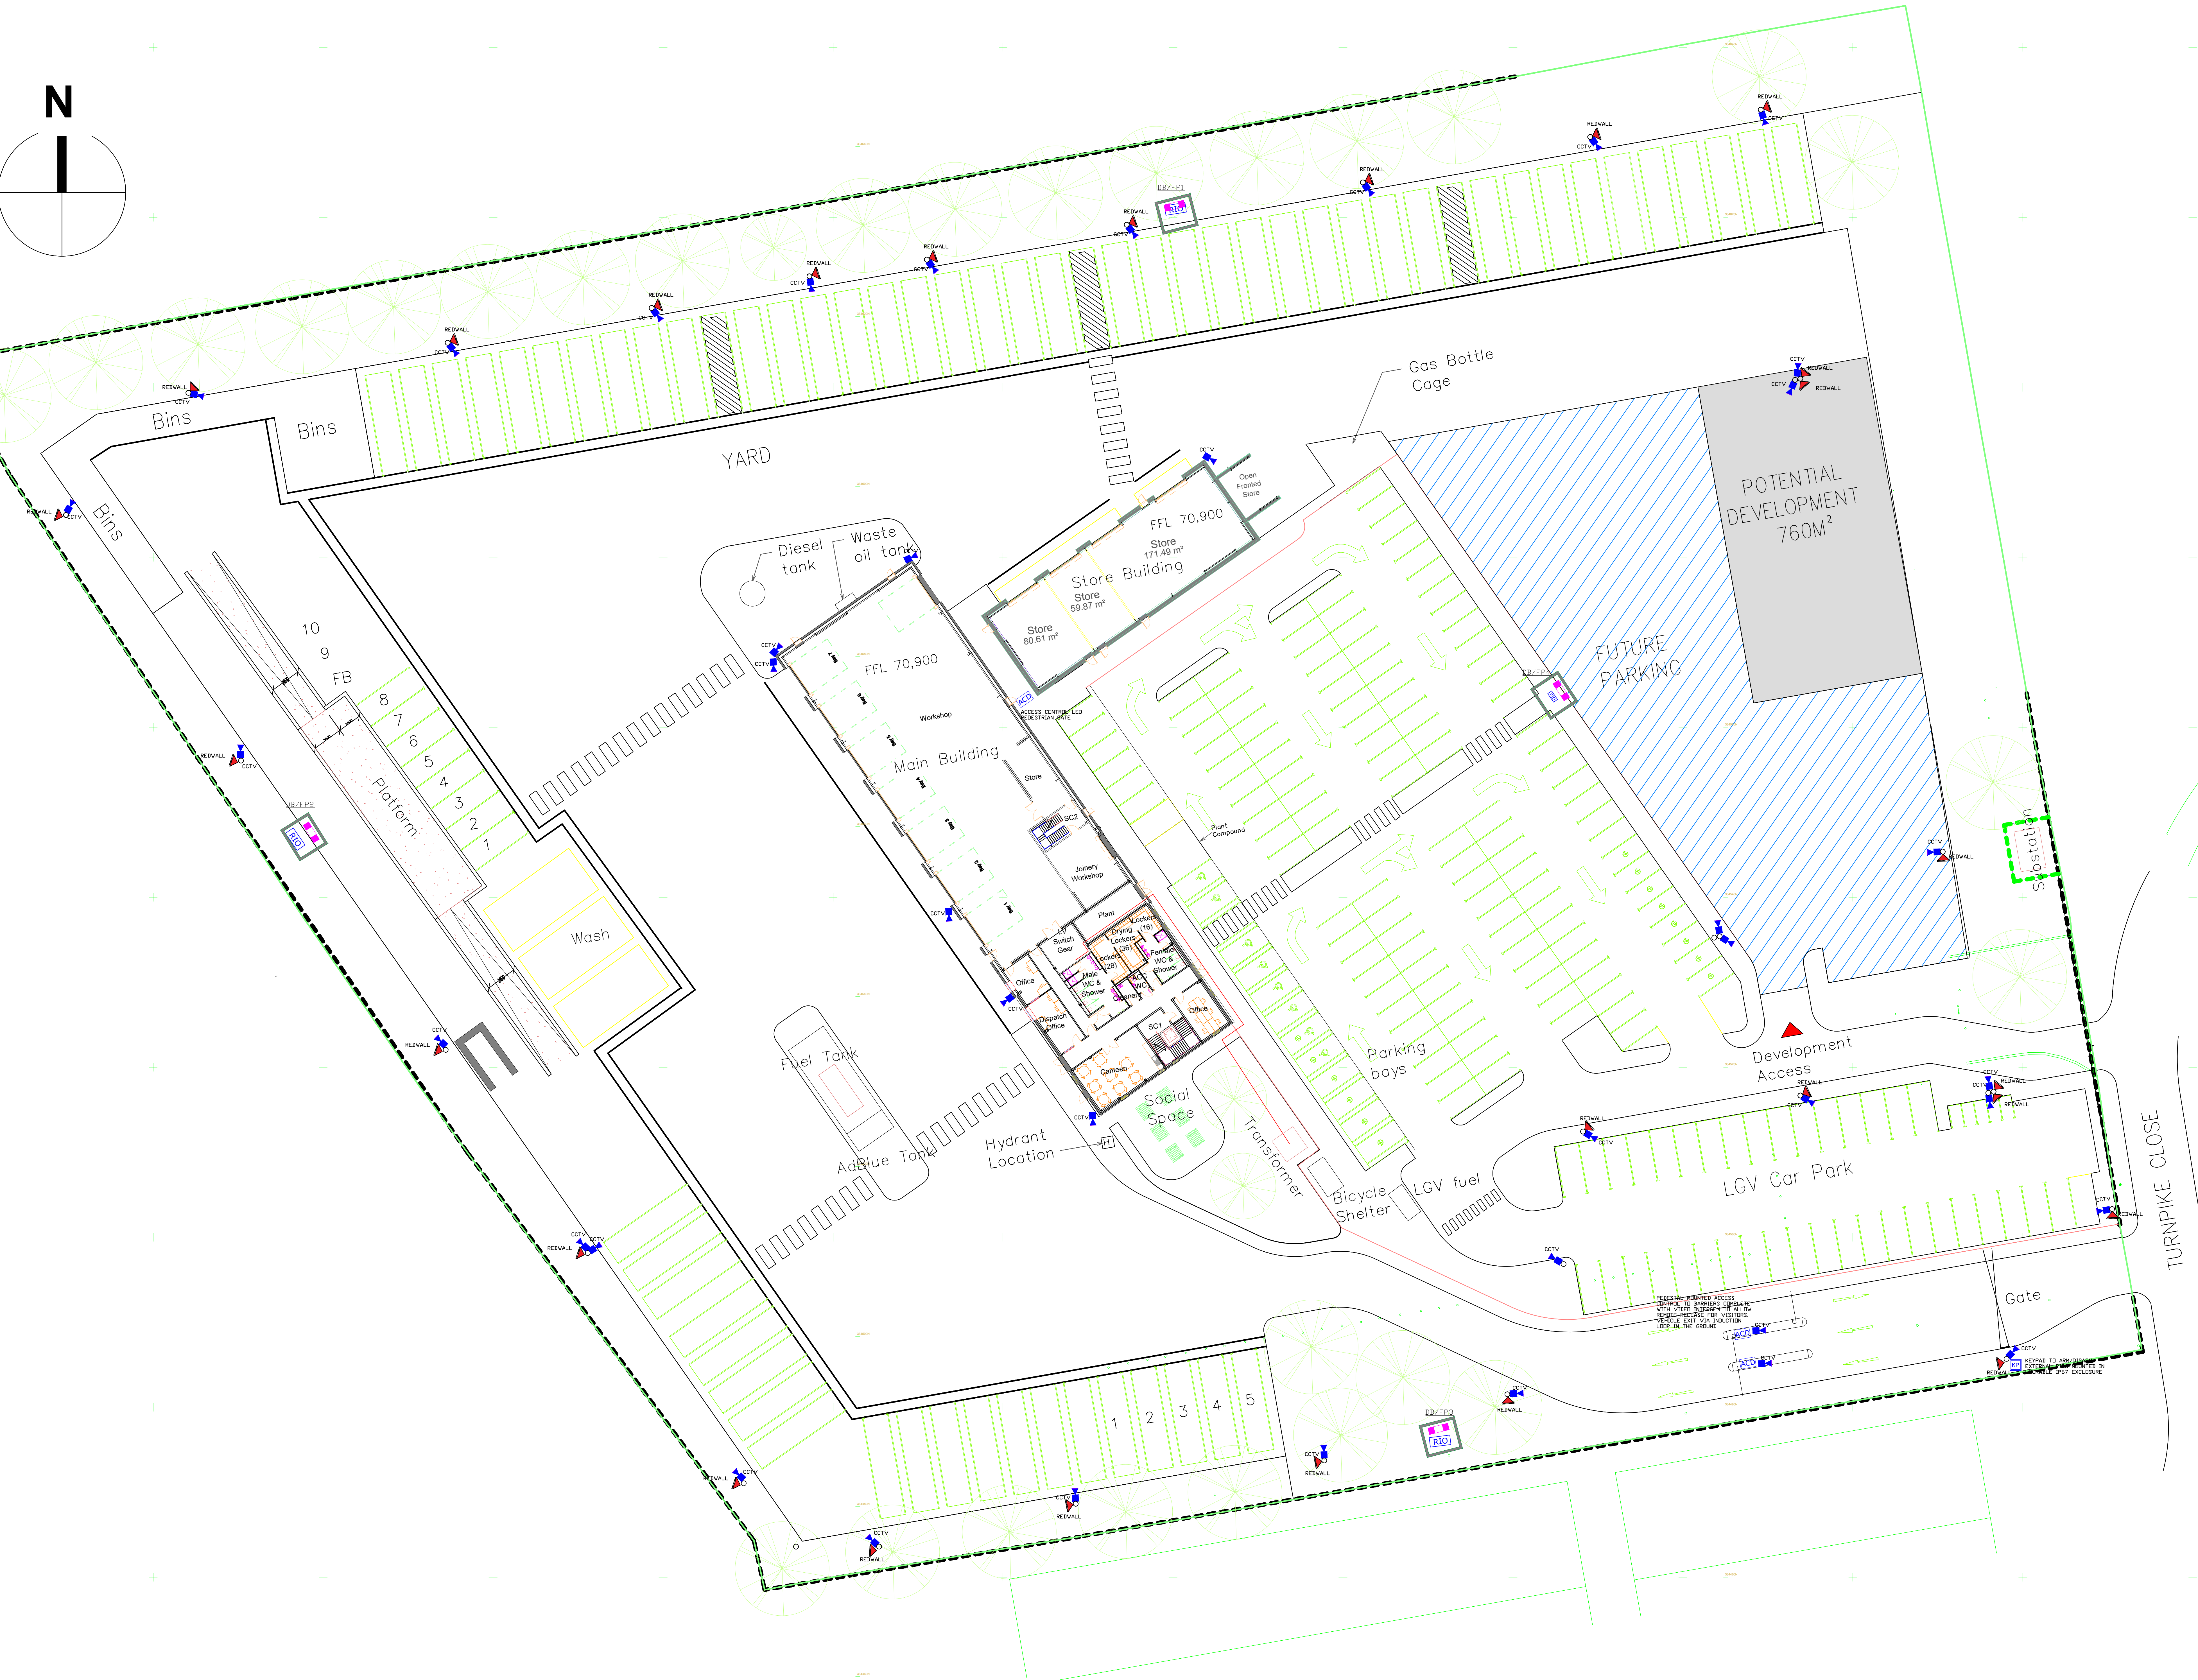

ISSUED FOR COMMENT

P2	15/11/24	Updated Following AGI Comments on 10/10/24	JDL	TB
P1	13/09/24	Issued for Comment	JDL	TB
Rev	Date	Description	By	Chkd

SELMEC (Lincoln) Ltd
Electrical & Mechanical Building Services Engineers and Contractors
UNIT 10 GATEWAY COURT
DANKERWOOD ROAD
SOUTH HYKEHAM
LINCOLN LN6 9UL
EMAIL office@selmec.co.uk
TELEPHONE 01522 500777
FAX 01522 691386

Client:

SOUTH KESTEVEN DISTRICT COUNCIL

Project: SKDC Turnpike Depot - External

Drawing Title: Proposed Security Layout

Scale: 1:250 @ A0	Drawn By: JDL
Date: 15/11/2024	Checked By: TB

Project No: 39714-24/CONE	Revision: P2
Drawing No: TCD-SEL-S1-XX-DR-E-2601	