

STEAM AND WATER CYCLE

© 2021 RPS Group
 Notes
 1. This drawing has been prepared in accordance with the scope of RPS's appointment with its client and is subject to the terms and conditions of that appointment. RPS accepts no liability for any use of this document other than by its client and only for the purposes for which it was prepared and provided.
 2. If received electronically it is the recipient's responsibility to print to correct scale. Only written dimensions should be used.

- NOTES**
- SEE 112101-00-YDS-MDB-SNL-001 FOR SYMBOLS, LEGENDS AND GENERAL NOTES.
 - MARKED *** ITEMS ARE PART OF STG SUPPLIER SCOPE (LOOSE SUPPLIED) AND INSTALLED IN METKA PIPING. SAME WILL BE VERIFIED AFTER STG INPUT.
 - REFER RESPECTIVE SYSTEM P&IDS FOR FURTHER DETAILS OF INSTRUMENTATION, SIZES, PROCESS PARAMETERS AND SYSTEM SPECIFIC DESIGN NOTES.
 - RESPECTIVE P&IDS TO BE FOLLOWED IN CASE OF DISCREPANCY.
 - DETAILS SHOWN HERE ARE PRELIMINARY AND SAME SHALL BE UPDATED AS PER ENGINEERING PROGRESS.

SBE = BOILER OEM (STEINMÜLLER BABCOCK ENVIRONMENT)
 STG = STEAM TURBINE OEM
 ACC = AIR COOLED CONDENSER OEM
 TBD = TO BE DECIDED


Rev	Description	By	CB	Date

rps MAKING COMPLEX EASY
 20 Western Avenue, Milton Park, Abingdon, Oxfordshire, OX14 4SH
 T: +44(0)1235 821 888 E: rps@rpsgroup.com

Client -
 Project **Corby Energy from Waste Facility**
 Title **Overall Process Flow Diagram**

Status **FINAL** Drawn By **JM** PM/Checked By **TH**
 Project Number **JER9793** Scale **@ A3** Date Created **DEC 2022**
 Figure Number - Rev -

PROPRIETARY INFORMATION
 This document contains proprietary information of MTFILNESIS and is to be used solely for the Project and the purpose for which it is furnished.
 It may not be disclosed to others for a different use without the written permission of MTFILNESIS.
 rpsgroup.com

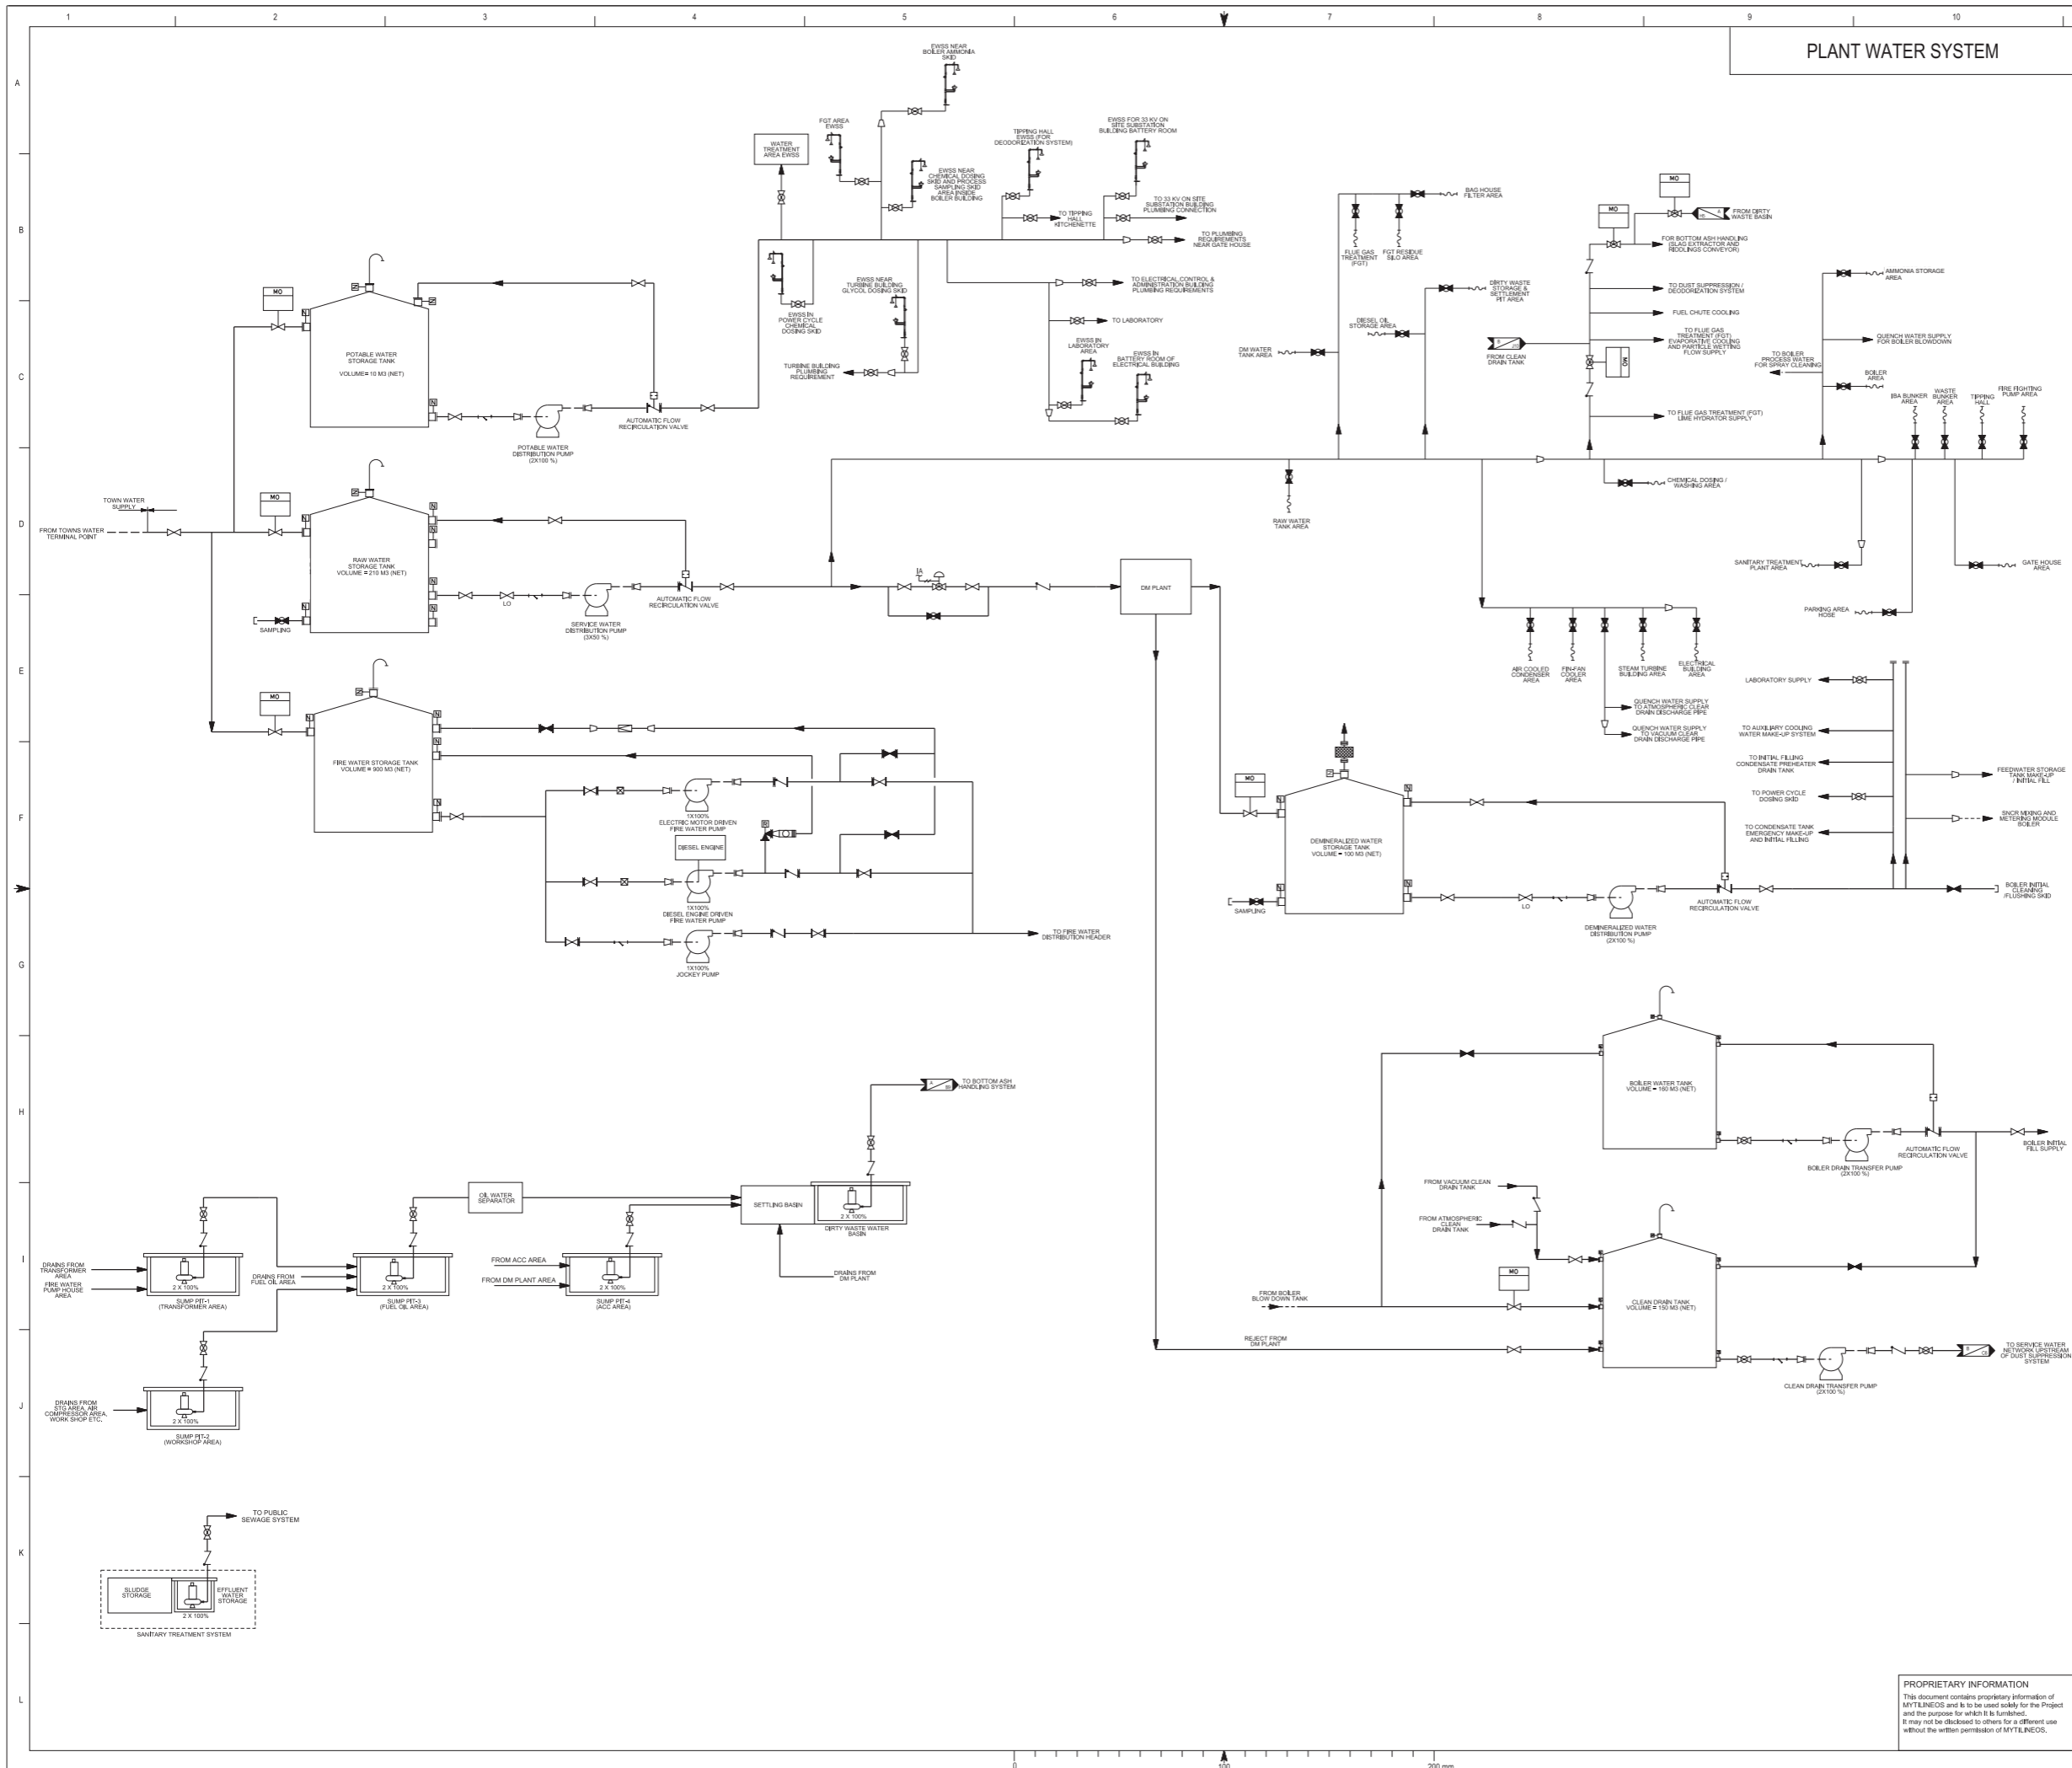

PLANT WATER SYSTEM

© 2021 RPS Group
 Notes
 1. This drawing has been prepared in accordance with the scope of RPS's appointment with its client and is subject to the terms and conditions of that appointment. RPS accepts no liability for any use of this document other than by its client and only for the purposes for which it was prepared and provided.
 2. If received electronically it is the recipient's responsibility to print to correct scale. Only written dimensions should be used.

NOTES

- SEE 112101-00-YDS-MDB-SNL-001 FOR SYMBOLS, LEGENDS AND GENERAL NOTES.
- MARKED "*" ITEMS ARE PART OF STG SUPPLIER SCOPE (LOOSE SUPPLIED) AND INSTALLED IN METKA PIPING. SAME WILL BE VERIFIED AFTER STG INPUT.
- REFER RESPECTIVE SYSTEM P&IDS FOR FURTHER DETAILS OF INSTRUMENTATION, SIZES, PROCESS PARAMETERS AND SYSTEM SPECIFIC DESIGN NOTES.
- RESPECTIVE P&IDS TO BE FOLLOWED IN CASE OF DISCREPANCY.
- DETAILS SHOWN HERE ARE PRELIMINARY AND SAME SHALL BE UPDATED AS PER ENGINEERING PROGRESS.

SBE = BOILER OEM (STEINMÜLLER BABCOCK ENVIRONMENT)
 STG = STEAM TURBINE OEM
 ACC = AIR COOLED CONDENSER OEM
 TBD = TO BE DECIDED

Rev	Description	By	CB	Date



20 Western Avenue, Milton Park, Abingdon, Oxfordshire, OX14 4SH
 T: +44(0)1235 821 888 E: rps@rpsgroup.com

Client -
 Project **Corby Energy from Waste Facility**
 Title **Overall Process Flow Diagram**

Status **FINAL** Drawn By **JM** PM/Checked By **TH**
 Project Number **JER9793** Scale **@ A3** Date Created **DEC 2022**

Figure Number - Rev -

PROPRIETARY INFORMATION
 This document contains proprietary information of MYTILNEOS and is to be used solely for the project and the purposes for which it is furnished. It may not be disclosed to others for a different use without the written permission of MYTILNEOS.