


KN04 J Connection to Foul Sewer

POLLUTION CONTROL - DRAINAGE PLAN

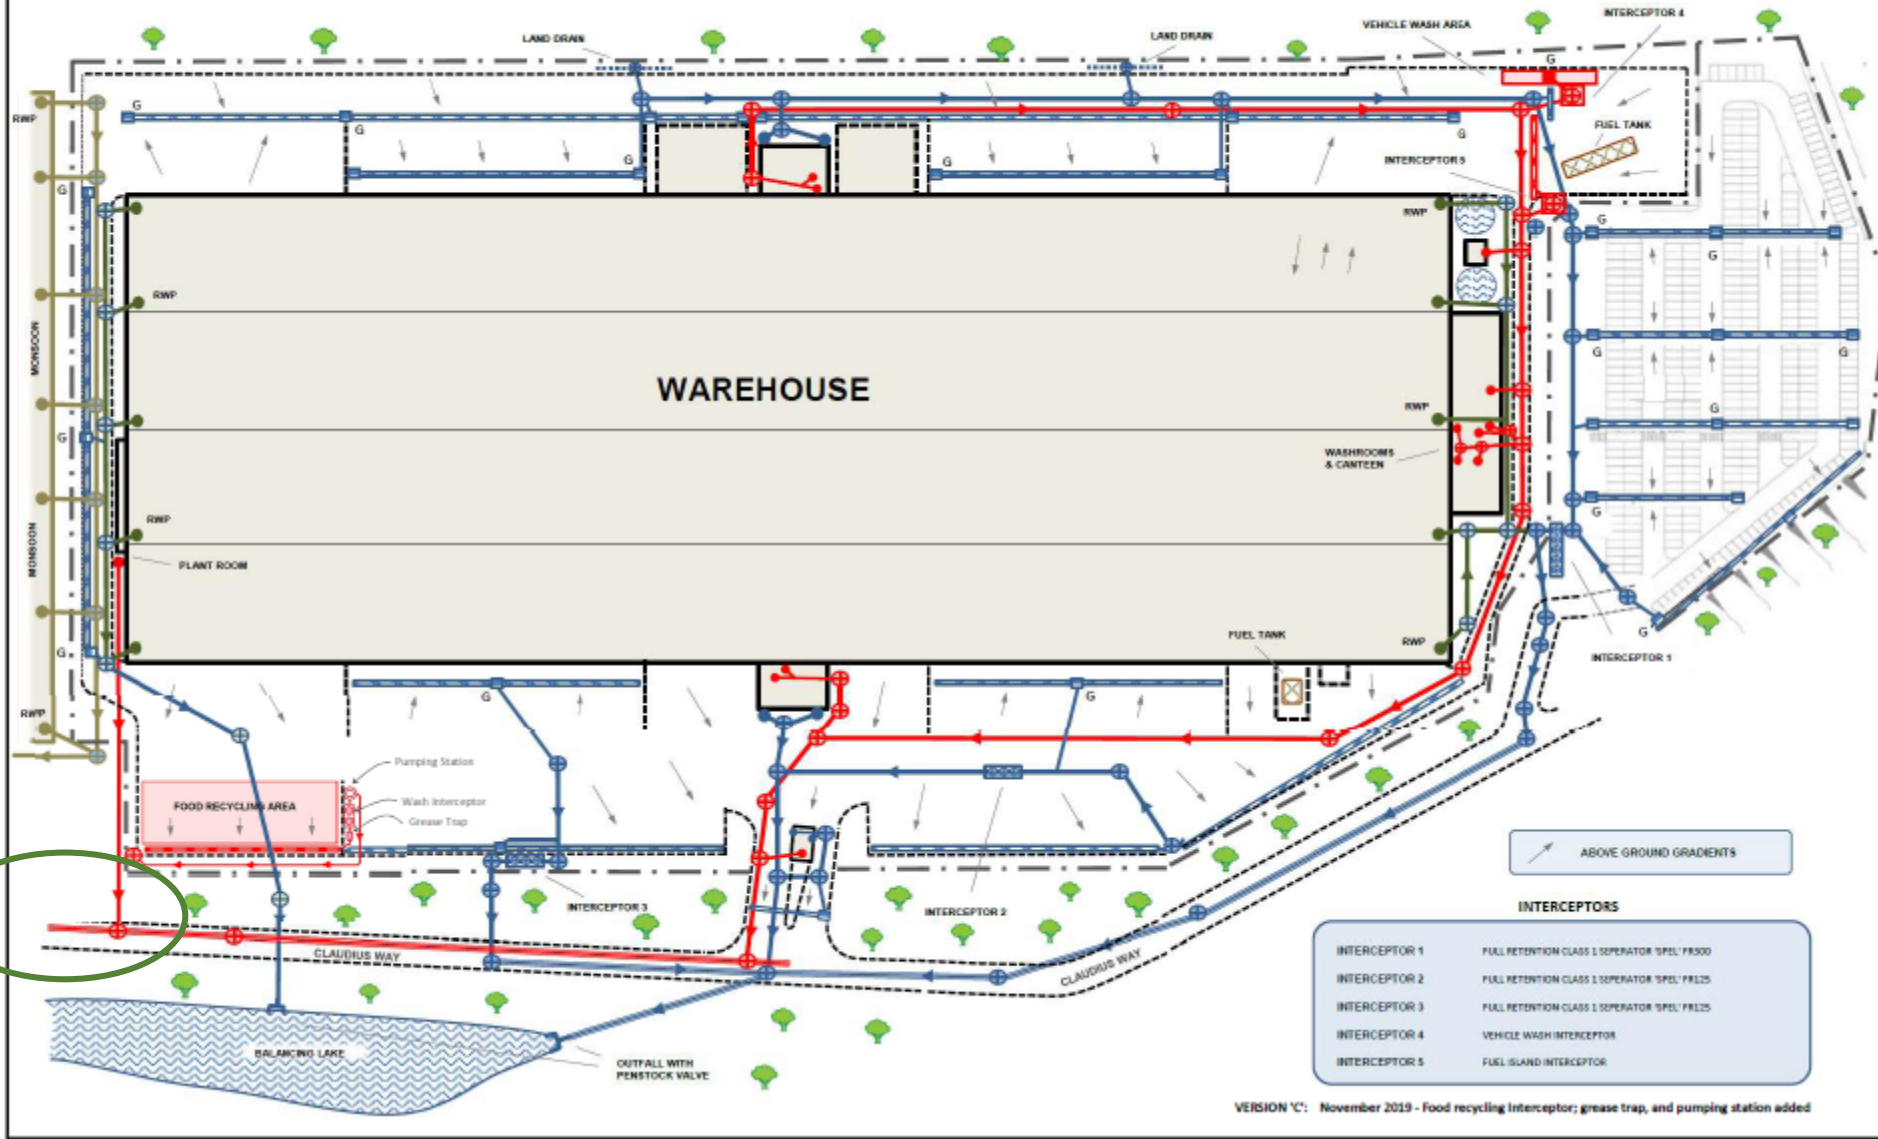

LEGEND

- SITE STORM DRAIN
- ⊕ STORM WATER MANHOLE
- STORM WATER GULLY
- RAINWATER DOWNPIPE (RWP)
- ⋯ LAND DRAIN
- STORM WATER INTERCEPTOR
- FOUL WATER DRAIN
- ⊕ FOUL WATER MANHOLE
- FOUL WATER COLLECTOR (Soil stack WC's etc)
- FOUL WATER INTERCEPTOR
- ROOF WATER DRAINAGE
- ⋯ ADJACENT LIMIT ROOF WATER DRAINAGE (OWN KN SITE)

KUEHNE+NAGEL



WELLINGBOROUGH

Green Spark
ENVIRONMENTAL INTELLIGENCE FOR BUSINESS

2 Fountain Court
Doncaster International Business Park,
DN9 3QR
0330 440 4800

INTERCEPTORS	
INTERCEPTOR 1	FUEL RETENTION CLASS 1 OPERATOR 'SPEL' FR300
INTERCEPTOR 2	FUEL RETENTION CLASS 1 OPERATOR 'SPEL' FR125
INTERCEPTOR 3	FUEL RETENTION CLASS 1 OPERATOR 'SPEL' FR125
INTERCEPTOR 4	VEHICLE WASH INTERCEPTOR
INTERCEPTOR 5	FUEL ISLAND INTERCEPTOR

VERSION 'C': November 2019 - Food recycling Interceptor; grease trap, and pumping station added

Compiled By - <i>Bryon Allen</i>	August 2016
DRAWING No. 1608-02	VERSION 'C'

Connection to estate foul sewer