


H a x t e r C l o s e

B e l l i v e r W a y

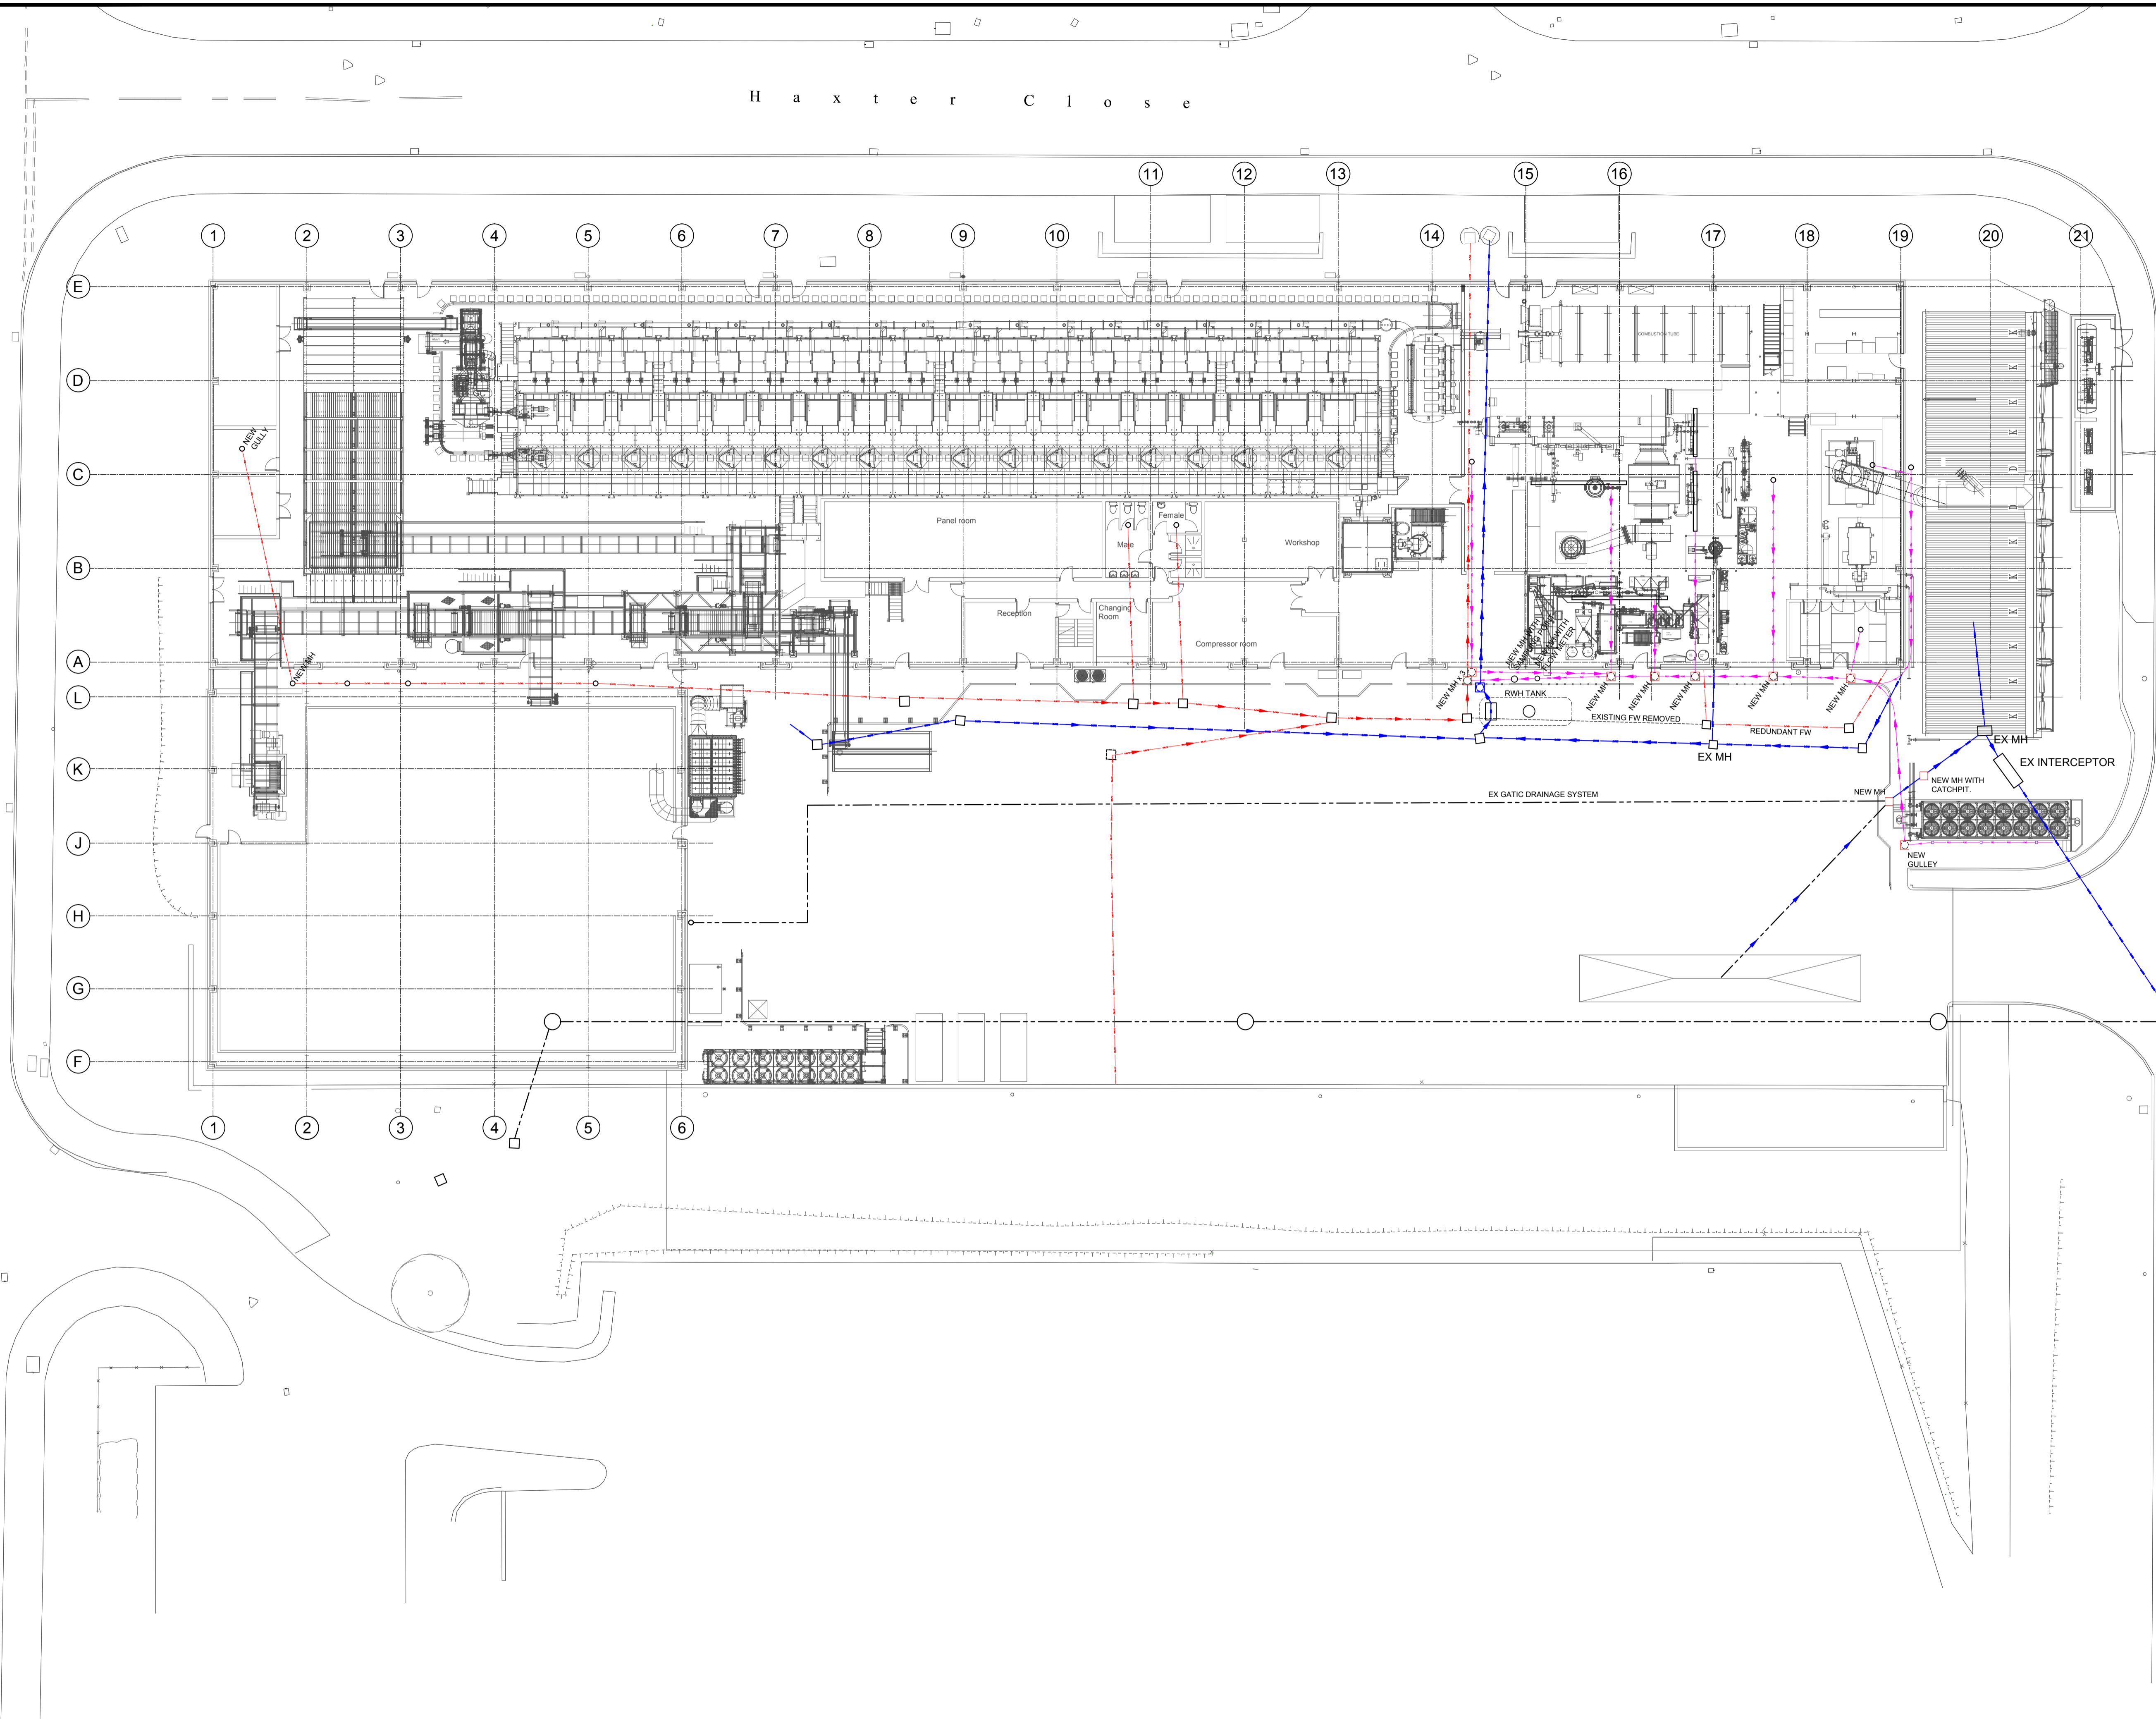


DO NOT Scale This Drawing
Dimensions to be checked on Site.

1. Do not scale, check all dimensions and details before commencement.
2. IF IN DOUBT ASK.
3. This drawing to be read in conjunction with all other relevant Contract Documents.

- FW SHOWN RED
- SW SHOWN BLUE
- PW SHOWN MAGENTA

Issue	SEC	Approved	Date	APPROVED FOR ISSUE	Revisions
			06.06.13		

INFORMATION

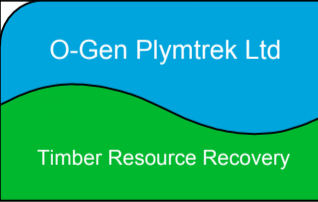Client: 
 Project: O-Gen Plymtrek
 Waste To Energy Plant
 1 Belliver Way
 Roborough, Plymouth

Drawing Title: DRAINAGE LAYOUT PLAN
 SHOWING AS BUILT FW, SW
 AND PROCESS DRAINAGE
 ROUTES



Drawn Date: 29.04.13 Drawn by: SC
 Scale: 1:200 Approved by: CH on:

Drawing No: 4424-900-70 Rev: A