
 


Plymouth City Council		
Site:	Leachate Treatment Plant	
Project:	Management System	
Title:	Site Layout	
Drawing No.:	Date:	Scale:
LTP01	20.02.2021	1:1500 @ A4
Drawn by:	Leppitt Associates	

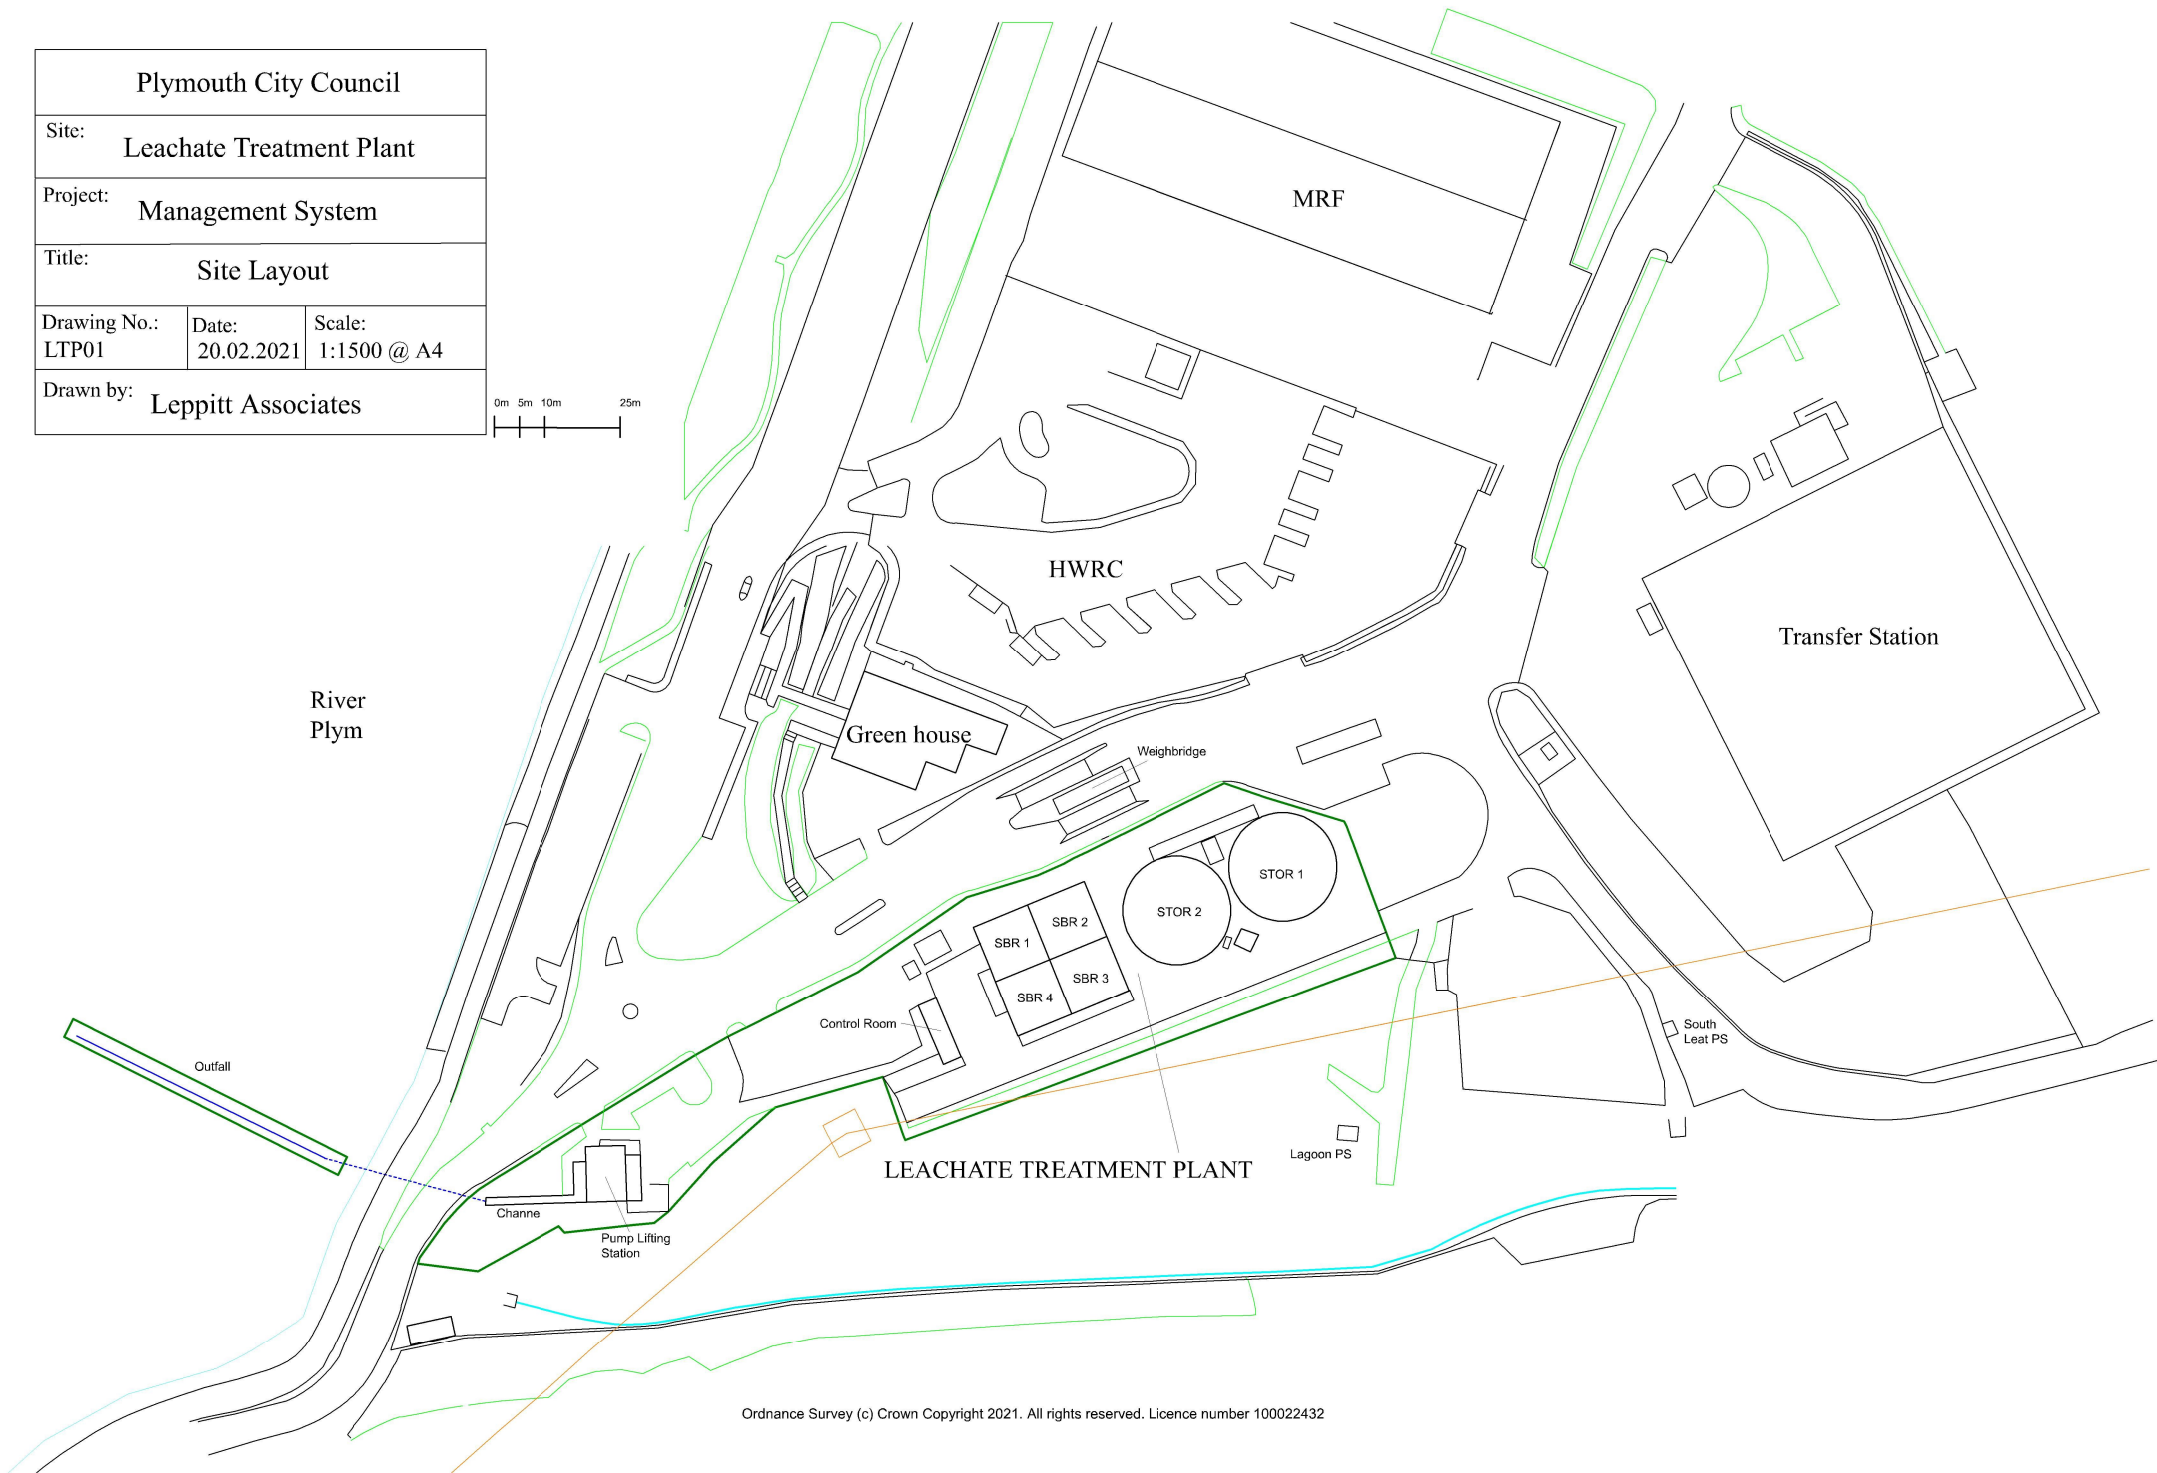

Plymouth City Council		
Site: Leachate Treatment Plant		
Project: Management System		
Title: Site Plan		
Drawing No.: LTP02	Date: 27.02.2021	Scale: 1:750 @ A4
Drawn by: Leppitt Associates		

