


Appendix B

SITE LAYOUT PLAN

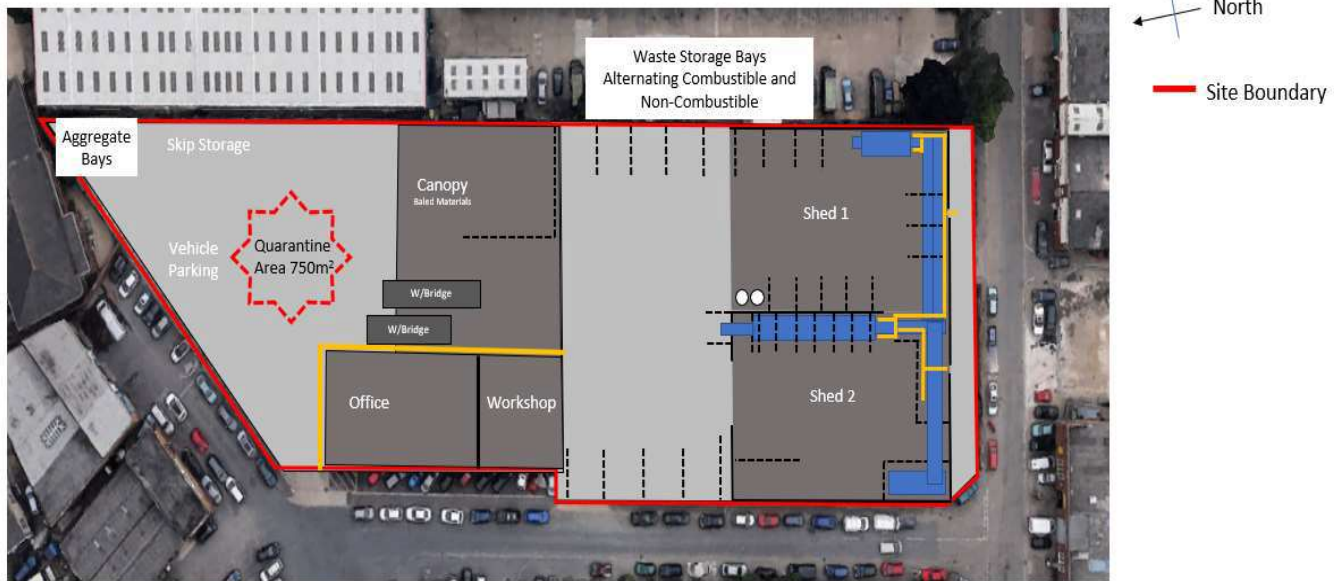


Reading Depot – Site Layout Plan



Public

Reading Depot – Layout and Material Bays

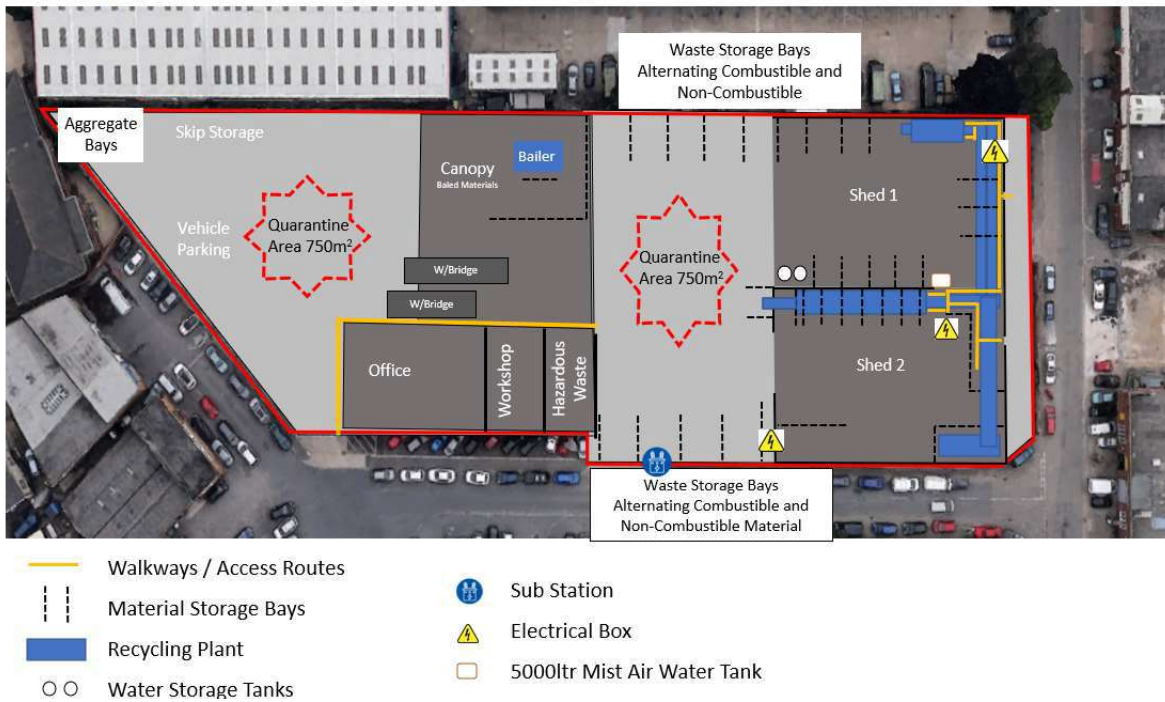





DO NOT SCALE

NOTES:
1. ALL DIMENSIONS ARE IN METRES UNLESS STATED OTHERWISE.
2. THIS DRAWING IS NOT TO BE REPRODUCED IN ANY FORM OR FORM WITHOUT CONSENT OF WSP. ALL COPYRIGHT RESERVED.
3. THIS DRAWING IS TO BE READ IN CONJUNCTION WITH THE WSP DRAINAGE STRATEGY TECHNICAL NOTE (70063883-SD)

KEY:

RED LINE BOUNDARY

PROPOSED SURFACE WATER PIPE AND CHAMBER

PROPOSED HYDROFRANK

PROPOSED SURFACE WATER CHANNEL DRAIN

EXISTING RAINWATER ROOF GUTTERING

ROOF RUNOFF CATCHMENT AREA

PROPOSED RAINWATER ROOF GUTTERING

PROPOSED RAINWATER ROOF GUTTERING

PROPOSED UNDERGROUND RAINWATER PIPE AND CHAMBER

OFF THE UNDERGROUND RAINWATER STORAGE TANK (NOT PROPOSED FROM RECHT-STATION)

PROPOSED PUMPING STATION

PROPOSED RISING MAIN TO SPILLWAY

PROPOSED CONTROL PANEL FOR PUMPING STATION AND WATER QUALITY TREATMENT

PROPOSED REINFORCED PIPE

PROPOSED PERMEABLE CARPARKING AND SURFACE ATTENUATION

DIRECTION OF SURFACE WATER RUNOFF

PROPOSED KERB

PROJ	DATE/ISSUE	NO	DESCRIPTION - FOR PLANNING	JS	CP
PROJ	DATE/ISSUE	NO	REQUEST FOR INFORMATION	JS	CP
NO	DATE	NO	DESCRIPTION	DM	WSP

SD - WORK IN PROGRESS

wsp

Worthington House, Baring Way, Basingstoke, RG21 4AL, UK
T: +44 (0) 1256 318 800, F: +44 (0) 1256 318 700
WSP.COM


COLLAB LTD

WASTE RECYCLING CENTRE EXPANSION

DRAINAGE STRATEGY
RAINWATER AND SURFACE WATER

SCALE 1:200
PROJECT NO. 70063883
DESIGNED BY WSP
CHECKED BY WSP
DATE 18/05/22
DRAWING NO. 70063883-WSO-XX-SKETCH-DR
P02

© WSP UK Ltd

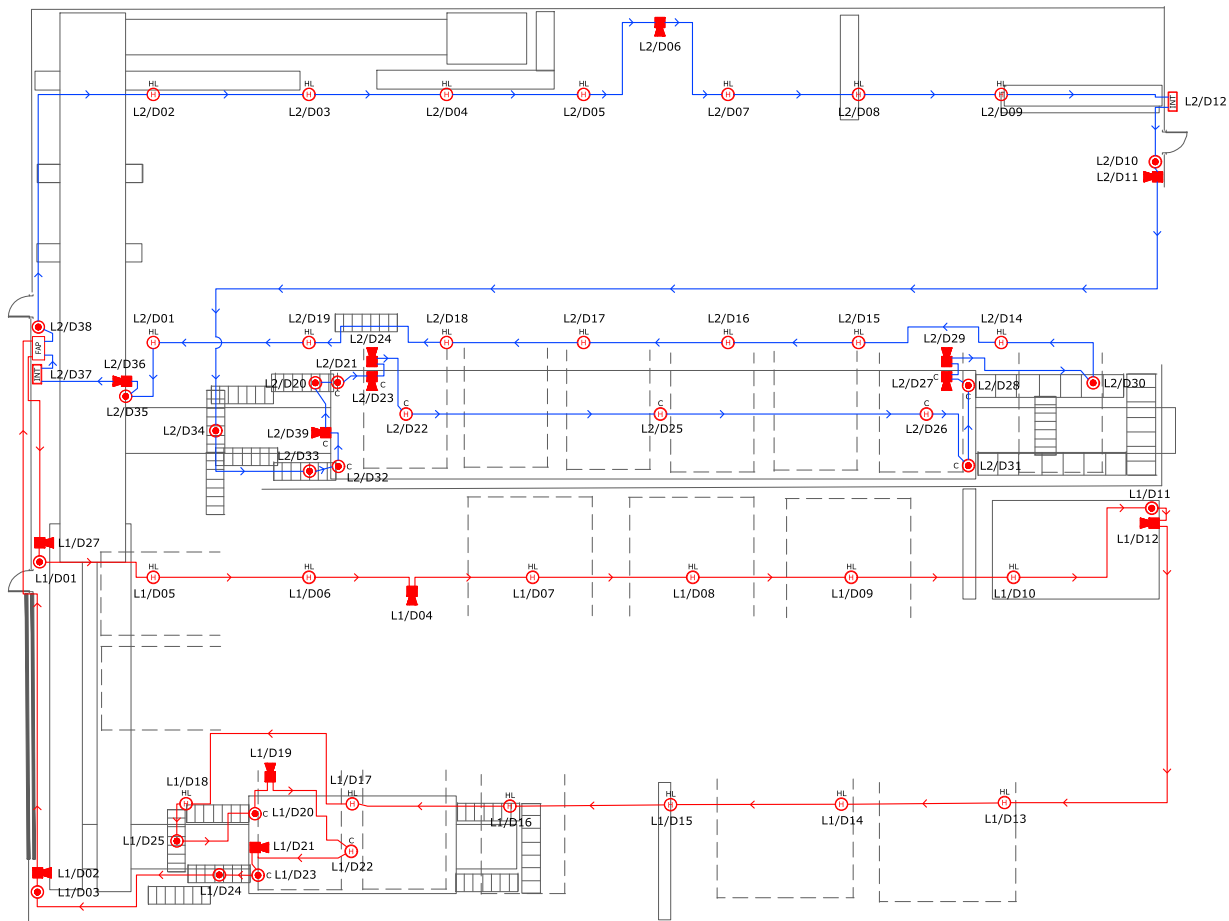


LEGEND		
	FAP	Fire Alarm Control Panel
	MCP	Manual Call Point
	HL	Heat Detector
		Wall Mounted Sounder
	INT	Fire Alarm Interface Unit
	HL	Denotes High level
	C	Denotes that device is within cabin
		Wire Loop 1
		Wire Loop 2

NOTES		
1.	Do not scale from this drawing.	
2.	System designed and installed to BS5836-1:2017, Category L2.	
3.	All cable PP20 1.5mm unless otherwise stated.	
4.	All device locations and cable route are indicative.	

DRAWING STATUS		
Rev.	Date	Description
AF	07/06/2023	AS FITTED

AS FITTED Andover Fire and Security Unit 3, Focus 303 Business Centre, Focus Way, Waterside Business Park, Andover, SP10 5NY Tel: 01264 324891 email: sales@andoverfireandsecurity.co.uk		
Client:	R COLLARD, READING	
Project:	FIRE ALARM	
Drawing Title:	FIRE ALARM LAYOUT	
Drawn:	dy	Checked: AFS
Date:	07/06/2023	Scale: NTS @ A3
Dwg No:	AFS-RCOLLARD-FA	Rev: AF

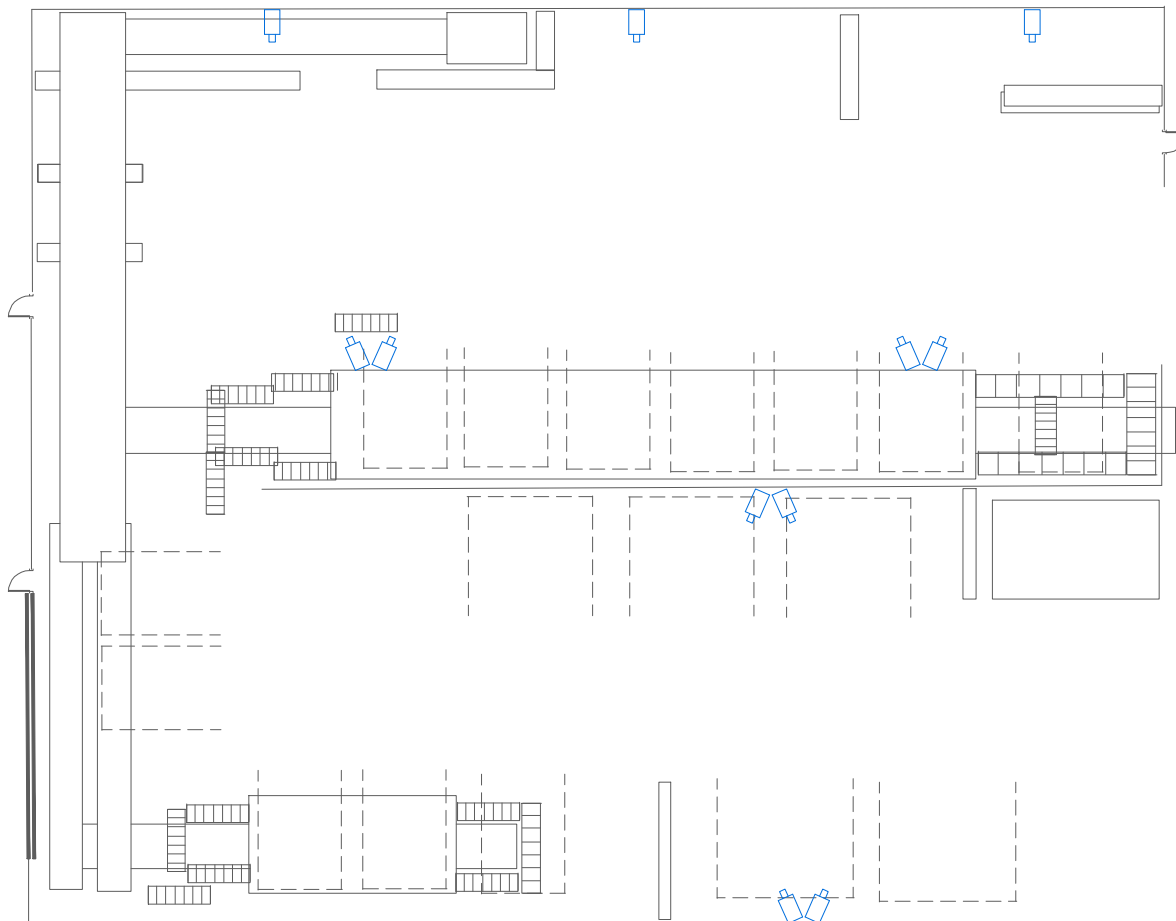

LEGEND		
	Thermal Bullet Camera	

NOTES		
1. Do not scale from this drawing.		

Rev.	Date	Description
AF	21/06/2023	AS FITTED

DRAWING STATUS: **AS FITTED**



Andover Fire and Security
Unit 3,
Focus 303 Business Centre,
Focus Way,
Waterside Business Park,
Andover
SP10 5NY
Tel: 01264 324891
email:
sales@andoverfireandsecurity.co.uk

Client: **R COLLARD, READING**

Project: **SECURITY**

Drawing Title: **CAMERA LAYOUT**

Drawn:	DY	Checked:	AFS
Date:	21/06/2023	Scale:	NTS @ A3
Orig No:	AFS-ROLLARD-CCTV		Rev: AF