

GENERAL NOTES:


1. All dimensions noted are in metres unless stated otherwise.
2. All levels to be above Ordnance Survey Datum defined levels (A.O.Dm) unless noted otherwise.
3. Do not scale from this drawing, if dimensions are not clear ask.
4. This document has been created in accordance with PDC Engineering Terms & Conditions along with the scope of works provided by the client to PDC Engineering. Any use of this document other than for its original purpose is prohibited, PDC Engineering accept no liability for any third party uses of this document.
5. PDC Engineering to be immediately notified of any suspected omissions or discrepancies.
6. This drawing is to be read in conjunction with all other relevant documents relating to the project:
 PDC Engineering drawings.
 • '29407/004 - Existing Site Layout'
 • '29407/006 - Proposed Site Plan'

LEGEND:

- EP.XX Existing Emission Point
- EP.XX Proposed Emission Point
- Permit Boundary (Area - 72,606.80m²/7.2607ha)
- Proposed Plant

EMISSION POINT KEY:

- EP.1 Odour Abatement Plant Outlet
- EP.2 CHP Engine Stack 1 (Standby)
- EP.3 CHP Engine Stack 2 (Duty)
- EP.4 Flare Stack 1 (1,000m³/h)
- EP.5 Flare Stack 2 (500m³/h)
- EP.6 Emergency Diesel Generator Stack
- EP.7 Carbon Dioxide Vent on Biogas Upgrader
- EP.8 Combined Lagoon Gas Carbon Filter Vent
- EP.9 PVRV 1 - Raw Waste Buffer Tank
- EP.10 PVRV 2 - Digester 1
- EP.11 PVRV 3 - Digester 2
- EP.12 PVRV 4 - Digester 3
- EP.13 PVRV 5 - Post Digester
- EP.14 PVRV 6 - Pasteuriser

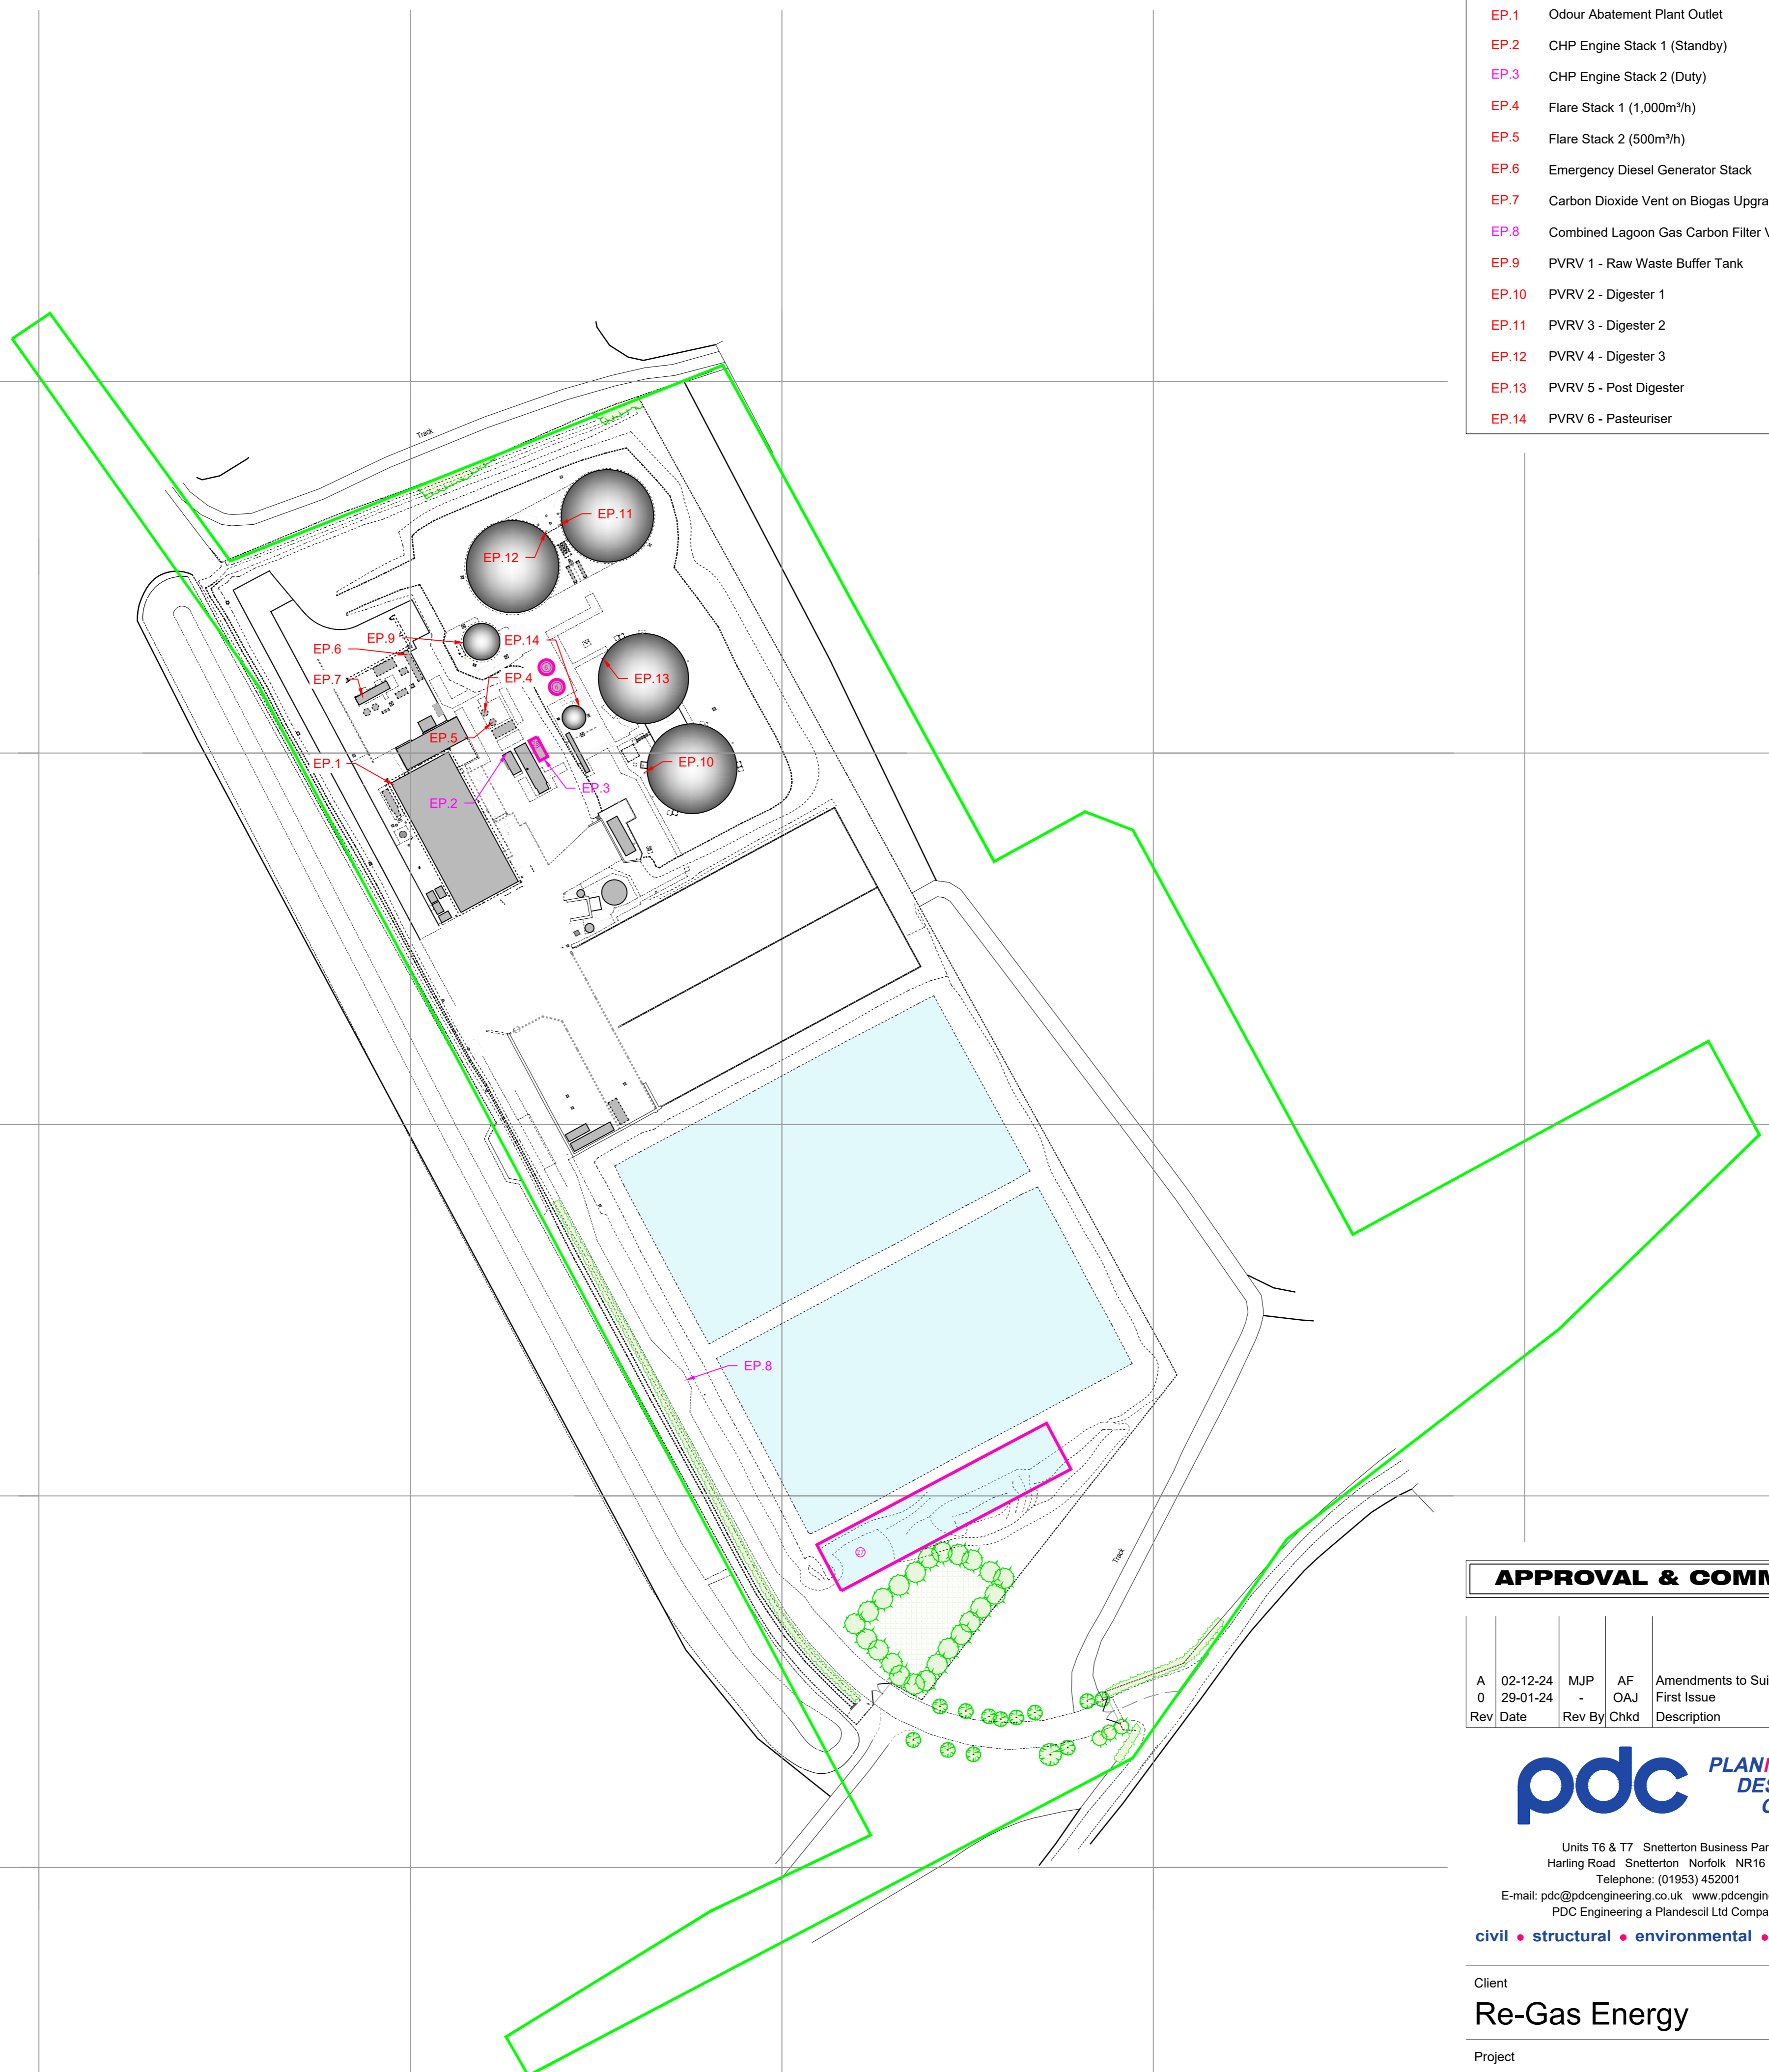

APPROVAL & COMMENT

Rev	Date	Rev By	Chkd	Description
A	02-12-24	MJP	AF	Amendments to Suit Comments
0	29-01-24	-	OAJ	First Issue




Units T6 & T7 Snetterton Business Park
 Harling Road Snetterton Norfolk NR16 2JU
 Telephone: (01953) 452001
 E-mail: pdc@pdcengineering.co.uk www.pdcengineering.co.uk
 PDC Engineering a Plandescil Ltd Company
 civil • structural • environmental • surveying

Client
Re-Gas Energy

Project
Herriard Bio Power Plant
Bushywarren Lane, Herriard,
Basingstoke RG25 2NS

Drawing Title
Existing & Proposed Site
Emission & Permit Boundary Plan

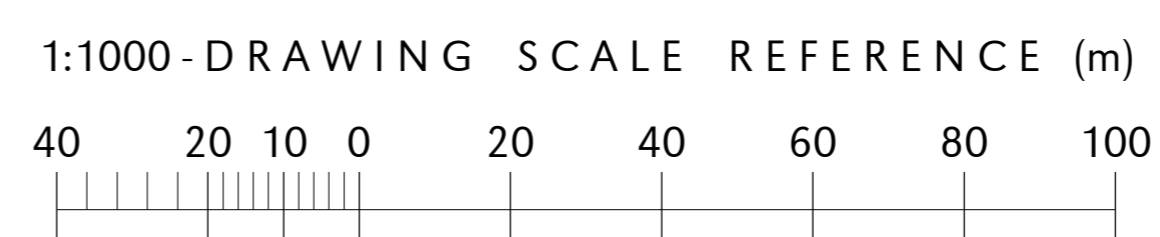

Scale	U.N.O.	Date	Drawn By
1:1000 (A1)		January 2024	JWD
Drawing No.	29407/005		Rev A