


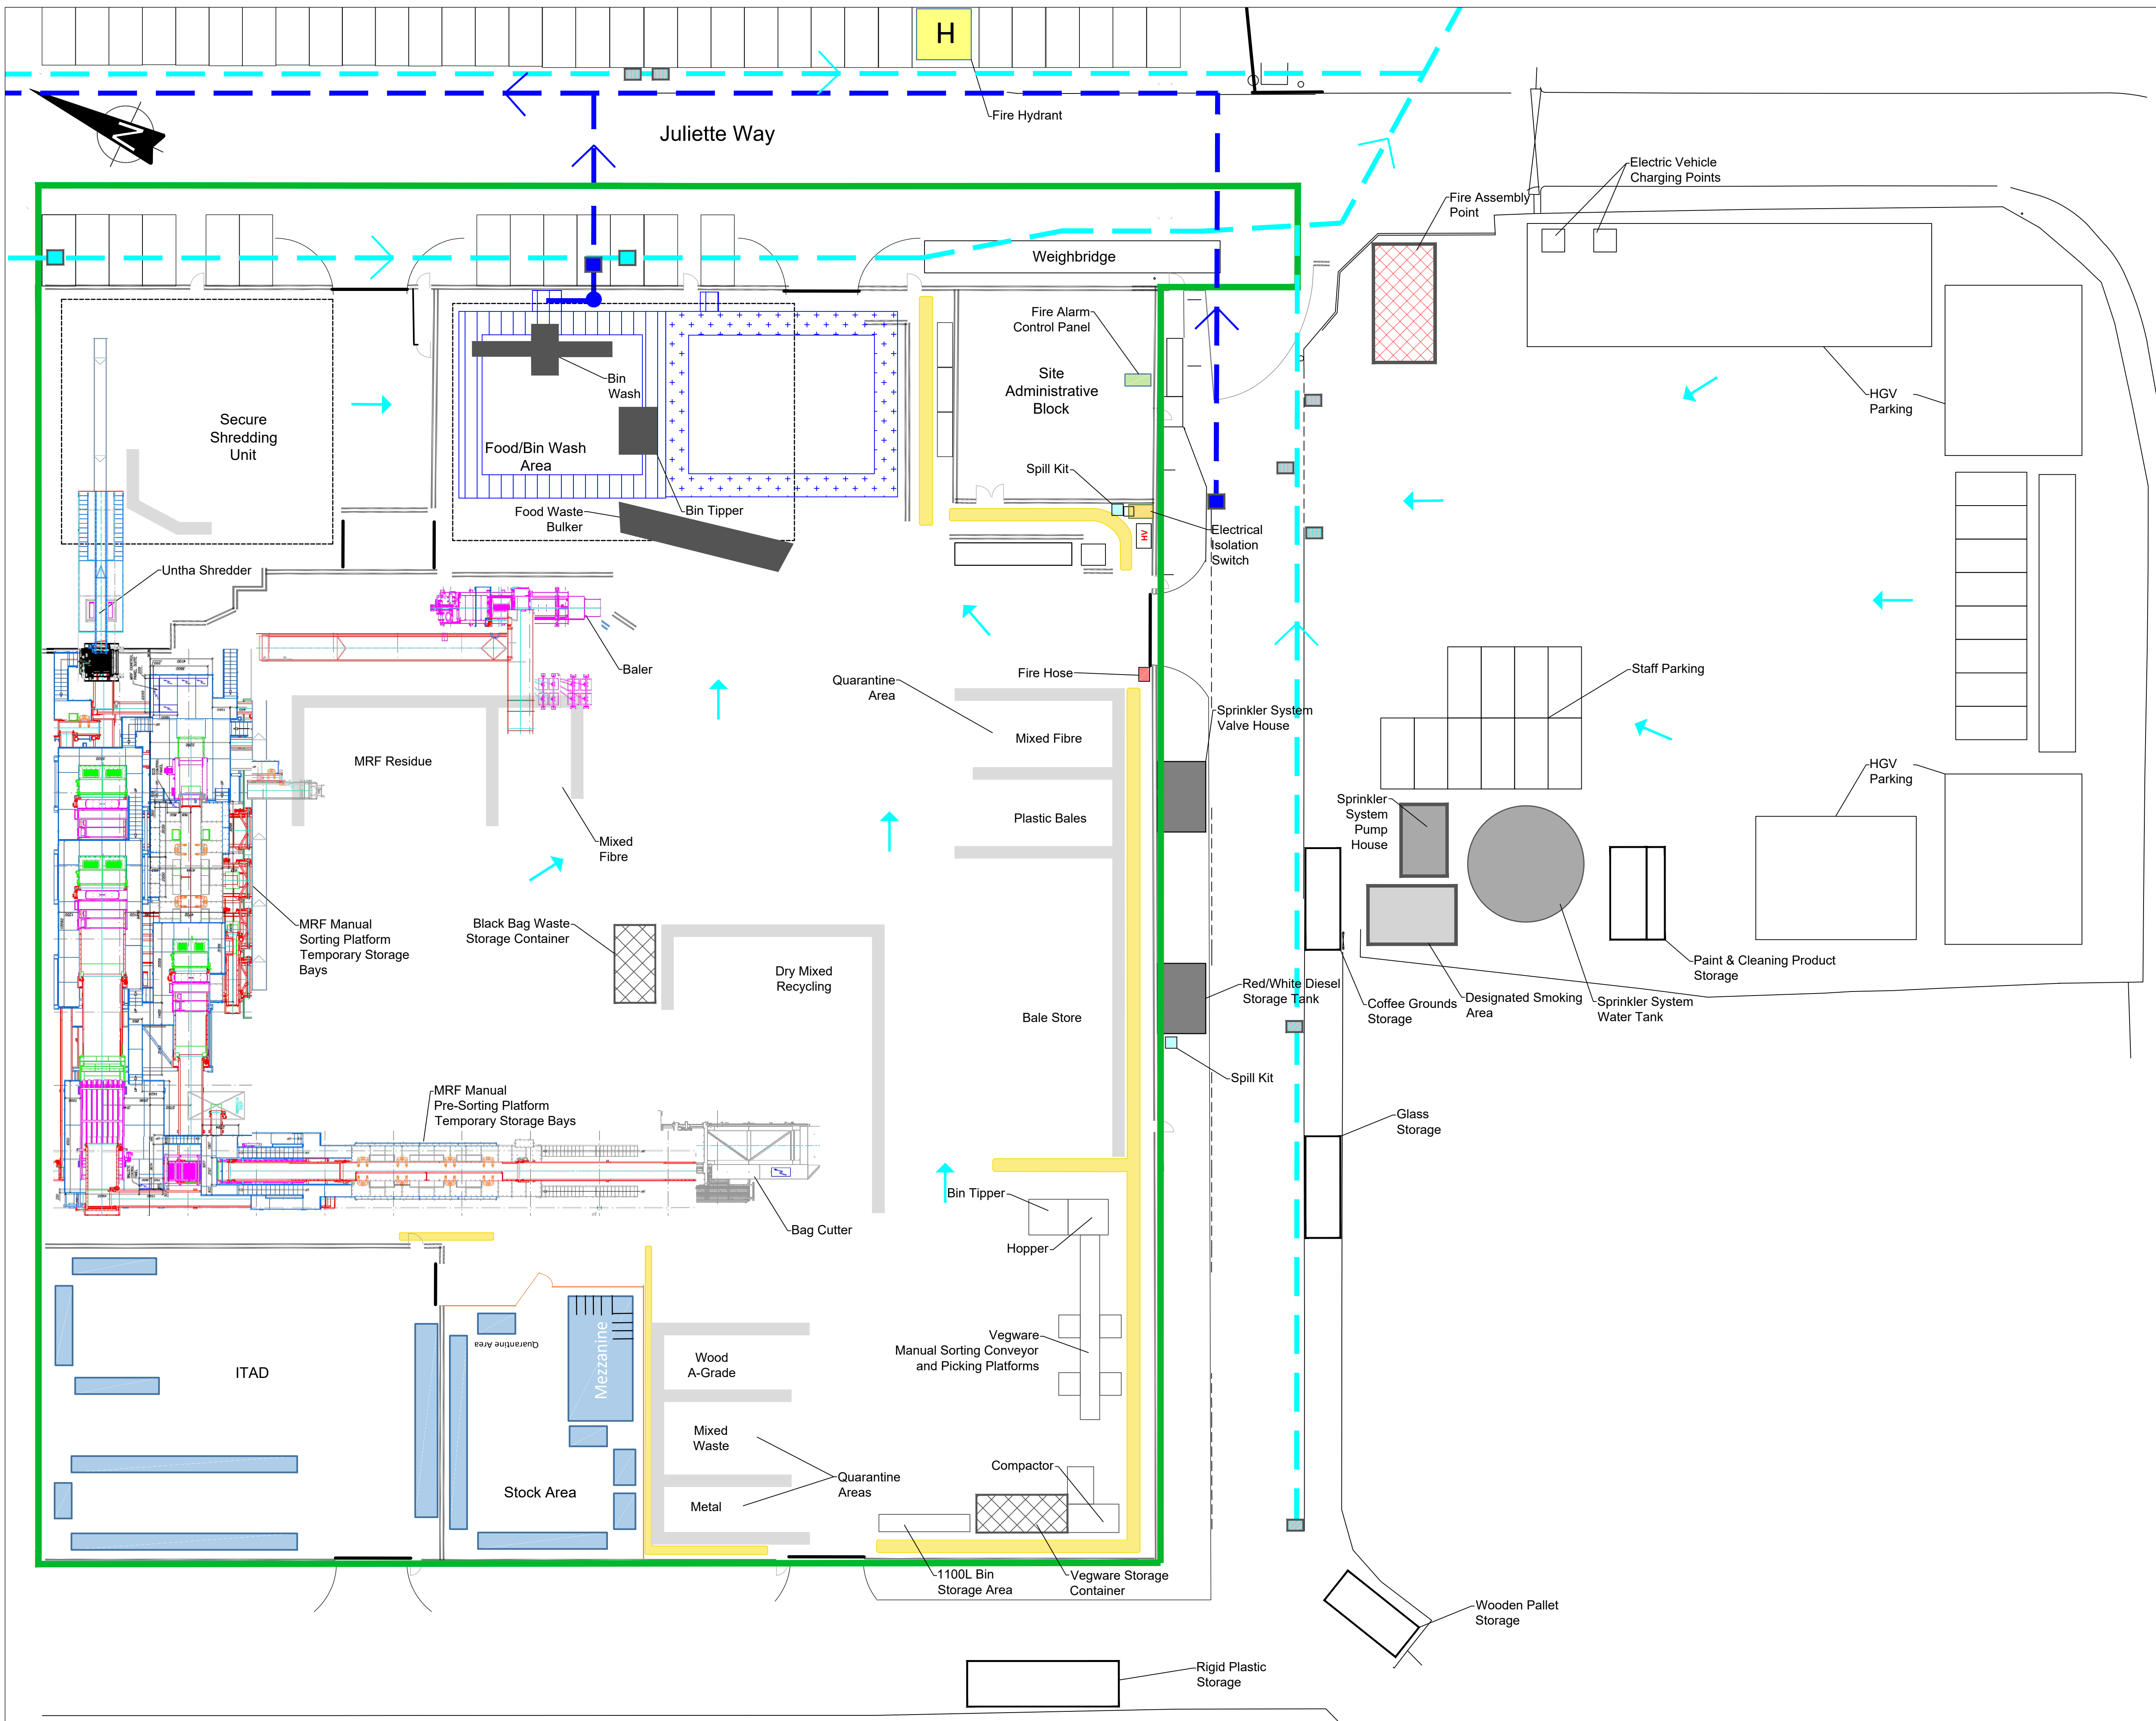

THIS INFORMATION IS CONFIDENTIAL AND THE PROPERTY OF SIRIUS. IT IS RELEASED ON CONDITION THAT NONE OF THE INFORMATION SHALL BE DISCLOSED TO ANY THIRD PARTY OR REPRODUCED IN WHOLE OR PART WITHOUT THE PRIOR CONSENT IN WRITING OF SIRIUS.

- KEY**
- ENVIRONMENTAL PERMIT BOUNDARY
 - SITE DRAINAGE GRATES
 - DIRECTION OF SURFACE WATER FLOW
 - INDICATIVE ROUTE OF FOUL WATER DRAINAGE PIPEWORK
 - INDICATIVE ROUTE OF SURFACE WATER DRAINAGE PIPEWORK
 - COVERED DRAINAGE GULLY
 - NON-COVERED DRAINAGE GULLY
 - CLOSED DRAIN COVER (FOUL WATER)
 - CLOSED DRAIN COVER (SURFACE WATER)
 - OPEN DRAIN COVER (SURFACE WATER)
 - KERB RAISED DRAIN (SURFACE WATER)

DRAFT

REV	DESCRIPTION	DATE	BY
-----	-------------	------	----

CLIENT

Recorra

Sirius Environmental

Office Suite 1, The Beacon Centre for Enterprise, Station Lane, Liphig, L24 9LQ, Ireland

JOB TITLE
PURFLEET MRF & WEEE ATF FIRE PREVENTION PLAN

DRAWING TITLE
SITE DRAINAGE PLAN

DRAWN	DATE	APPROVED	DATE
M.K	08/12/2021	D.T	08/12/2021
SCALE	SHEET	DRAWING NUMBER	REVISION
1:200	A1L	BPR1001/05/04	0