


COPY OF DRAWING FROM SET OF SHAPES

34A

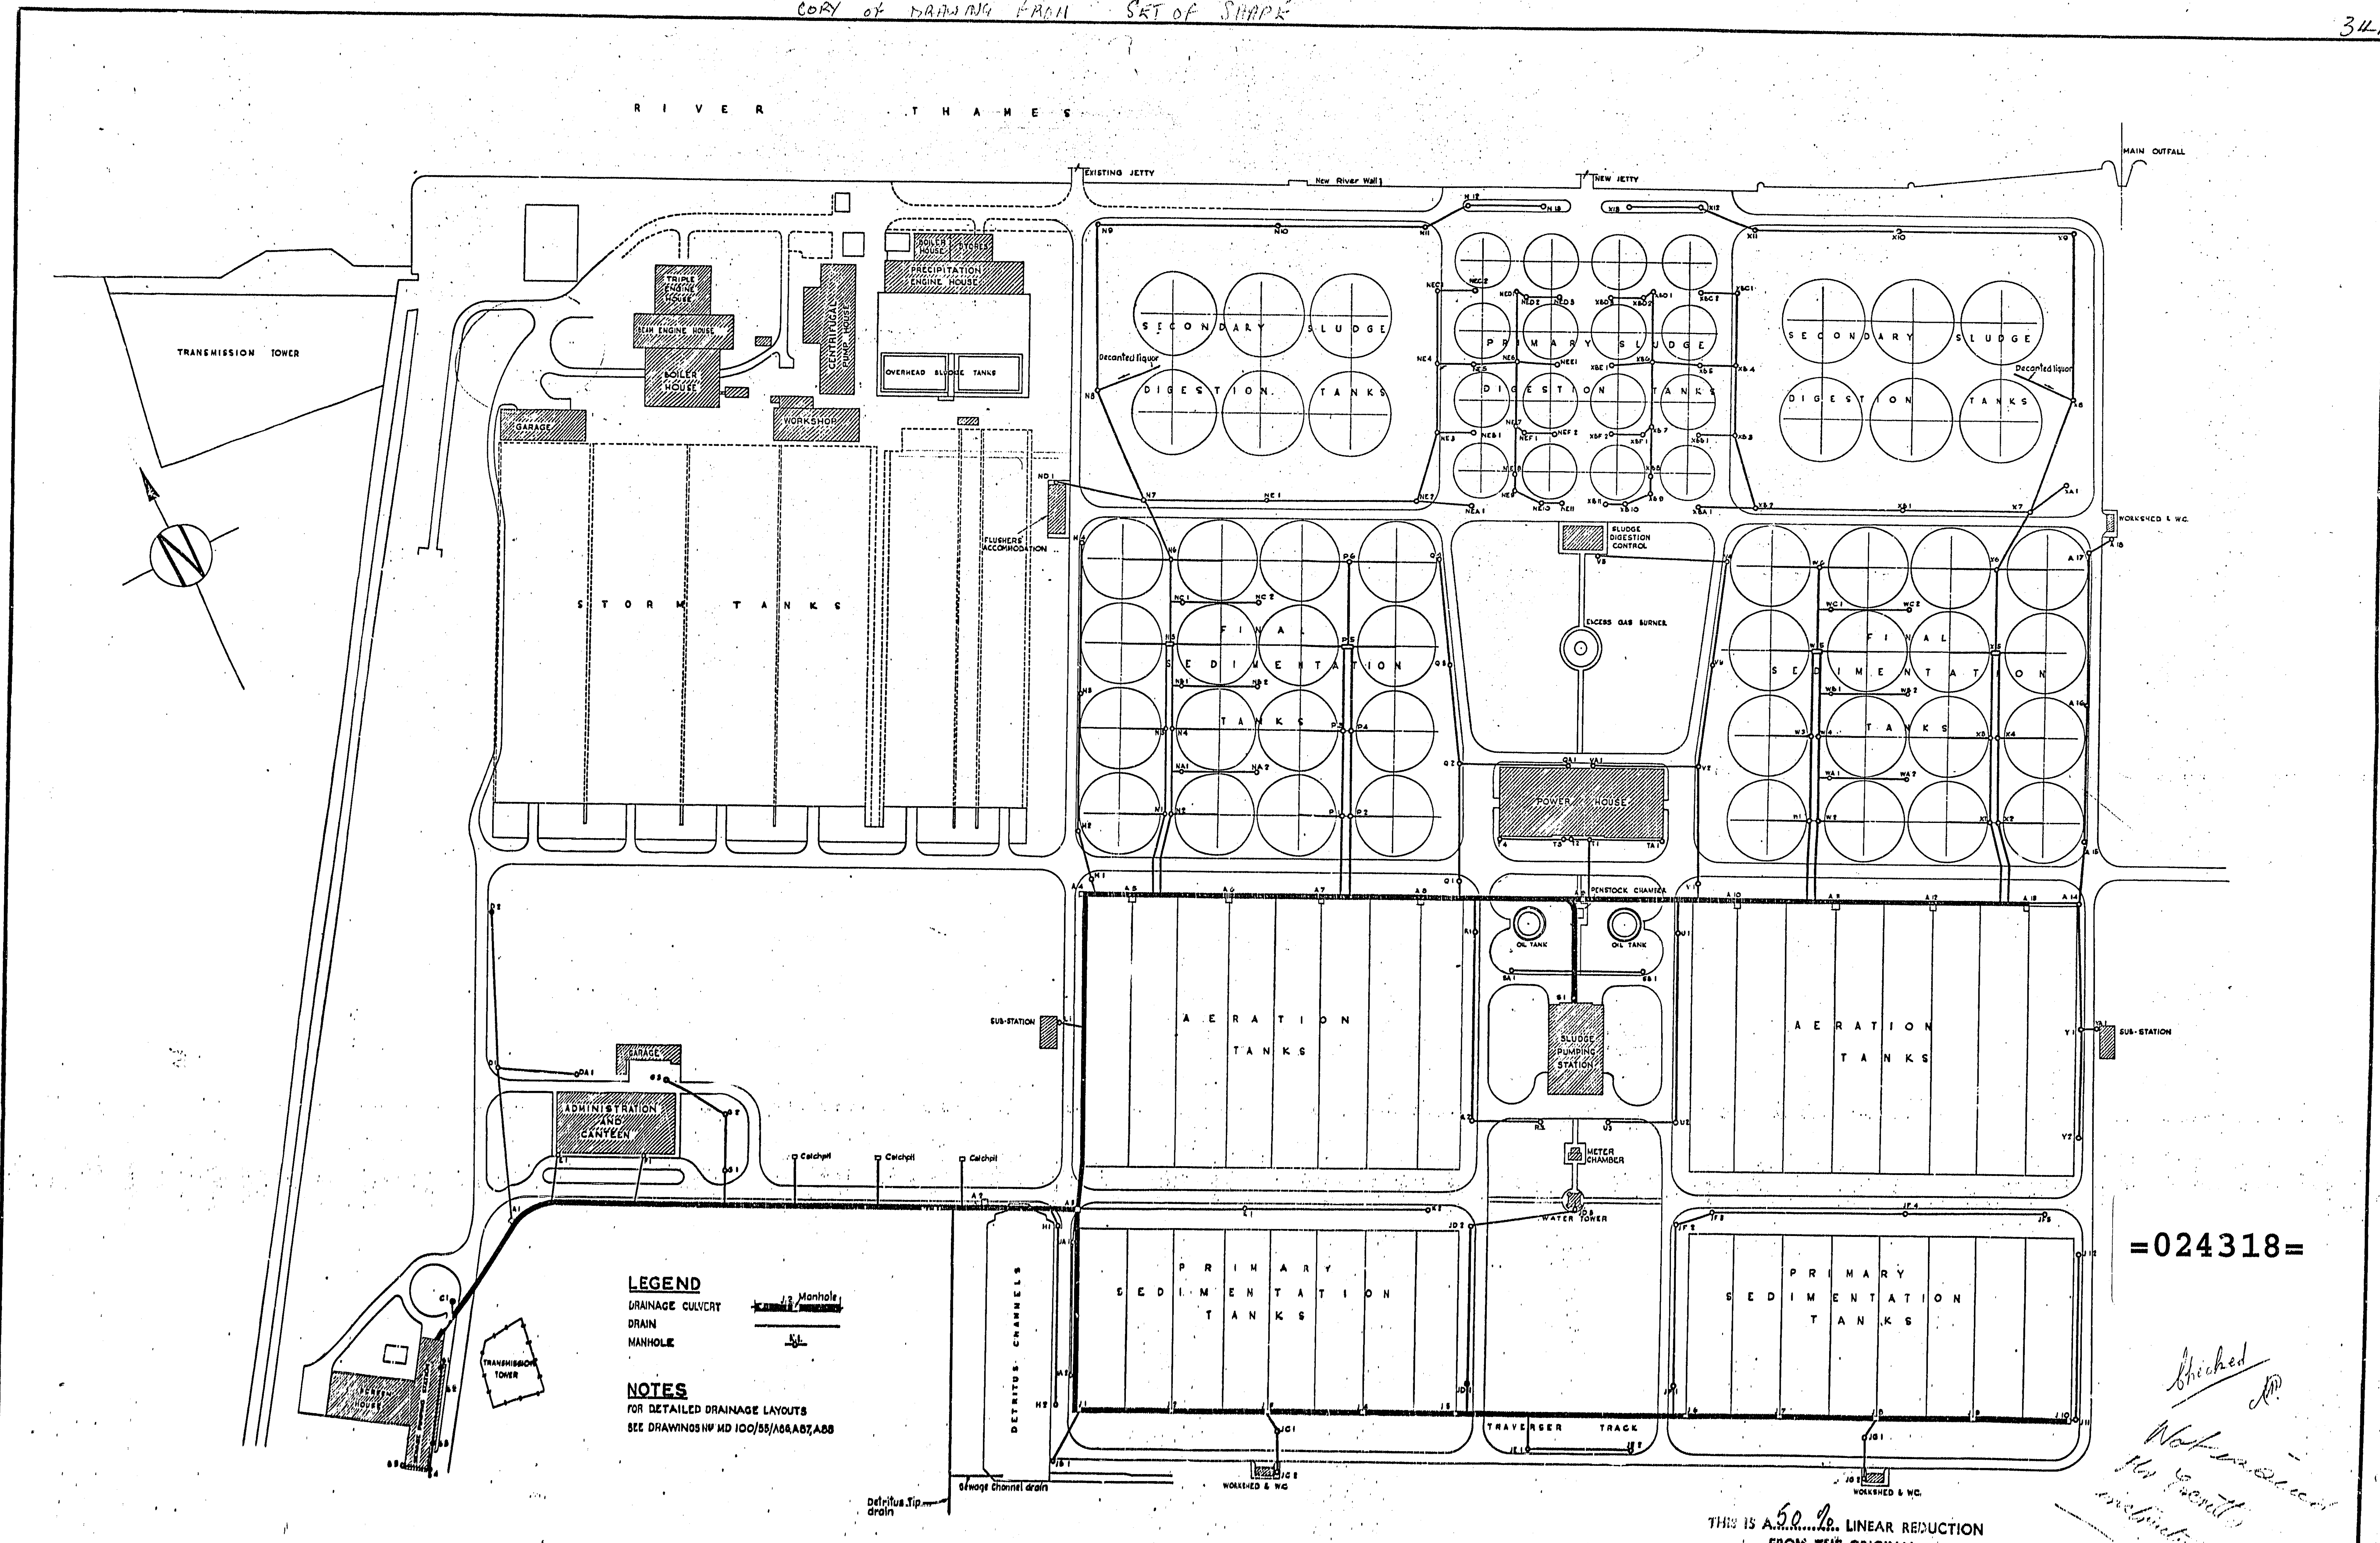

CHIEF ENGINEER'S
DEPARTMENT
MAIN DRAINAGE
DIVISION

LONDON COUNTY COUNCIL
SOUTHERN OUTFALL WORKS — DEVELOPMENT 1956

DRAINAGE LAYOUT

Amendments	Date	DATE 8-10-50	ADDITIONAL
		DRAWN BY G.H.	MD100/55
		TRACED BY H.G.	DRAWING
		CHECKED BY...	No A 36