




- NOTES:
- DRAWING FOR PLANNING PURPOSES ONLY
 - MAPPING IS ON ORDNANCE SURVEY TAKEN FROM ANS-RWB-XX-00G-DR-C-500-150-P11 INDICATIVE DRAINAGE LAYOUT DRAFT DWG
 - THE OFFSITE ROAD IS BASED ON THE PANATONNI OUTLINE PLANNING APPLICATION DRAWING. NO GUARANTEE IS GIVEN AS TO THE ACCURACY OR COMPLETENESS OF THE INFORMATION SHOWN.
 - ALL LEVELS ARE IN METERS ABOVE DATUM UNLESS STATED OTHERWISE.
 - ALL LANDSCAPE PROPOSALS SHALL BE DELIVERED IN DETAIL OF WHICH WILL BE INCLUDED IN THE CONSTRUCTION SPECIFICATION
 - DRAWING SHOULD BE READ IN COORDINATION WITH THE FOLLOWING DRAWINGS AND DOCUMENTS:
 - SLO1X0-SWE-EX-XX-DR-L-0001 LANDSCAPE GENERAL ARRANGEMENT PLAN (OVERVIEW)
 - SLO1X0-SWE-EX-XX-DR-L-0002 TO SLO1X0-SWE-EX-XX-DR-L-0003 LANDSCAPE GENERAL ARRANGEMENT PLANS SHEETS 1 TO 2
 - SLO1X0-SWE-ZZ-EX-DR-L-5000 TO SLO1X0-SWE-ZZ-EX-DR-L-5001 PLANTING PLAN SHEETS 1 TO 2
 - SLO1X0-SWE-EX-XX-DR-L-3000 TO 3002 LANDSCAPE SITE SECTIONS SHEETS 1 TO 3
 - SLO1X0-SWE-EX-XX-DR-C-0105 EXTERNAL AREAS PUBLIC SHARED CYCLEWAY AND FOOTPATH
 - SLO1X0-SWE-XX-XX-RP-Y-7001 ECOLOGICAL MITIGATION, COMPENSATION AND ENHANCEMENT STRATEGY
 - SLO1X0-RED-EX-XX-RP-E-5000 EXTERNAL LIGHTING STRATEGY
 - DESIGN AND ACCESS STATEMENT

- FOR FURTHER DETAILS REFER TO DRAWING LON1X0-SWE-EX-XX-DR-L-0003
- RESERVED MATTERS BOUNDARY
 - EXTENTS OF SITE OWNERSHIP
 - EXISTING TREES RETAINED
 - PRIMARY PAVING AREAS (DIRECTION OF MATCH DENOTES DIRECTION OF PAVING PATTERN)
 - PRIMARY PAVING SEATING AREAS (DIRECTION OF MATCH DENOTES DIRECTION OF PAVING PATTERN)
 - SECONDARY PAVING (DIRECTION OF MATCH DENOTES DIRECTION OF PAVING PATTERN)
 - BLOCK PAVING TO PARKING SPACES
 - PERMEABLE BLOCK PAVING TO PARKING SPACES
 - PERMEABLE BLOCK PAVING TO FRONT ENTRANCE
 - DECORATIVE GRAVEL
 - ASPHALT FOOTPATH - REFER TO CIVIL ENGINEER'S SPECIFICATION
 - ASPHALT ROAD - REFER TO CIVIL ENGINEER'S SPECIFICATION
 - CONCRETE SURFACE - REFER TO CIVIL ENGINEER'S SPECIFICATION
 - TACTILE PAVING
 - MODULAR CUBE SEATING
 - BENCH SEATING
 - PICNIC TABLE
 - LITTER BIN
 - CYCLE STAND
 - VEHICLE BOLLARD
 - PEDESTRIAN CYCLE LINK
 - VEHICLE DETERRENT BOLLARD
 - REMOVABLE VEHICLE BOLLARD
 - PEDESTRIAN CYCLE LINK
 - REFLECTIVE OBJECT
 - TIMBER FENCE
 - EXISTING RAILINGS REPAIRED/REINSTATED
 - OPEN MESH STEEL PANEL FENCING
 - OPEN MESH STEEL PANEL SINGLE LEAF GATE
 - OPEN MESH STEEL PANEL DOUBLE LEAF GATE
 - TREES
 - SHRUB/HERBACEOUS PLANTING
 - NATIVE HEDGEROW
 - HORNBEAM HEDGEROW
 - NATIVE SCRUB
 - AMENITY GRASS
 - NATIVE SPECIES GRASSLAND
 - FLOWERING LAWN - APPROX. 1265m²
 - BAT BOX
 - LOG PILES
 - INVERTEBRATE POST
 - BEE HOTEL
 - SWIFT TOWER
 - 3M HIGH WELD MESH SECURITY FENCE WITH BRISTLE BEAM - REFER TO SECURITY CONSULTANT DRAWINGS AND SPECIFICATION
 - PASS8 BOLLARD - REFER TO SECURITY CONSULTANT'S DRAWINGS AND SPECIFICATION
 - STRUCTURAL SLAB REFER TO STRUCTURAL ENGINEER'S DRAWINGS AND SPECIFICATION

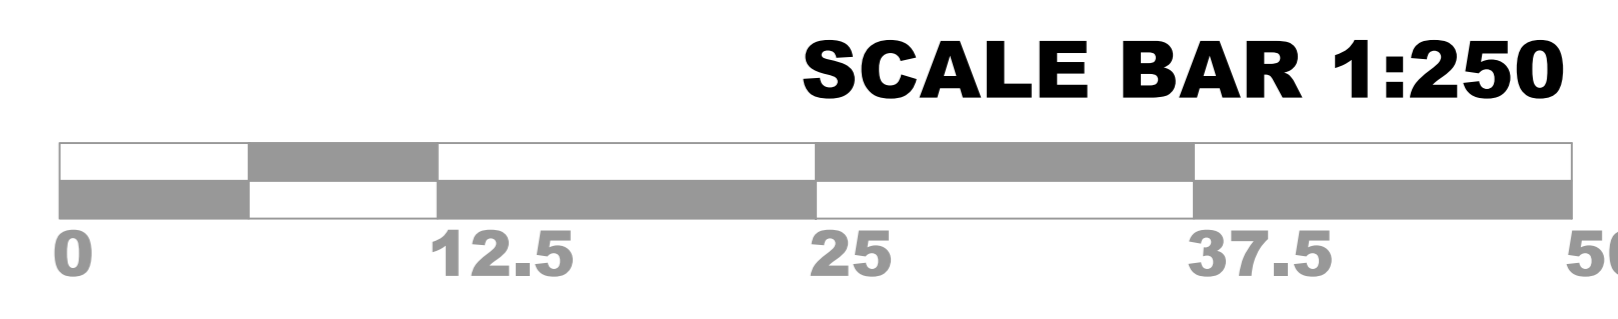

Yondr is the trading name for Yondr Group Limited, which is registered in the UK under company number 12000046, with its registered office 7th floor, 33 Aldgate High Street, London EC3N 1AG.

Yondr Group Limited is a subsidiary of Yondr Group Holdings B.V., company number 000041128699, and whose registered office is at Barbara Stozzelaar 101, 1063RN Amsterdam.

All intellectual property rights (including, without limitation, all copyright and design rights) subsisting in the drawing and related information belongs to Yondr Group Limited.

This drawing is to be read in conjunction with all related consultants drawings and any other relevant information. Do not scale from this drawing. All dimensions in millimetres unless otherwise stated. All dimensions to be verified on site prior to the commencement of any work or the production of any shop drawing. All discrepancies to be reported to Yondr immediately.

IPD PARTNERS

Jones Engineering

SCOTT BROWNRIGG

TEECOM

CUNDALL

ISg

RED

SWECO

SWECO

ORIGINATOR

KEY PLAN:

PN3	ISSUED FOR PLANNING	JR	SH	26/09/22
PN2	AMENDED IN LINE WITH SBC COMMENTS	ED	RM	20/07/21
PN1	ISSUED FOR PLANNING	DM	RM	09/04/21
Rev	Description	Dim	Chk	Date

CAMPUS NUMBER & NAME
SLO1 Slough One

PROJECT
SLO1X0 Slough One Phase One

DRAWING TITLE
LANDSCAPE GENERAL ARRANGEMENT PLAN SHEET 1 OF 2

STATUS CODE:
S0 FOR PLANNING

STAGE:
STAGE 2

DRAWING NUMBER:
SLO1X0-SWE-EX-XX-DR-L-0002

SCALE 1:250 A0

REV P03

www.yondr.com