


SWINDON STW

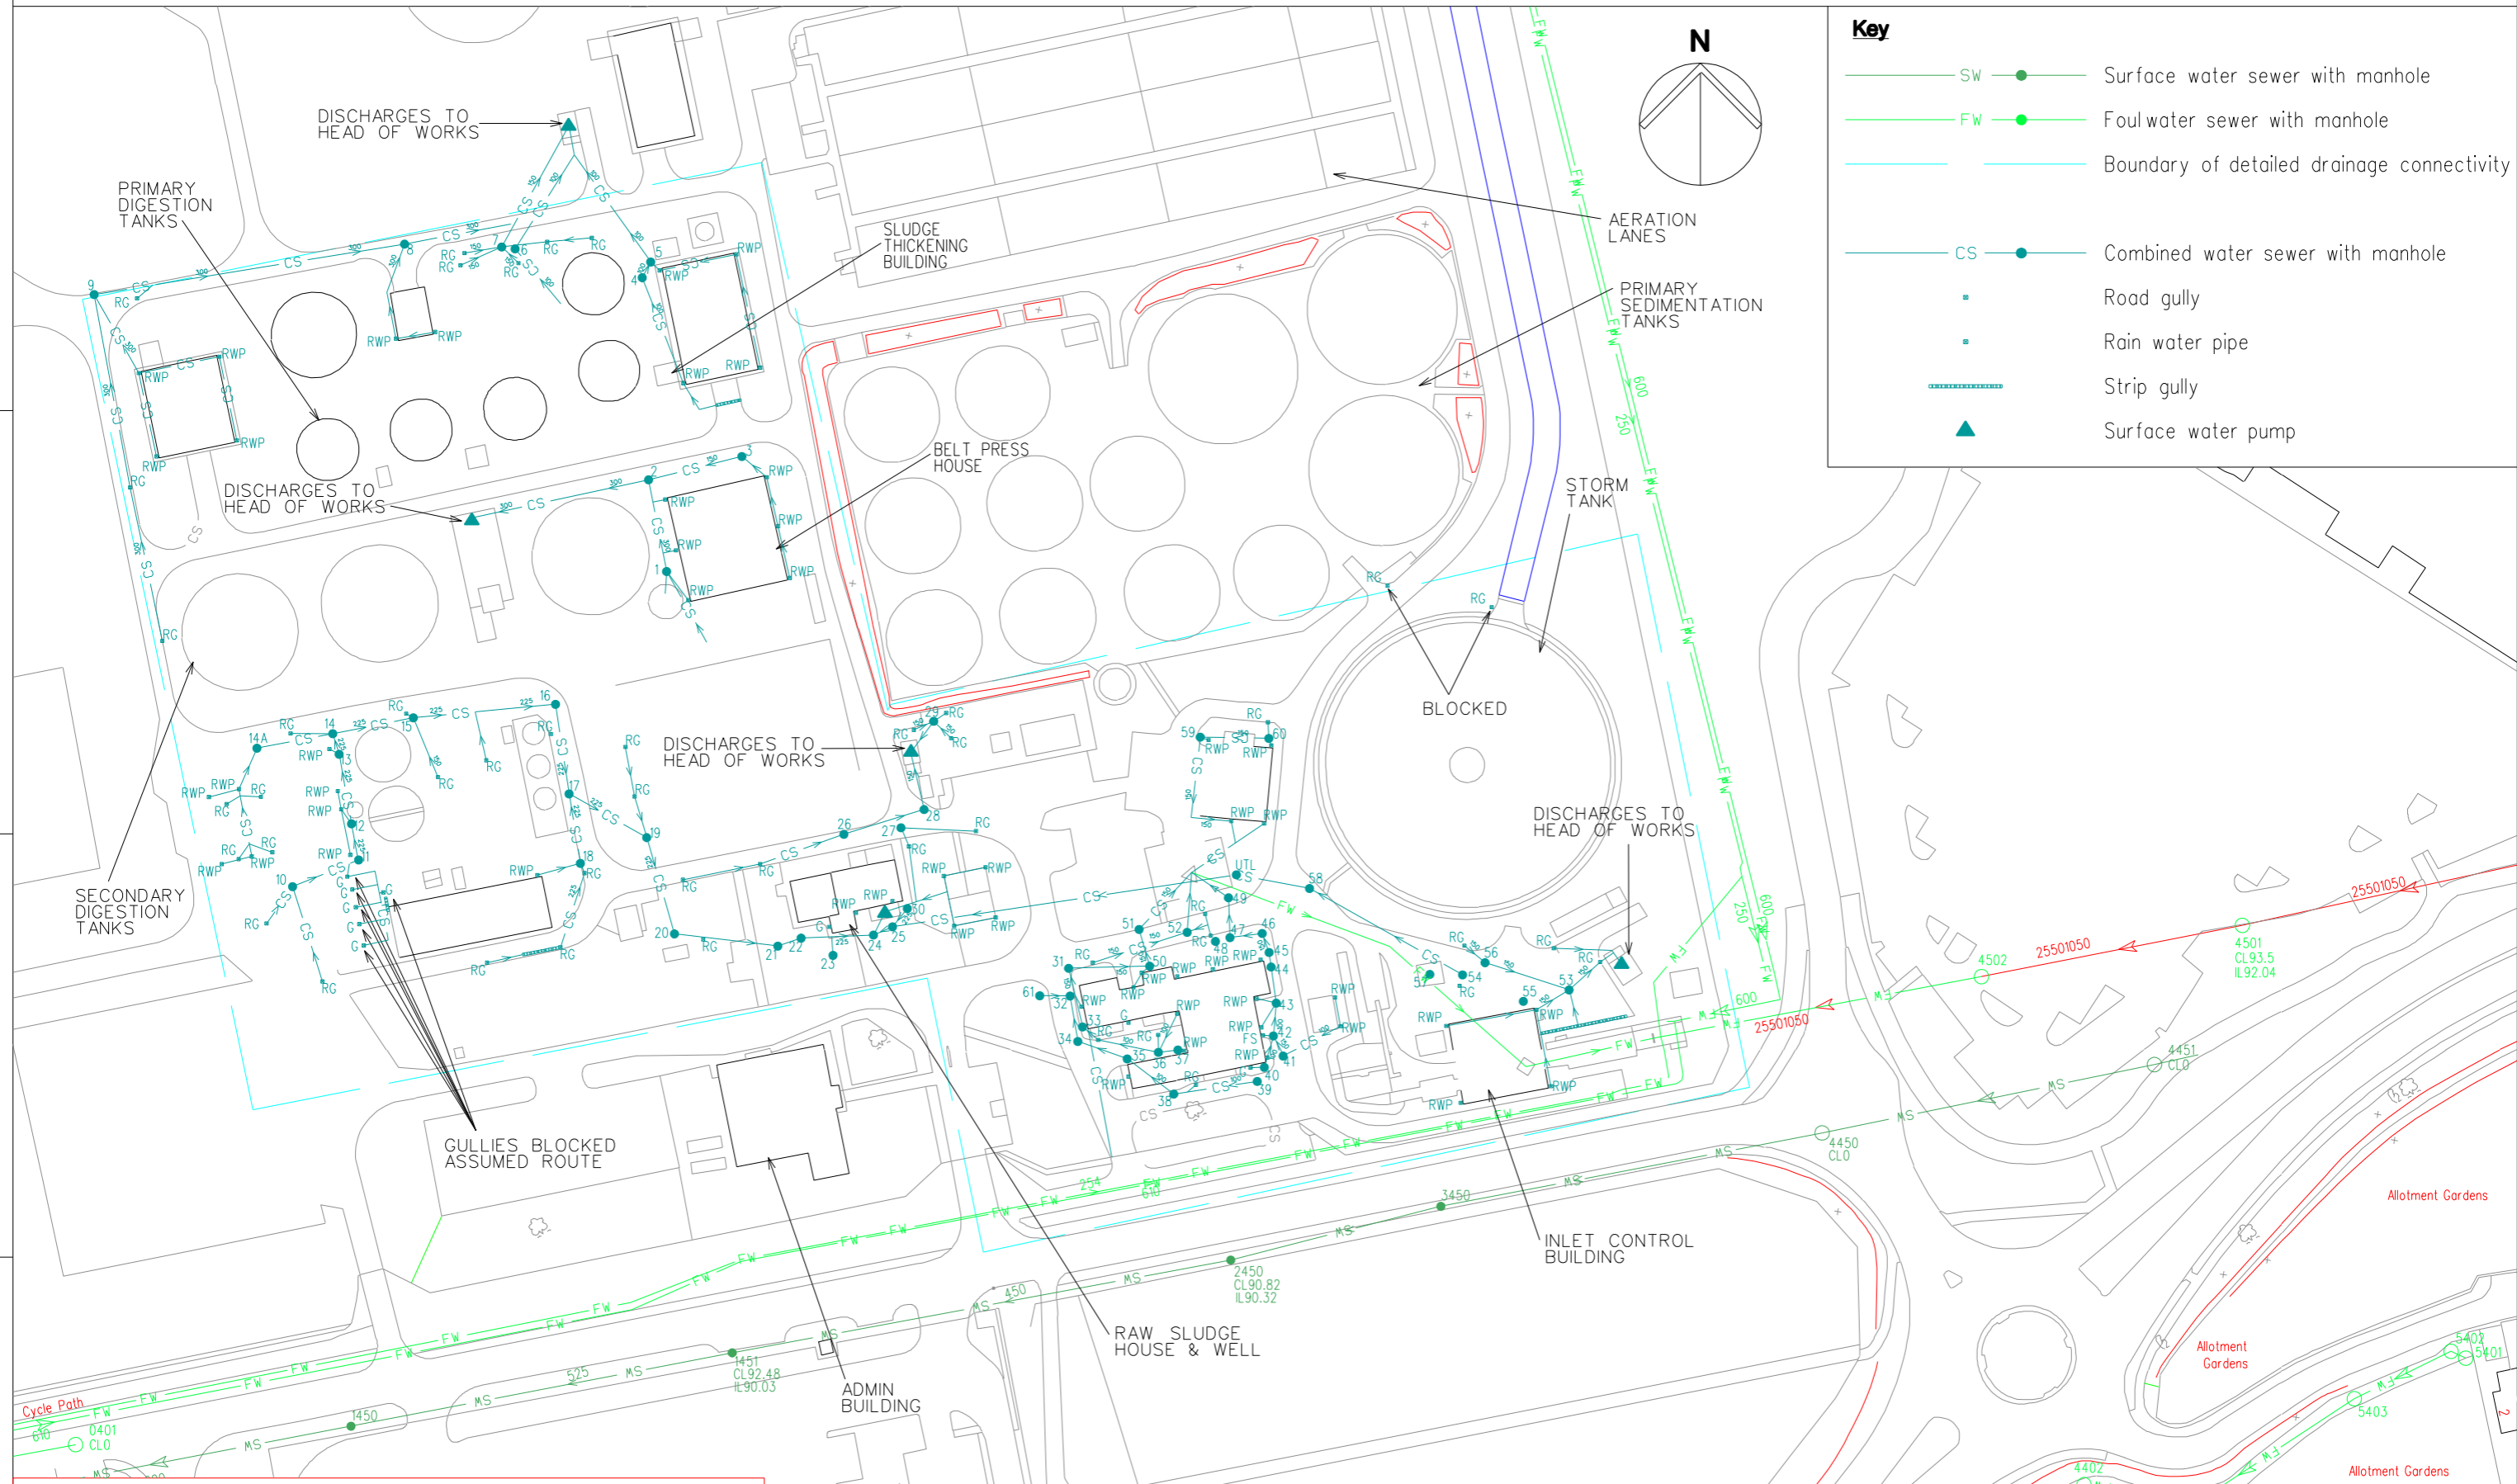

Key

- SW —●— Surface water sewer with manhole
- FW —●— Foulwater sewer with manhole
- — Boundary of detailed drainage connectivity
- CS —●— Combined water sewer with manhole
- Road gully
- - - Rain water pipe
- Strip gully
- ▲ Surface water pump

UNCONTROLLED WHEN PRINTED
DRAWING UNAPPROVED BY OPERATIONS

© COPYRIGHT : UNAUTHORISED REPRODUCTION PROHIBITED. BASED ON THE ORDNANCE SURVEY MAP WITH THE SANCTION OF H.M. STATIONERY OFFICE - LICENCE No. 100019345.

A	FIRST ISSUE - CREATED FROM WERM ACD	JM	DS	NC	31/03/2010
Iss	Description	Drawn	Chkd	Appd	Date

TECHNICAL INFORMATION
 Clearwater Court
 Vastern Road
 Reading RG1 8DB

Drawing Title:
DRAINAGE PLAN

Location / Town:
RODBOURNE

Location Code:
SWINS1ZZ

OS Reference:
SU131854

Drawing No.:
SWINS1ZZ-DPL-001

Scale:
1:1000

Sheet Size:
A3

Rev:
A