
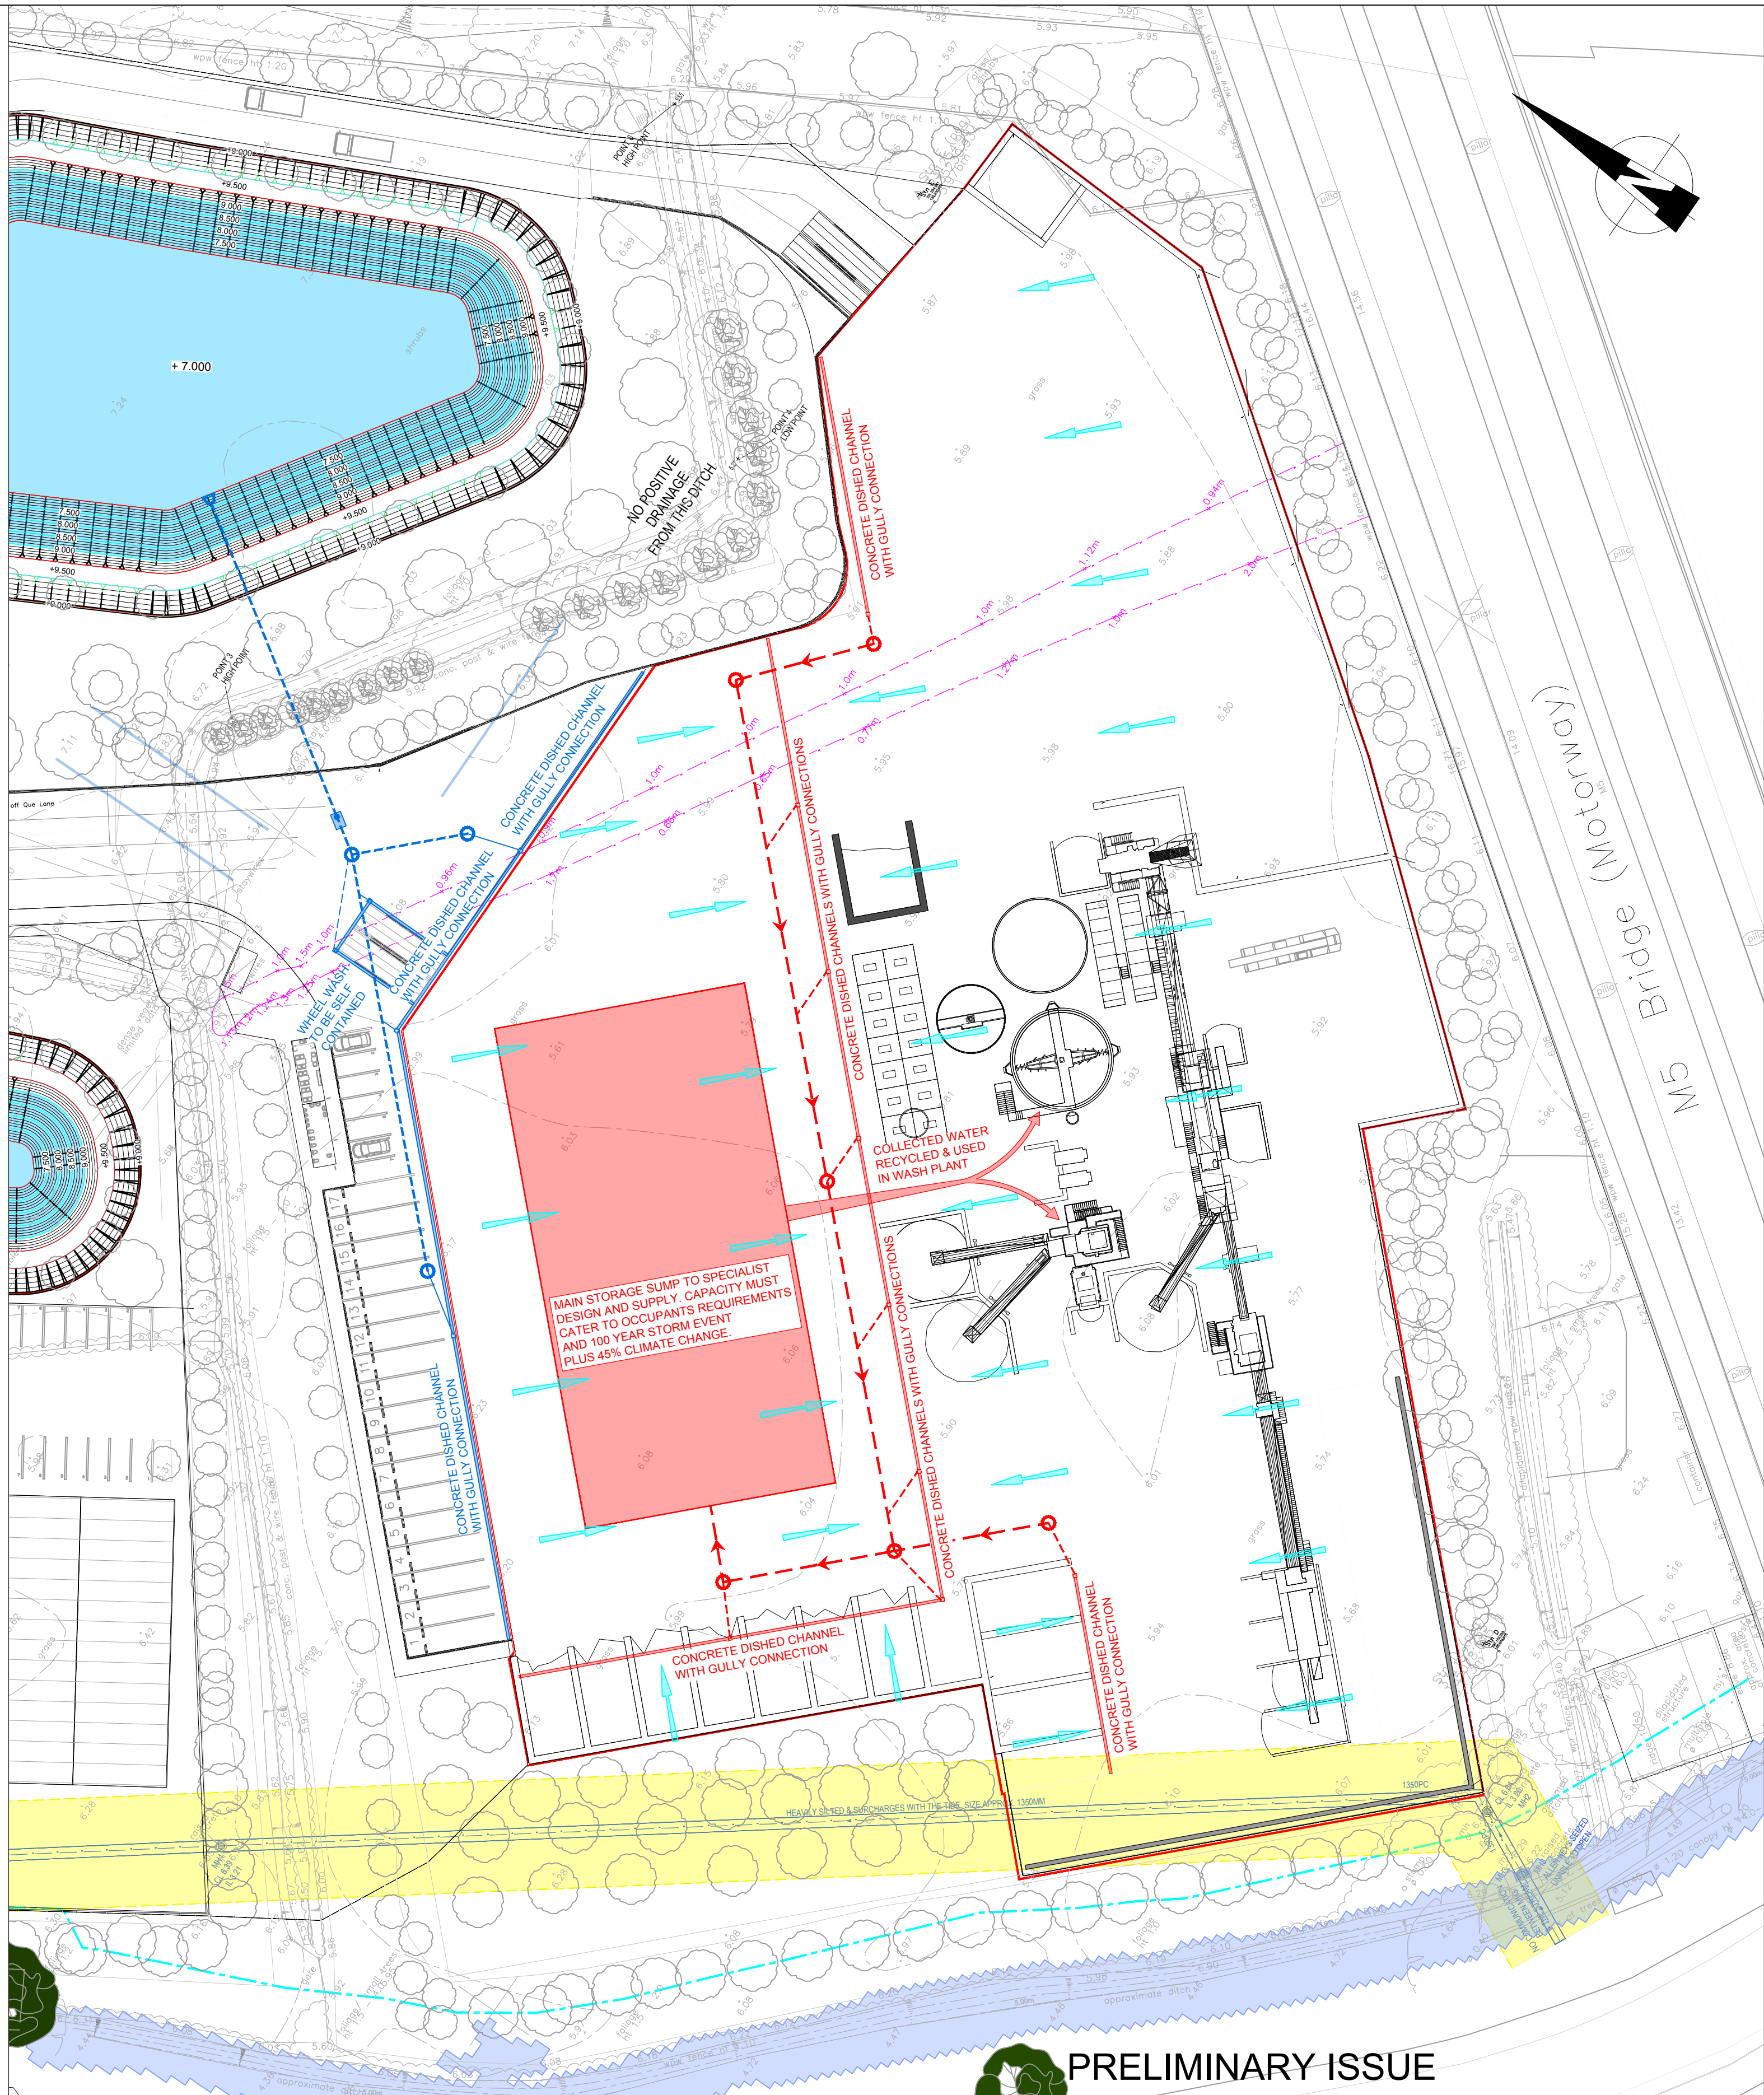


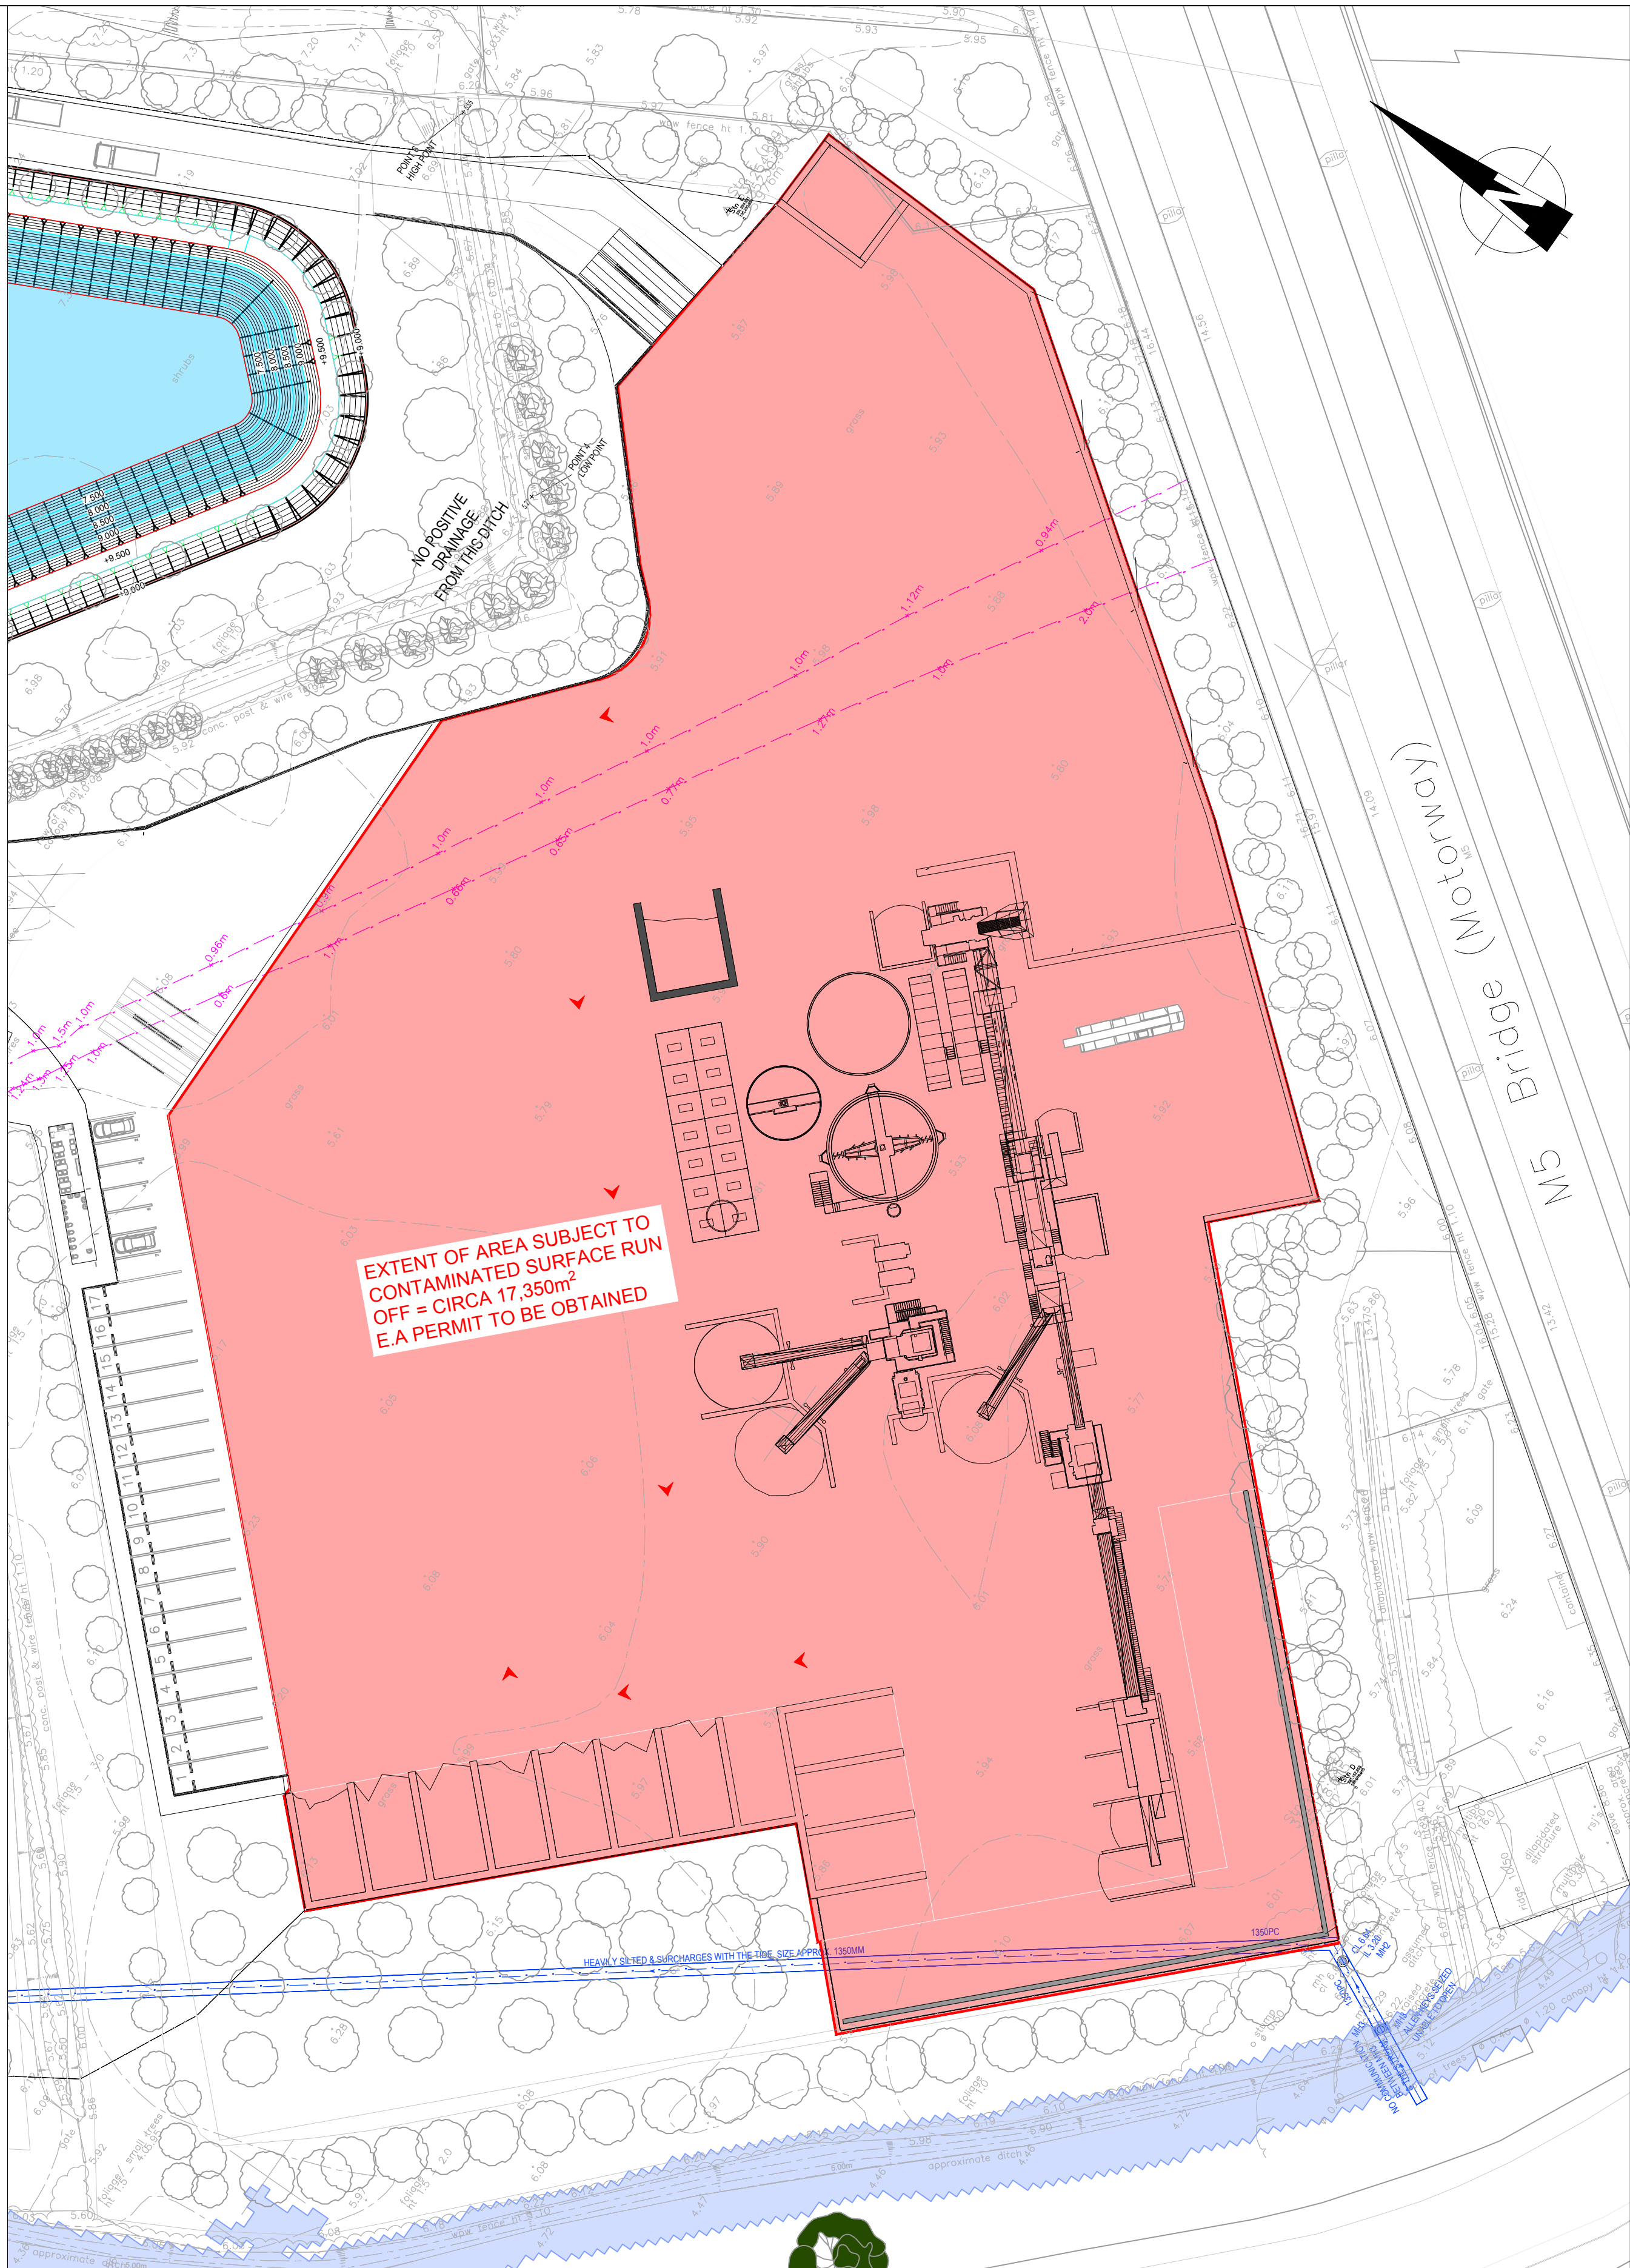

NOTES

- All rights described in chapter IV of the copyright, designs and patents act 1988 have been generally asserted
- Where any drawing is to be read in conjunction with another, including specialists, the two drawings shall be cross-checked and any discrepancies reported to the structural engineer before the work is put in hand
- This drawing is to read in conjunction with all relevant architects, M&E services and engineers drawings and specifications
- All dimensions are in millimeters, all levels are in metres, unless shown otherwise
- Any discrepancies in dimensions or details on or between these drawings/specifications should be drawn to the attention of the structural engineer in writing for clarification
- Drawing prepared solely for the use of client, as detailed in text box, and is not to be copied, lent or used by any third party without written permission

SETTING OUT TO ARCHITECT'S DRAWINGS.

DO NOT SCALE FOR CONSTRUCTION PURPOSES FROM THIS DRAWING. ALL LEVELS AND POSITIONS OF EXISTING MANHOLES AND SEWERS TO BE CONFIRMED BY THE CONTRACTOR PRIOR TO COMMENCEMENT OF THE HIGHWAY WORKS. ANY DISCREPANCIES ARE TO BE REPORTED TO THE ENGINEER.

ALL DRAINAGE WORKS ARE TO BE COMMENCED FROM THE DISCHARGE POINT AND COMMENCE UPSTREAM RESPECTIVELY. ALL COVER LEVELS SHOWN ARE APPROXIMATE AND SHOULD BE ADJUSTED LOCALLY TO SUIT FINISHED LEVELS AND LANDSCAPING. ALL SEWERS CLOSER THAN 3.0m TO A BUILDING TO BE PROTECTED BY 150mm MIN C20 CONCRETE SURROUND AND/OR FOUNDATIONS TO BE POSITIONED 150mm LOWER THAN INVERT LEVEL

NOTE.

DRAINAGE LAYOUT IS INDICATIVE TO CONVEY THE PRINCIPAL APPROACH TO THE COLLECTION AND CONVEYANCE OF CONTAMINATED RUN OFF IN THE ZONE SUBJECT TO E.A. PERMITTING. FULL AND DETAILED DRAINAGE DESIGN INCORPORATING ALL REQUIREMENTS SET DOWN BY CLIENTS OPERATION AND MAINTENANCE SCHEDULES AND TO SATISFY Q100 EVENT + 45% CLIMATE CHANGE TO BE UNDERTAKEN BY SPECIALIST DESIGNER APPOINTED BY THE CLIENT AT AN APPROPRIATE TIME

LEGEND

- EXTENT OF E.A MAIN RIVER BUFFER ZONE
- EXTENT OF HIGHWAYS ENGLAND ASSET EASEMENT
- SUMP/STORAGE TANK. SIZE AND LOCATION ARE INDICATIVE SUBJECT TO SPECIALIST DESIGN
- CARRIER DRAIN AND MANHOLE (WASH PLANT YARD RUNOFF) SUBJECT TO SPECIALIST DESIGN
- CONCRETE DISH CHANNELS WITH GULLY OUTLETS (WASH PLANT YARD RUNOFF) SUBJECT TO SPECIALIST DESIGN
- CARRIER DRAIN AND MANHOLE (PARKING & ACCESS RUNOFF) SUBJECT TO SPECIALIST DESIGN
- CONCRETE DISH CHANNELS WITH GULLY OUTLETS (PARKING & ACCESS RUNOFF) SUBJECT TO SPECIALIST DESIGN
- DIRECTION OF FALLS IN YARD SLAB (HIGH TO LOW)

Mark	Date	By	Chkd	Revision Notes
P1	06/03/26	DW	MQ	PRELIMINARY ISSUE

Client
ETM

Project Title
ETM WASTE RECYCLING
CENTRE, BRIDGWATER

Drawing Title
SOIL WASH PLANT
DRAINAGE STRATEGY

Scales 1:500 at A1			
Dwn. DW	Chkd. MQ	Appd. SJM	Date. MARCH 2026
Job No. 1977	Drawing No. BRL-14	Rev. P1	

