


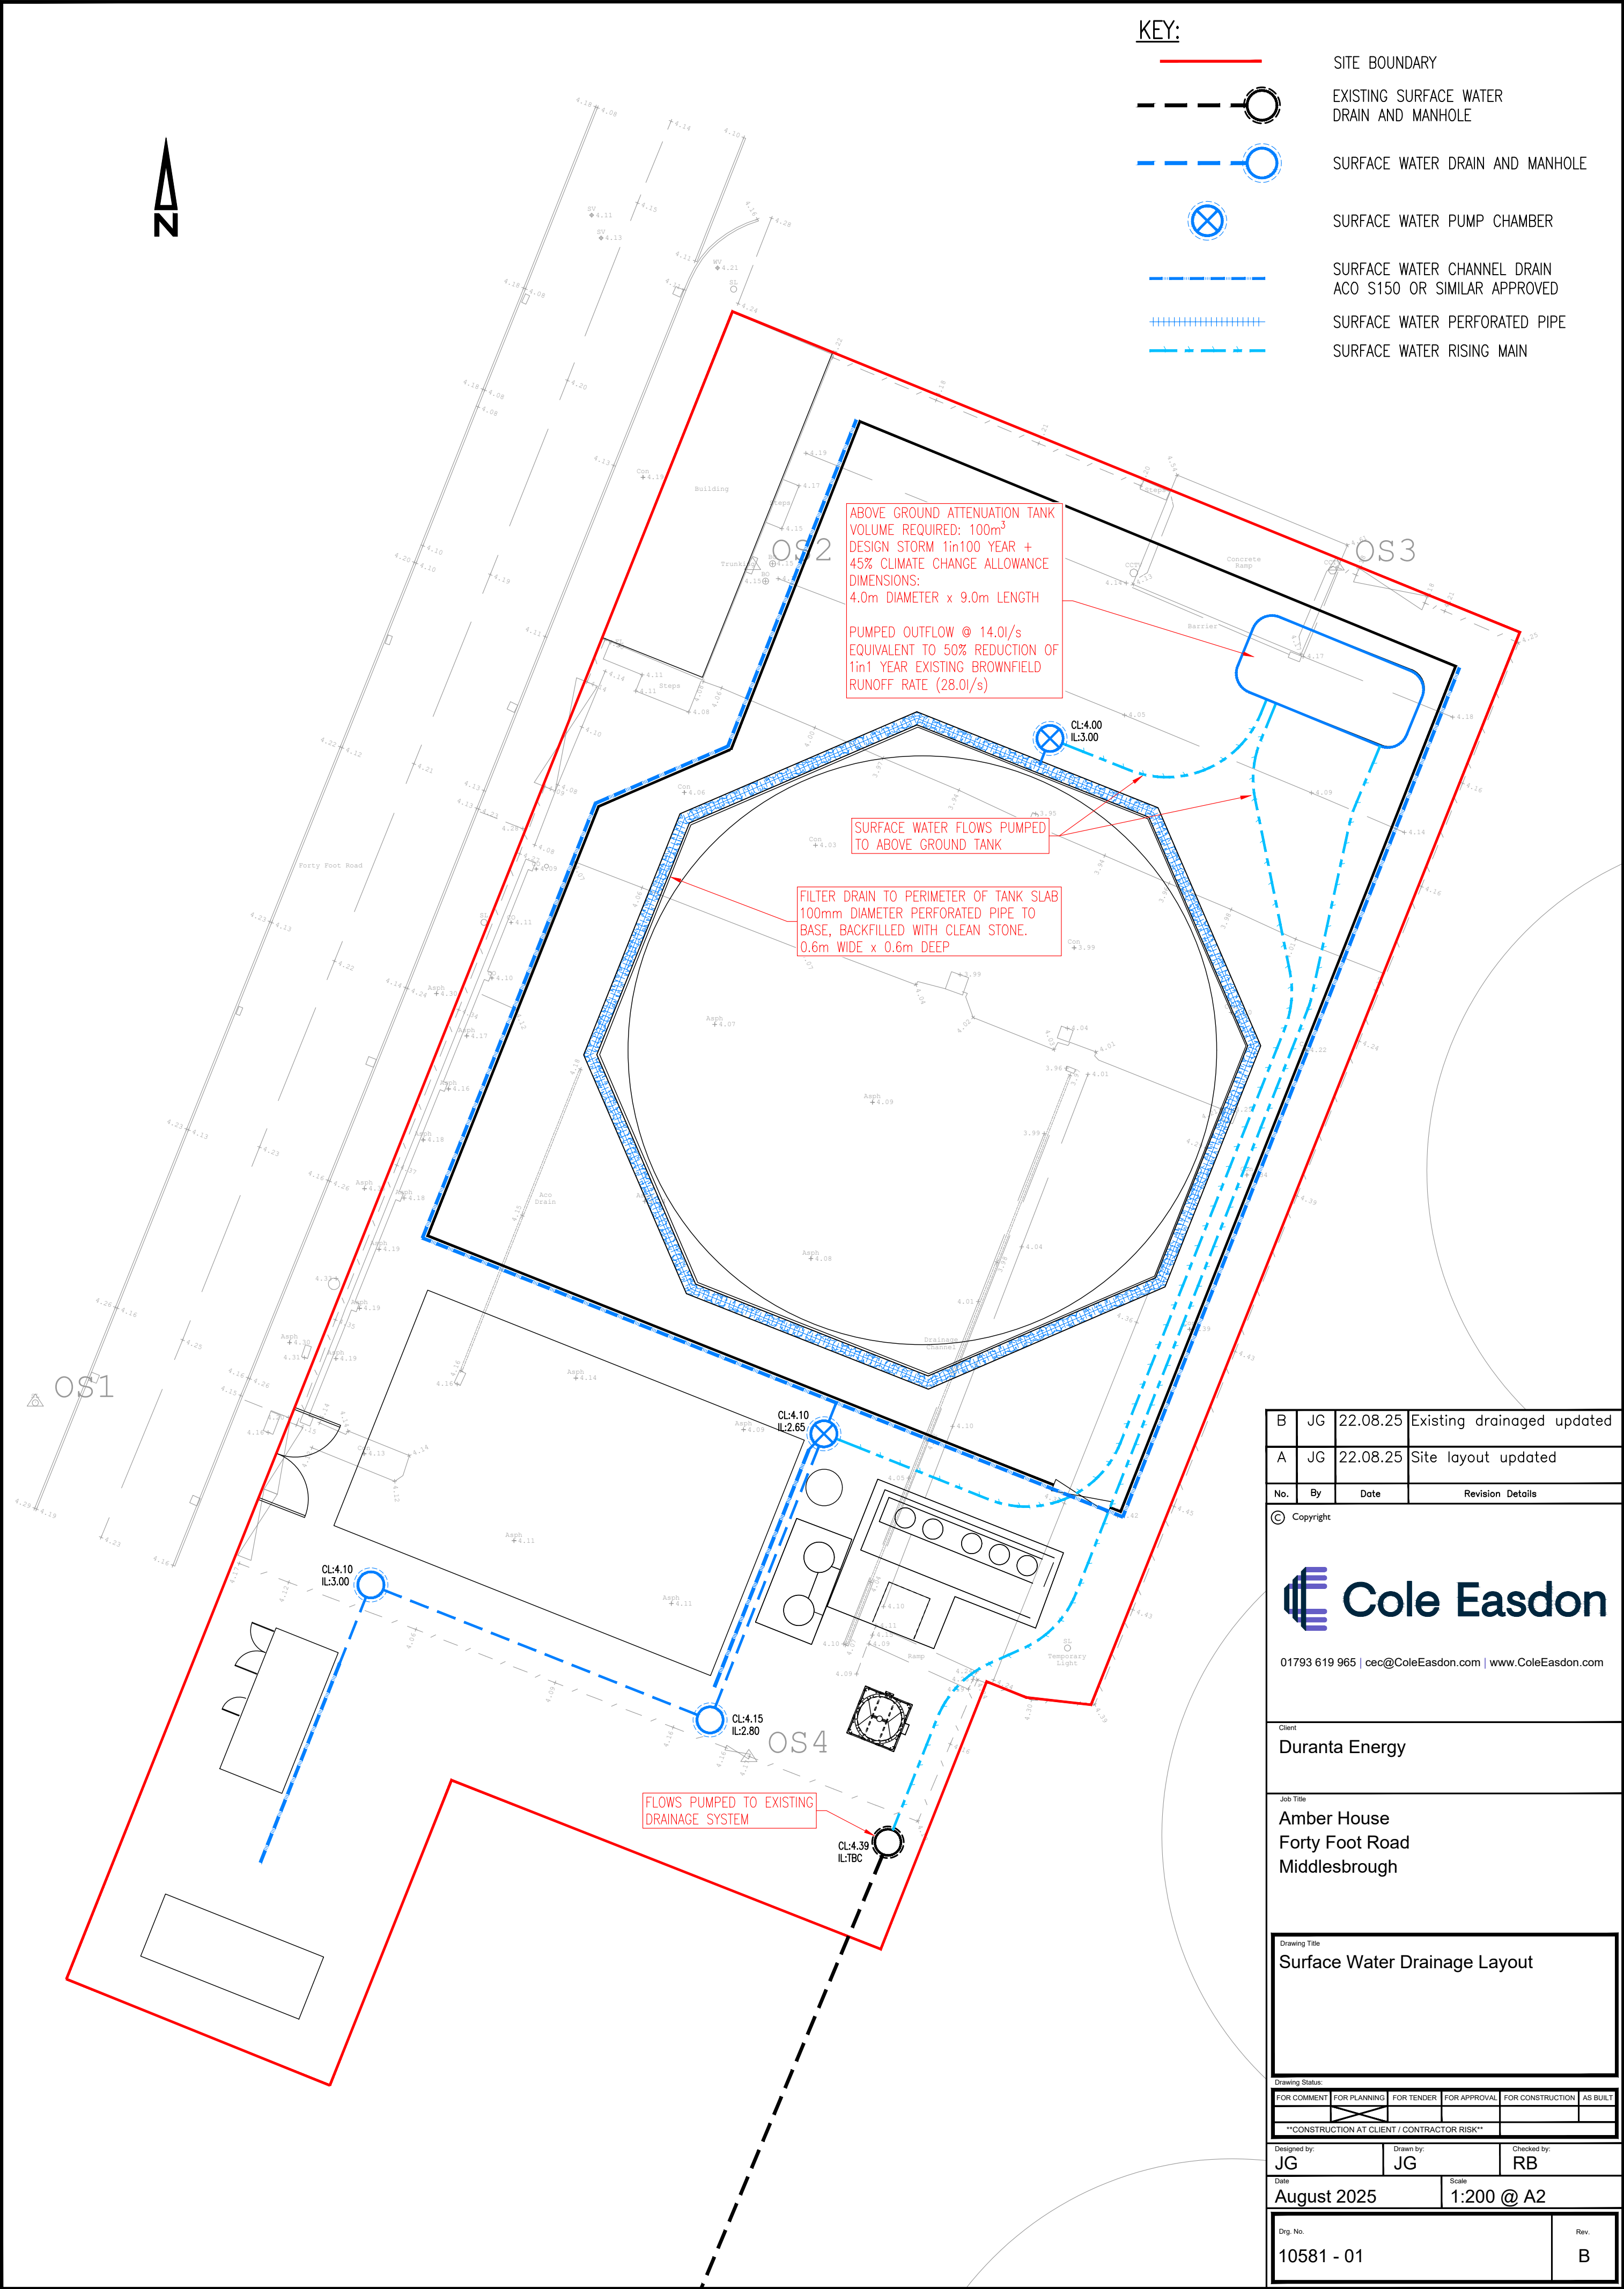

B	JG	22.08.25	Existing drainaged updated
A	JG	22.08.25	Site layout updated
No.	By	Date	Revision Details
© Copyright			
 01793 619 965 cec@ColeEasdon.com www.ColeEasdon.com			
Client Duranta Energy			
Job Title Amber House Forty Foot Road Middlesbrough			
Drawing Title Surface Water Drainage Layout			
Drawing Status: FOR COMMENT FOR PLANNING FOR TENDER FOR APPROVAL FOR CONSTRUCTION AS BUILT **CONSTRUCTION AT CLIENT / CONTRACTOR RISK**			
Drawn by: JG		Checked by: RB	
Date: August 2025		Scale: 1:200 @ A2	
Dwg. No. 10581 - 01			Rev. B