

ALL INFORMATION ON THIS DRAWING IS INDICATIVE ONLY, AND MAY BE SUBJECT TO FURTHER DESIGN DEVELOPMENT.

DO NOT SCALE

NOTES:

— SITE BOUNDARY

R4.0	5000L FUEL TANK ADDED	DTW	JMS	NM1	06.11.20
R3.0	MULTIPLE CHANGES MADE	DTW	JMS	NM1	04.11.20
R2.0	PRELIMINARY	DTW	JMS	NM1	26.10.20
R1.0	PRELIMINARY	DTW	JMS	NM1	09.10.20
REV.	DETAILS OF REVISION	DRAWN	CHKD	APR	DATE

FICHTNER
CONSULTING ENGINEERS LIMITED

Kingsgate, Wellington Road North,
Stockport, Cheshire, SK4 1LW, UK Tel:
0161 476 0032
Website: www.fichtner.co.uk

CLIENT:

WKE MIDDLESBOROUGH LTD

SITE:

MIDDLESBOROUGH

PROJECT:

WKE PELLETING PLANT

TITLE:

OVERALL SITE & PROCESS EQUIPMENT
DRAINAGE PLAN

DRAWING STATUS: PRELIMINARY

DRAWN BY: DTW DATE: 09.10.20

CHECKED BY: JMS DATE: 09.10.20

APPROVED BY: NM1 DATE: 09.10.20


FILENAME: S3110-8000-0001DW OVERALL SITE AND PROCESS EQUIPMENT LAYOUT R4.0

OFFICE OF ISSUE: STOCKPORT

SHEET SIZE: A3 SCALE: 1:750

DRAWING No.: REVISION:

S3110-8000-0001 Sheet 1 of 3 **R4.0**

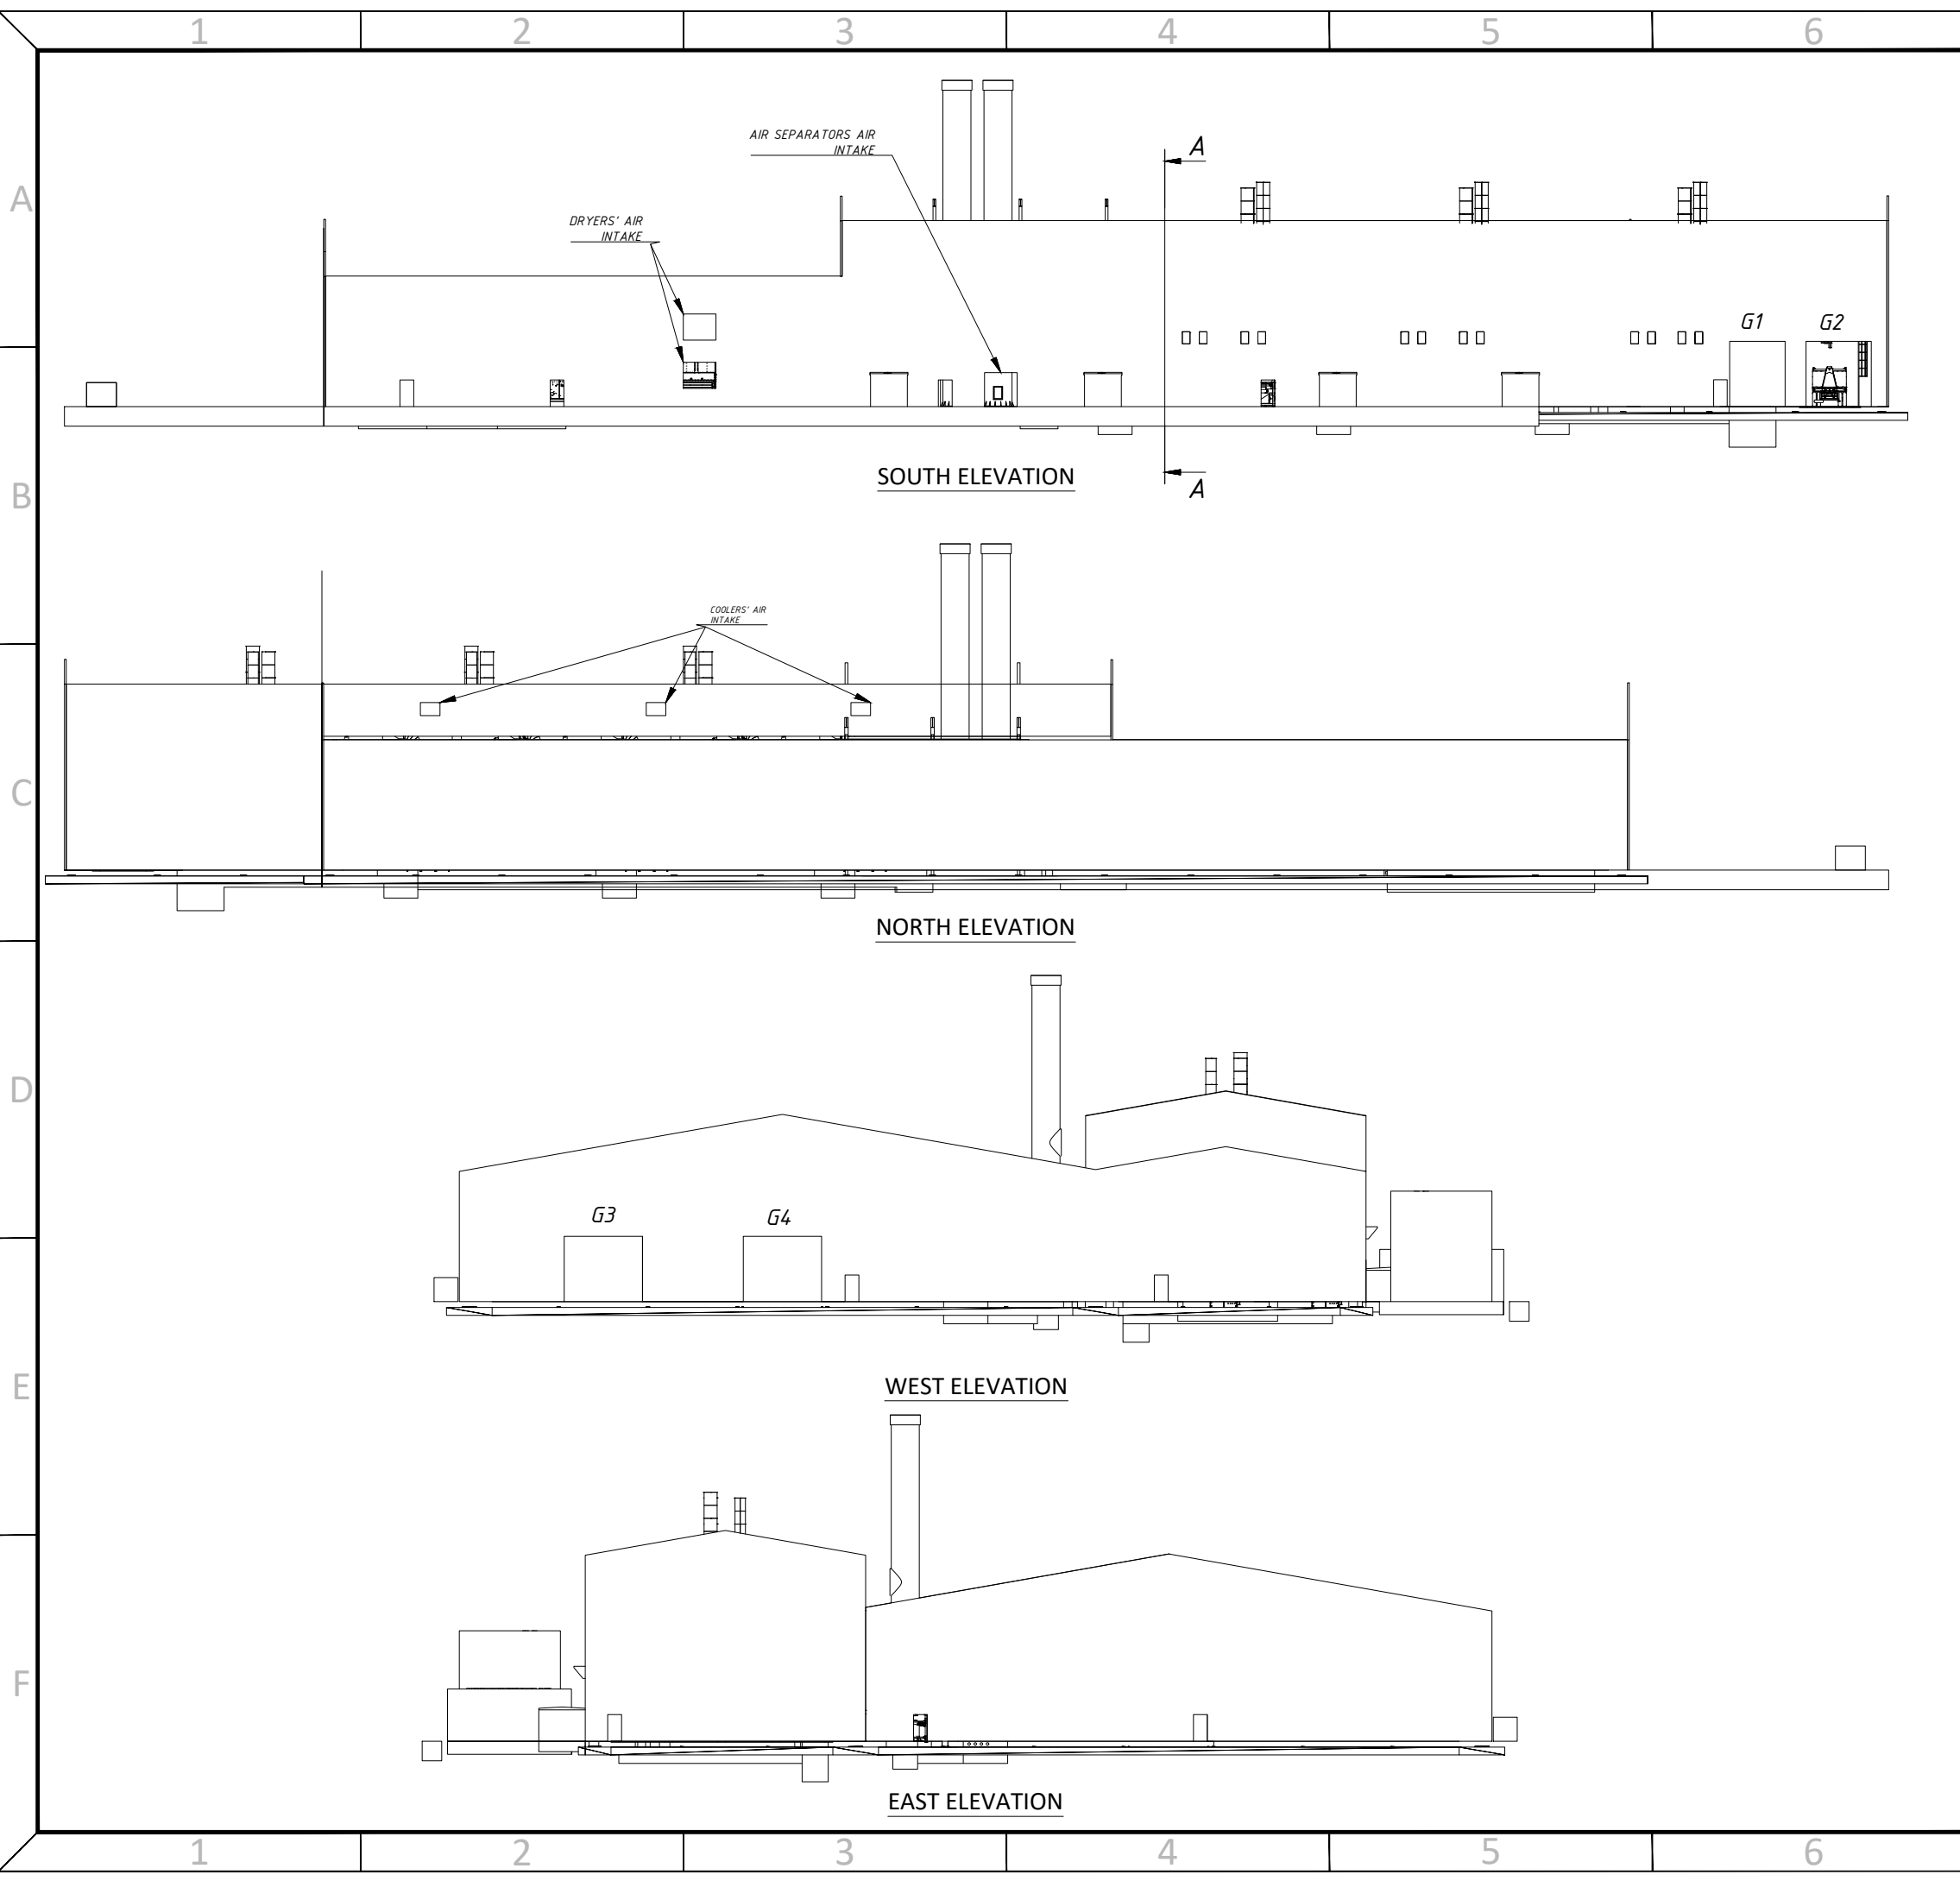

ALL INFORMATION ON THIS DRAWING IS INDICATIVE ONLY, AND MAY BE SUBJECT TO FURTHER DESIGN DEVELOPMENT.

DO NOT SCALE

NOTES:

R4.0	5000L FUEL TANK ADDED	DTW	JMS	NM1	06.11.20
R3.0	MULTIPLE CHANGES MADE	DTW	JMS	NM1	04.11.20
R2.0	PRELIMINARY	DTW	JMS	NM1	26.10.20
R1.0	PRELIMINARY	DTW	JMS	NM1	09.10.20
REV.	DETAILS OF REVISION	DRAWN	CHKD	APR	DATE

FICHTNER
CONSULTING ENGINEERS LIMITED

Kingsgate, Wellington Road North,
Stockport, Cheshire, SK4 1LW, UK Tel:
0161 476 0032
Website: www.fichtner.co.uk

CLIENT:
WKE MIDDLESBOROUGH LTD


SITE:
MIDDLESBOROUGH

PROJECT:
WKE PELLETTING PLANT

TITLE:
OVERALL SITE & PROCESS EQUIPMENT ELEVATIONS

DRAWING STATUS:		PRELIMINARY	
DRAWN BY:	DTW	DATE:	09.10.20
CHECKED BY:	JMS	DATE:	09.10.20
APPROVED BY:	NM1	DATE:	09.10.20
FILENAME:	S3110-8000-0001DW OVERALL SITE AND PROCESS EQUIPMENT LAYOUT R4.0		
OFFICE OF ISSUE:	STOCKPORT		
SHEET SIZE:	A3	SCALE:	1:500

DRAWING No.:
S3110-8000-0001 Sheet 2 of 3 REVISION:
R4.0

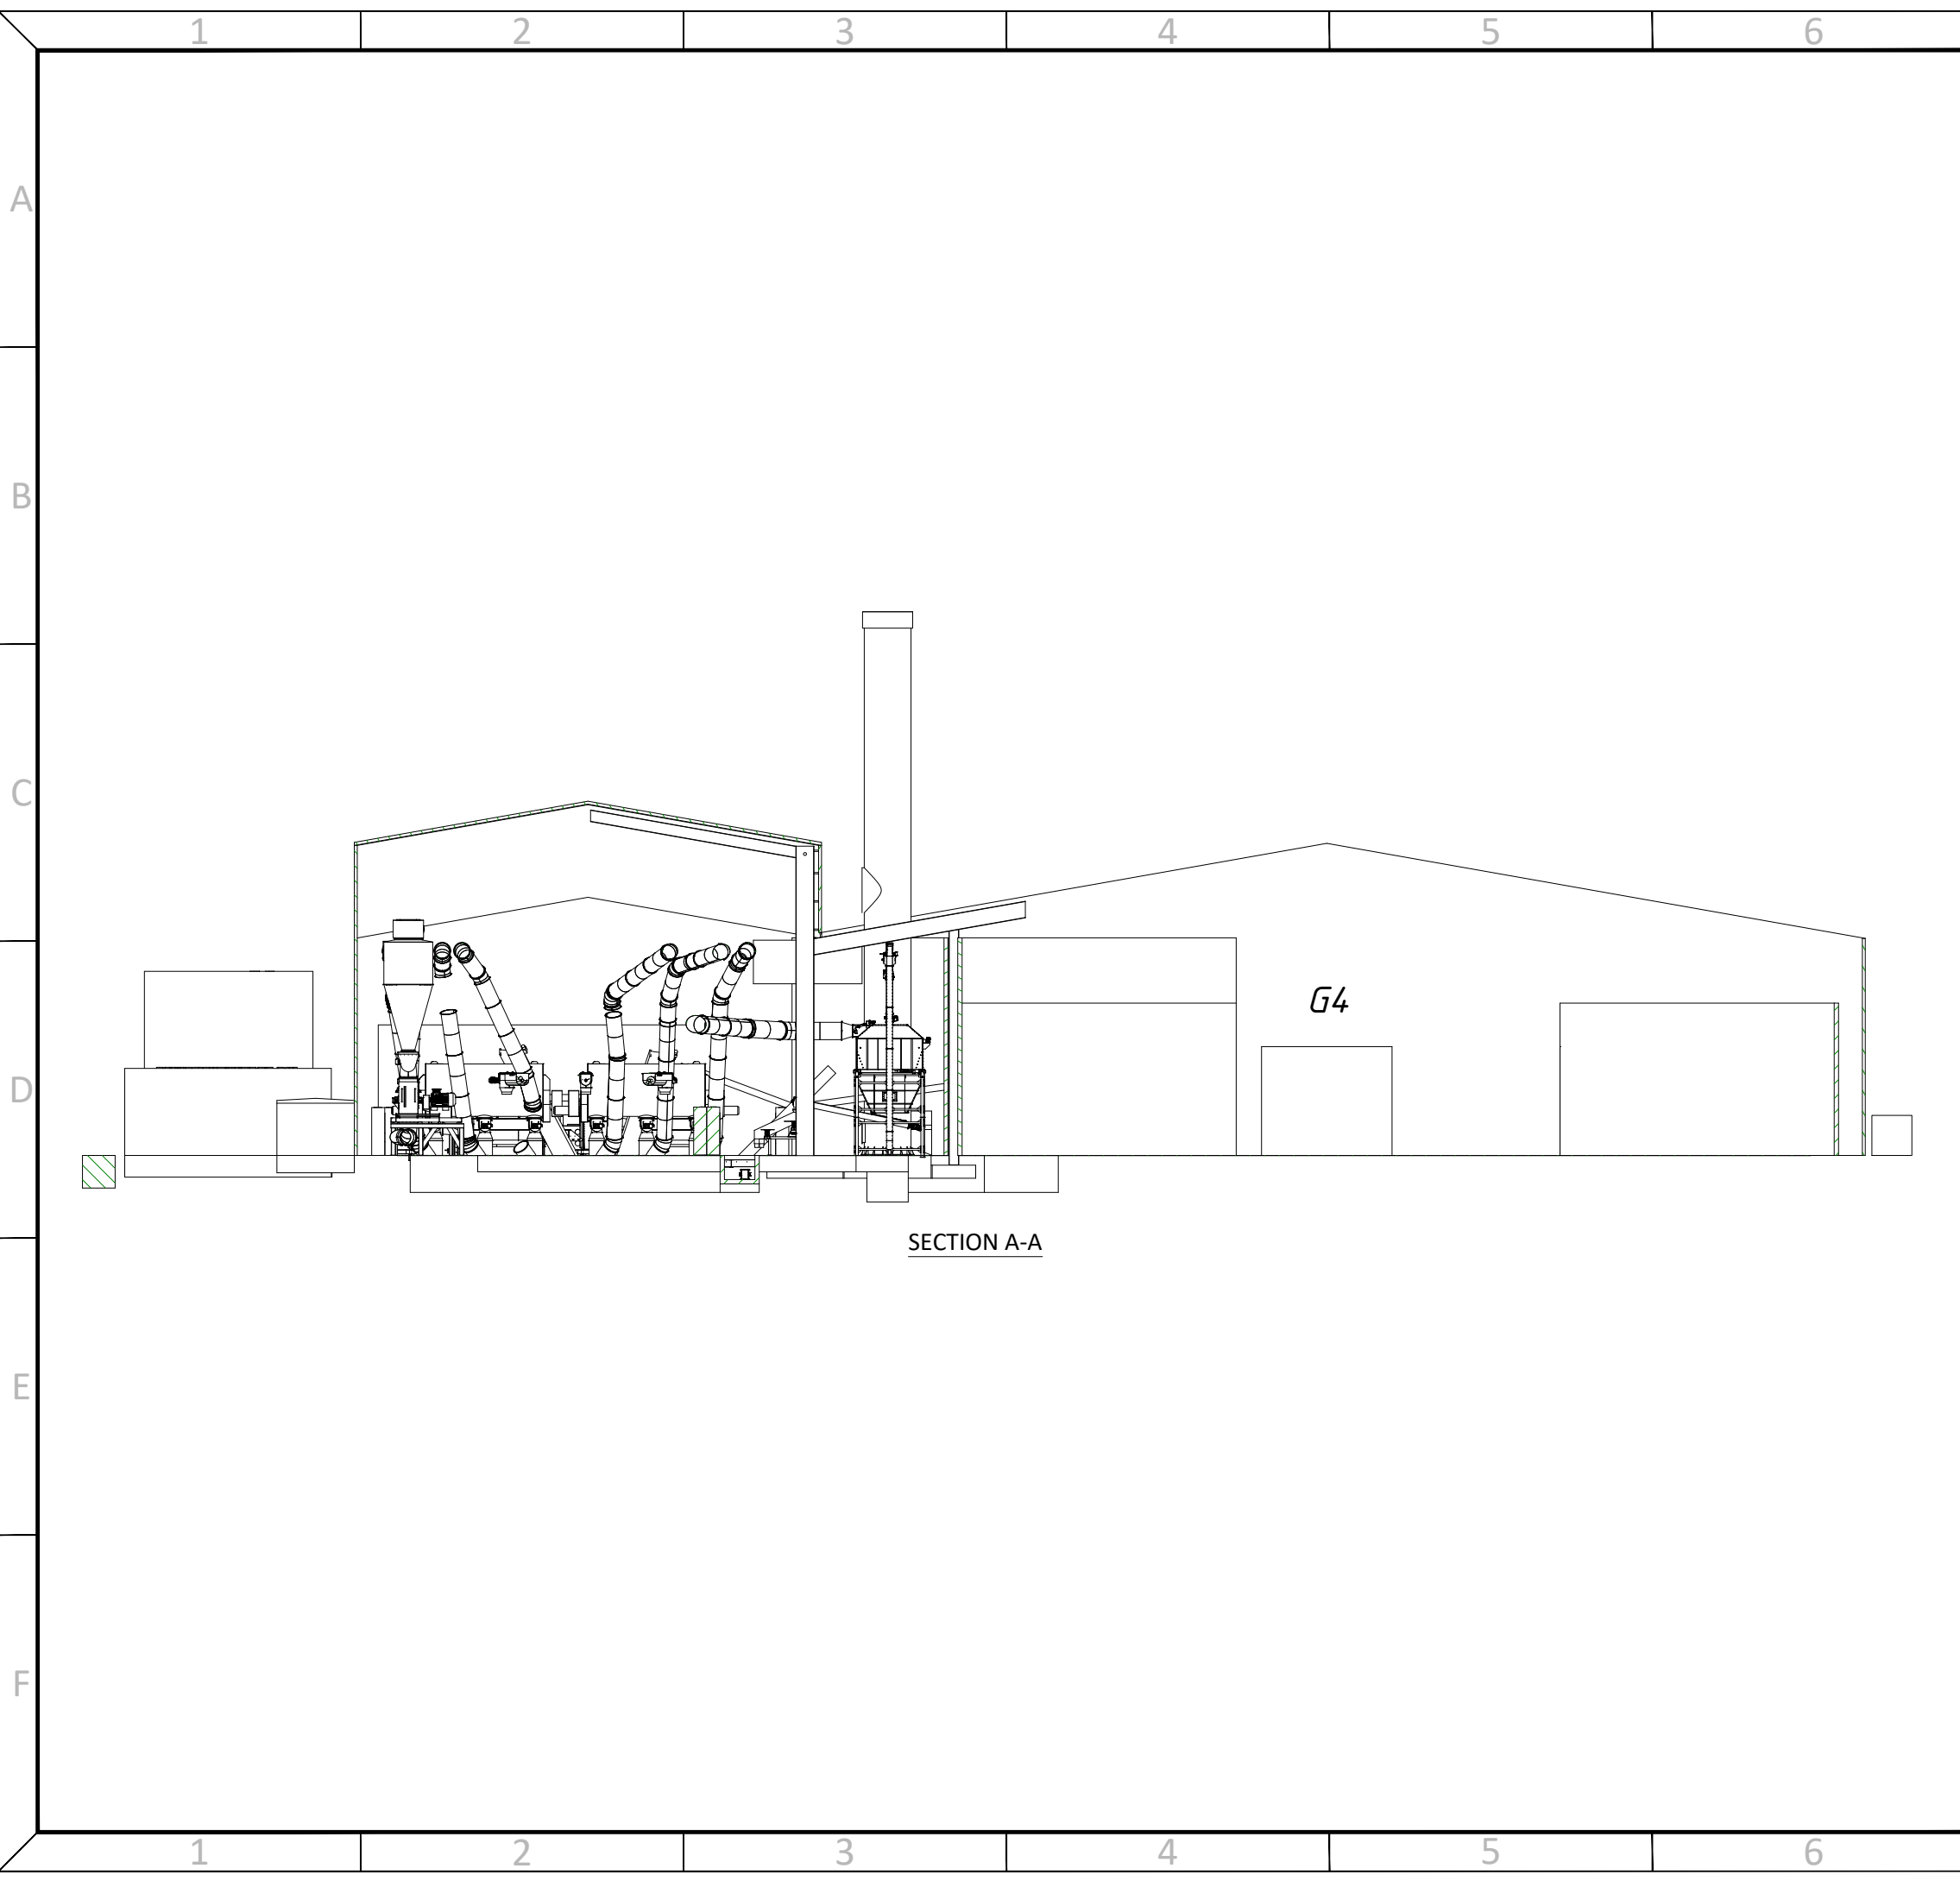

SECTION A-A

ALL INFORMATION ON THIS DRAWING IS INDICATIVE ONLY, AND MAY BE SUBJECT TO FURTHER DESIGN DEVELOPMENT.

DO NOT SCALE

NOTES:

R4.0	5000L FUEL TANK ADDED	DTW	JMS	NM1	06.11.20
R3.0	MULTIPLE CHANGES MADE	DTW	JMS	NM1	04.11.20
R2.0	PRELIMINARY	DTW	JMS	NM1	26.10.20
R1.0	PRELIMINARY	DTW	JMS	NM1	09.10.20
REV.	DETAILS OF REVISION	DRAWN	CHKD	APR	DATE

FICHTNER
CONSULTING ENGINEERS LIMITED

Kingsgate, Wellington Road North,
Stockport, Cheshire, SK4 1LW, UK Tel:
0161 476 0032
Website: www.fichtner.co.uk

CLIENT: **WKE MIDDLESBOROUGH LTD**

SITE: **MIDDLESBOROUGH**

PROJECT: **WKE PELLETING PLANT**

TITLE: **OVERALL SITE & PROCESS EQUIPMENT SECTION A-A**

DRAWING STATUS:		PRELIMINARY	
DRAWN BY:	DTW	DATE:	09.10.20
CHECKED BY:	JMS	DATE:	09.10.20
APPROVED BY:	NM1	DATE:	09.10.20
FILENAME:	S3110-8000-0001DW OVERALL SITE AND PROCESS EQUIPMENT LAYOUT R4.0		
OFFICE OF ISSUE:	STOCKPORT		
SHEET SIZE:	A3	SCALE:	1:300

DRAWING No.: **S3110-8000-0001** Sheet 3 of 3 REVISION: **R4.0**