


WITH ALL BEST ENDEAVOURS THIS IS THE PROPOSED STORAGE ARRANGEMENTS BUT THEY MIGHT CHANGE FROM TIME TO TIME

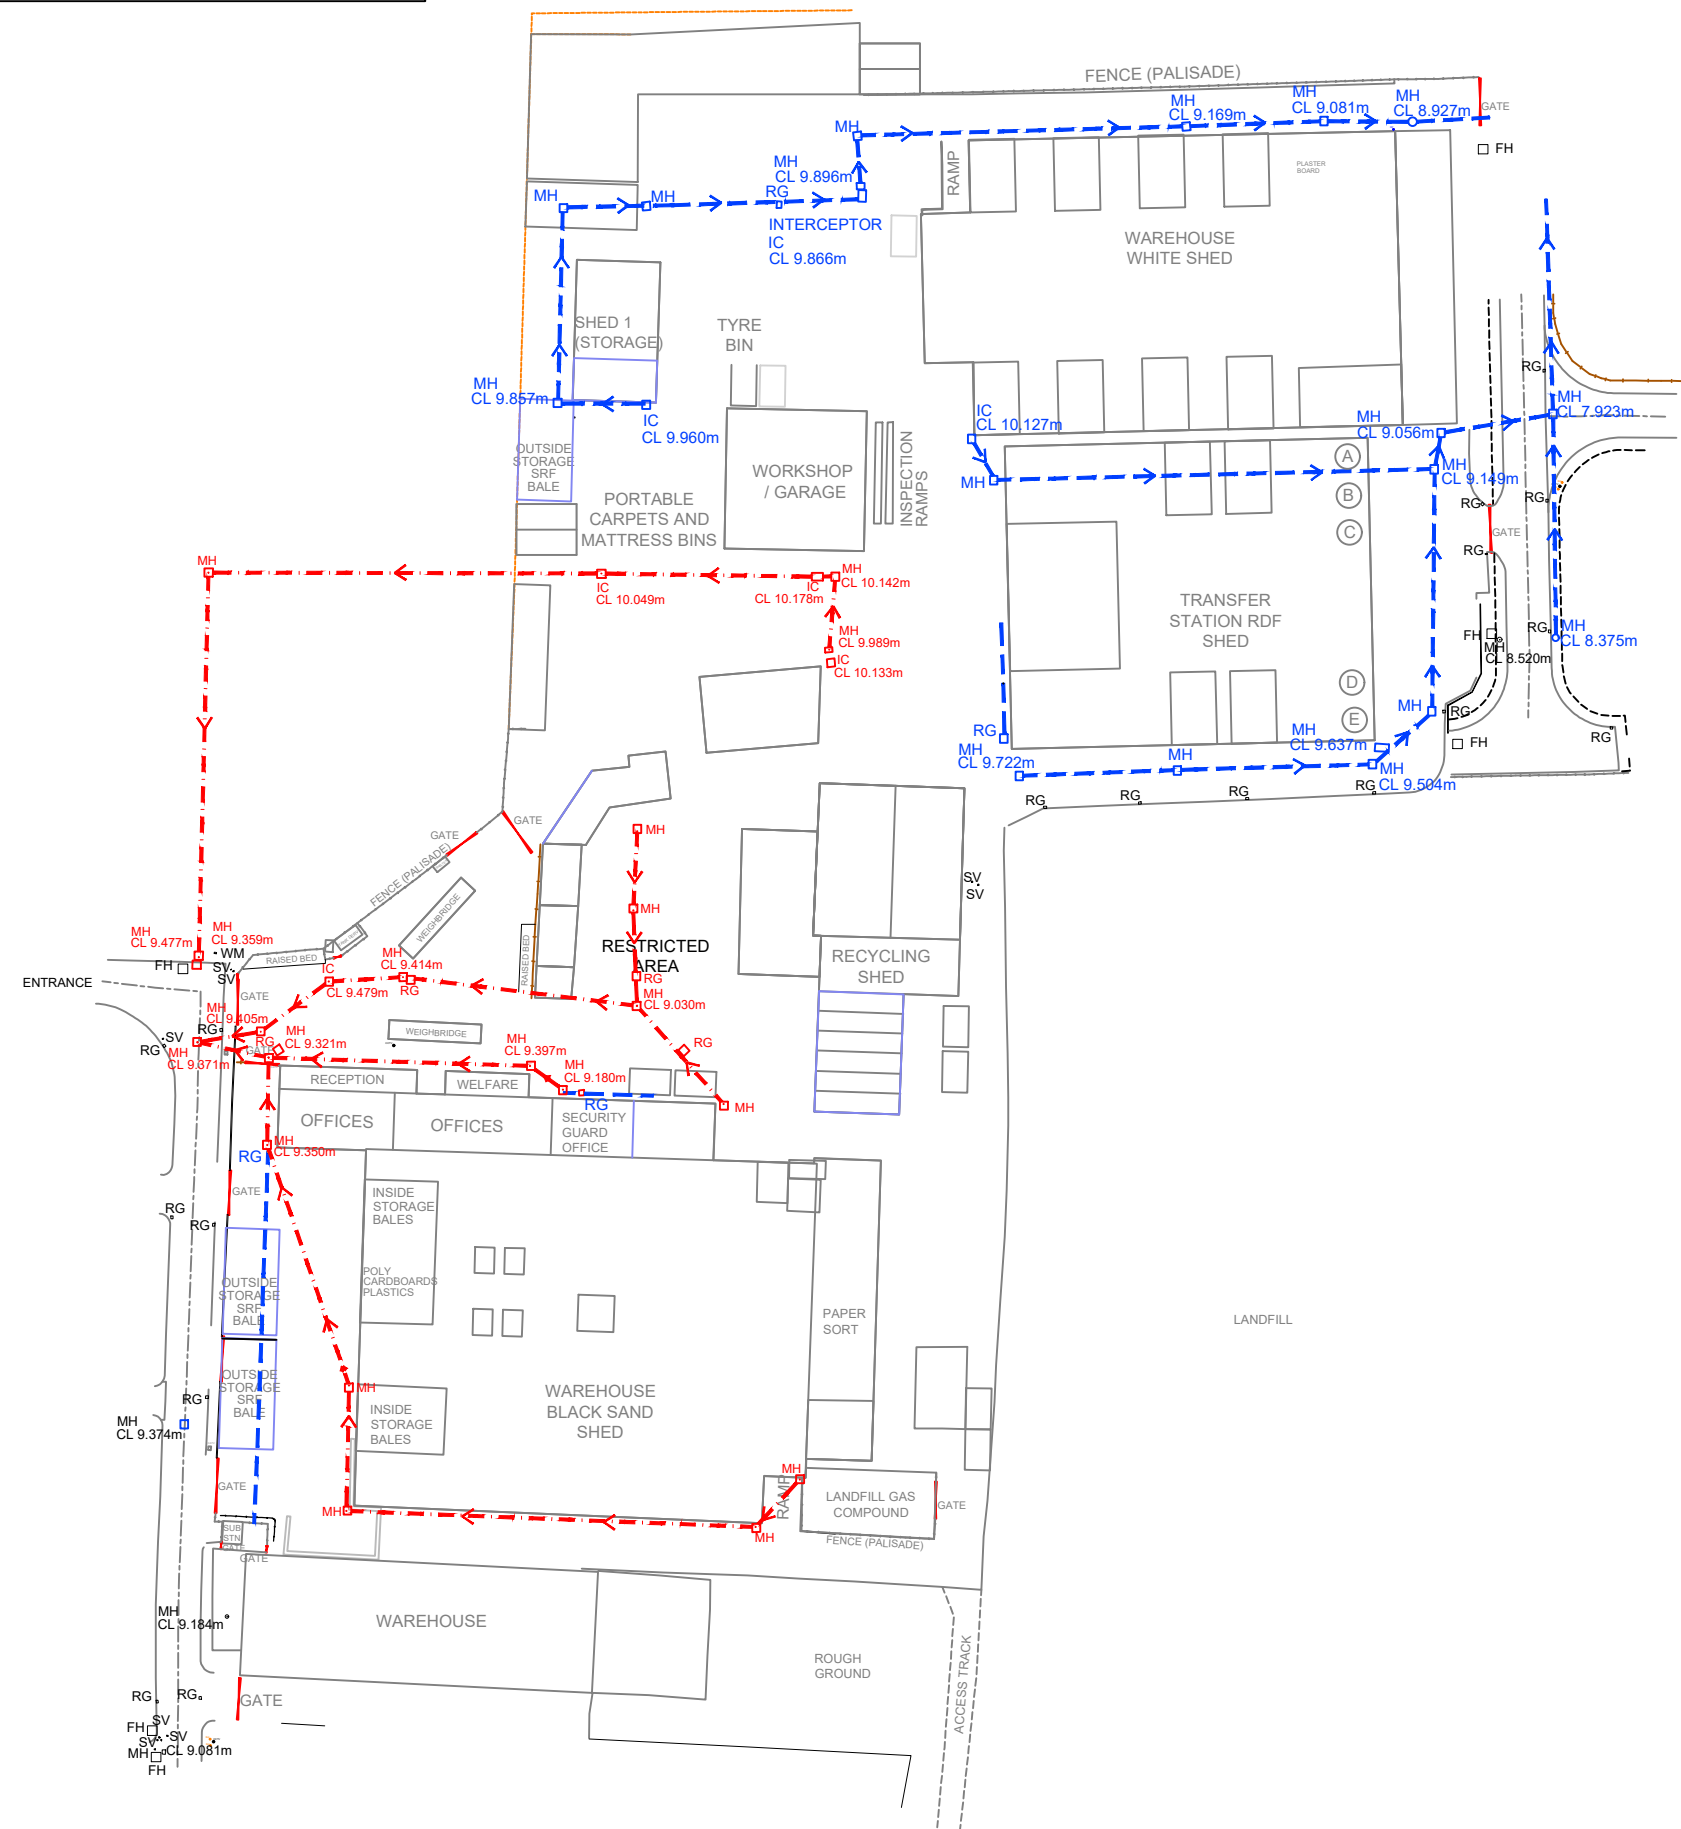

- LEGEND
- >--- STORM WATER
 - >--- COMBINED SEWER
 - MH CL 0.000m MANHOLE (INTERCEPTOR)
 - MH CL 0.000m MANHOLE (SQUARE)
 - MH CL 0.000m MANHOLE (TRIANGULAR)
 - MH CL 0.000m MANHOLE (CIRCULAR)
 - IC CL 0.000m INSPECTION CHAMBER
 - IC CL 0.000m INSPECTION CHAMBER (CIRCULAR)
 - SV STOP VALVE
 - AV AIR VALVE
 - FH FIRE HYDRANT
 - SC STOP COCK
 - Invert Level + 0.000m INVERT LEVEL
 - WO WASH OUT
 - RG ROAD GULLY
 - o GULLY

LAYOUT PROVIDED BY GIBSON SURVEYING AND MAPPING
DRAWING No. NX/LL/DS01 DATED 30-10-18

C	New layout added	29-04-19	DR	LP	LP
B	New layout added	23-04-19	DR	LP	LP
A	First Issue	04-01-19	DR	LP	LP

REVISION	DETAILS	DATE	DRN	CHKD	APPD
----------	---------	------	-----	------	------

CLIENT	N+P Hartlepool MRF Ltd.
--------	-------------------------

PROJECT	Fire Prevention Plan Longhill
---------	-------------------------------

DRAWING TITLE	Drainage Layout
---------------	-----------------

DRG No.	ST16637-004	REV	C
DRG SIZE	A3	SCALE	1:1250
DRAWN BY	DR	CHECKED BY	LP
		APPROVED BY	LP

wardell armstrong

STOKE ON TRENT | TEL 01782 276700
WWW.WARDELL-ARMSTRONG.COM

☐ BIRMINGHAM	☐ GLASGOW
☐ BOLTON	☐ LONDON
☐ CARDIFF	☐ MANCHESTER
☐ CARLISLE	☐ NEWCASTLE UPON TYNE
☐ EDINBURGH	☐ SHEFFIELD