


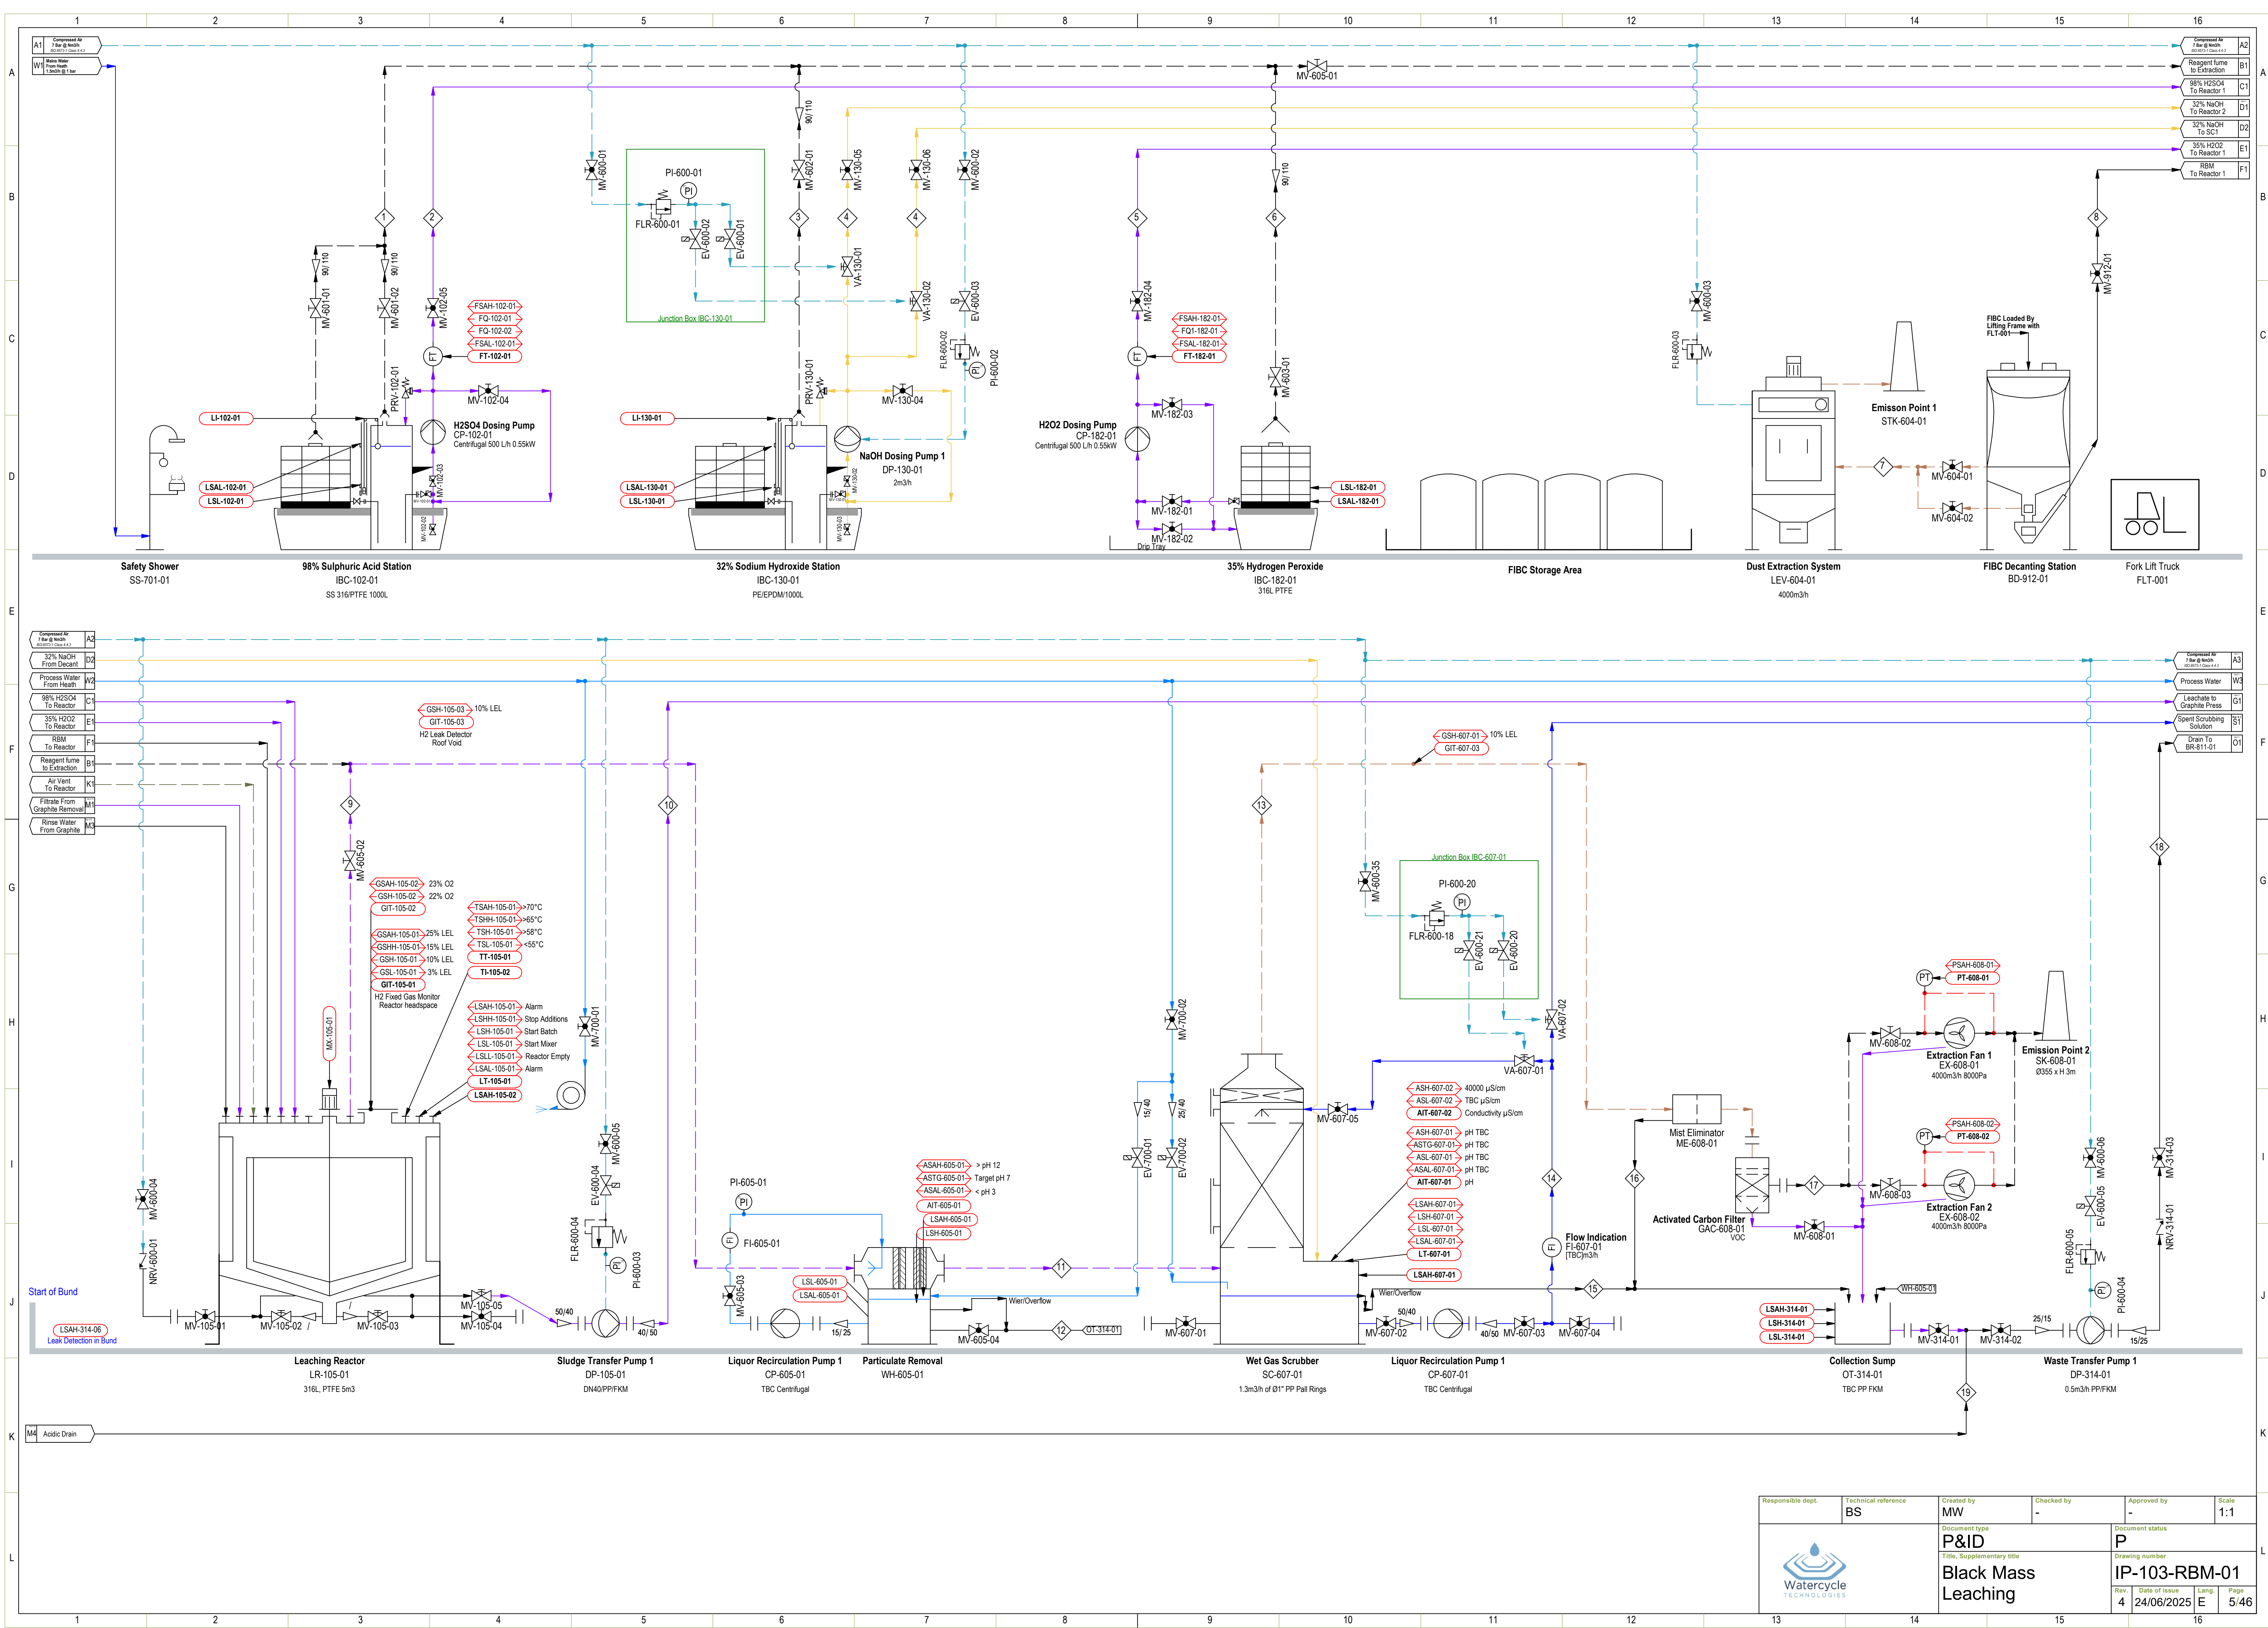


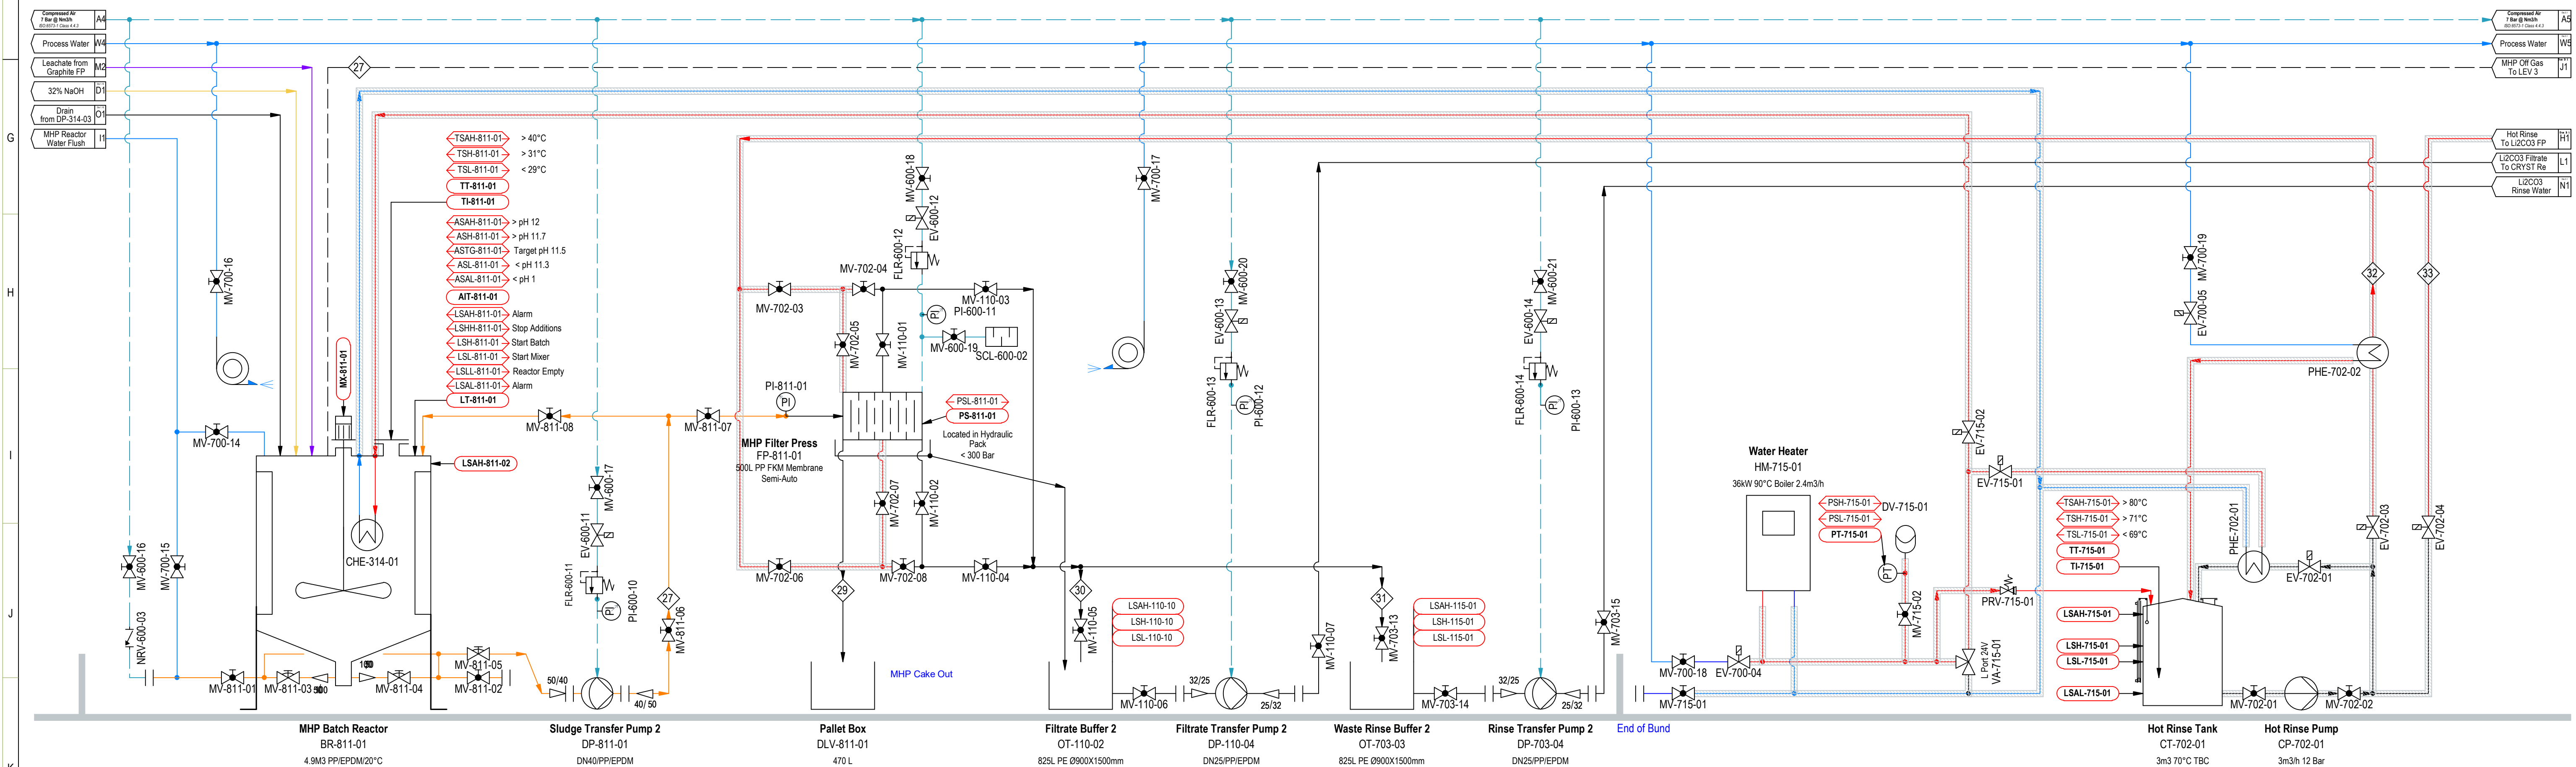

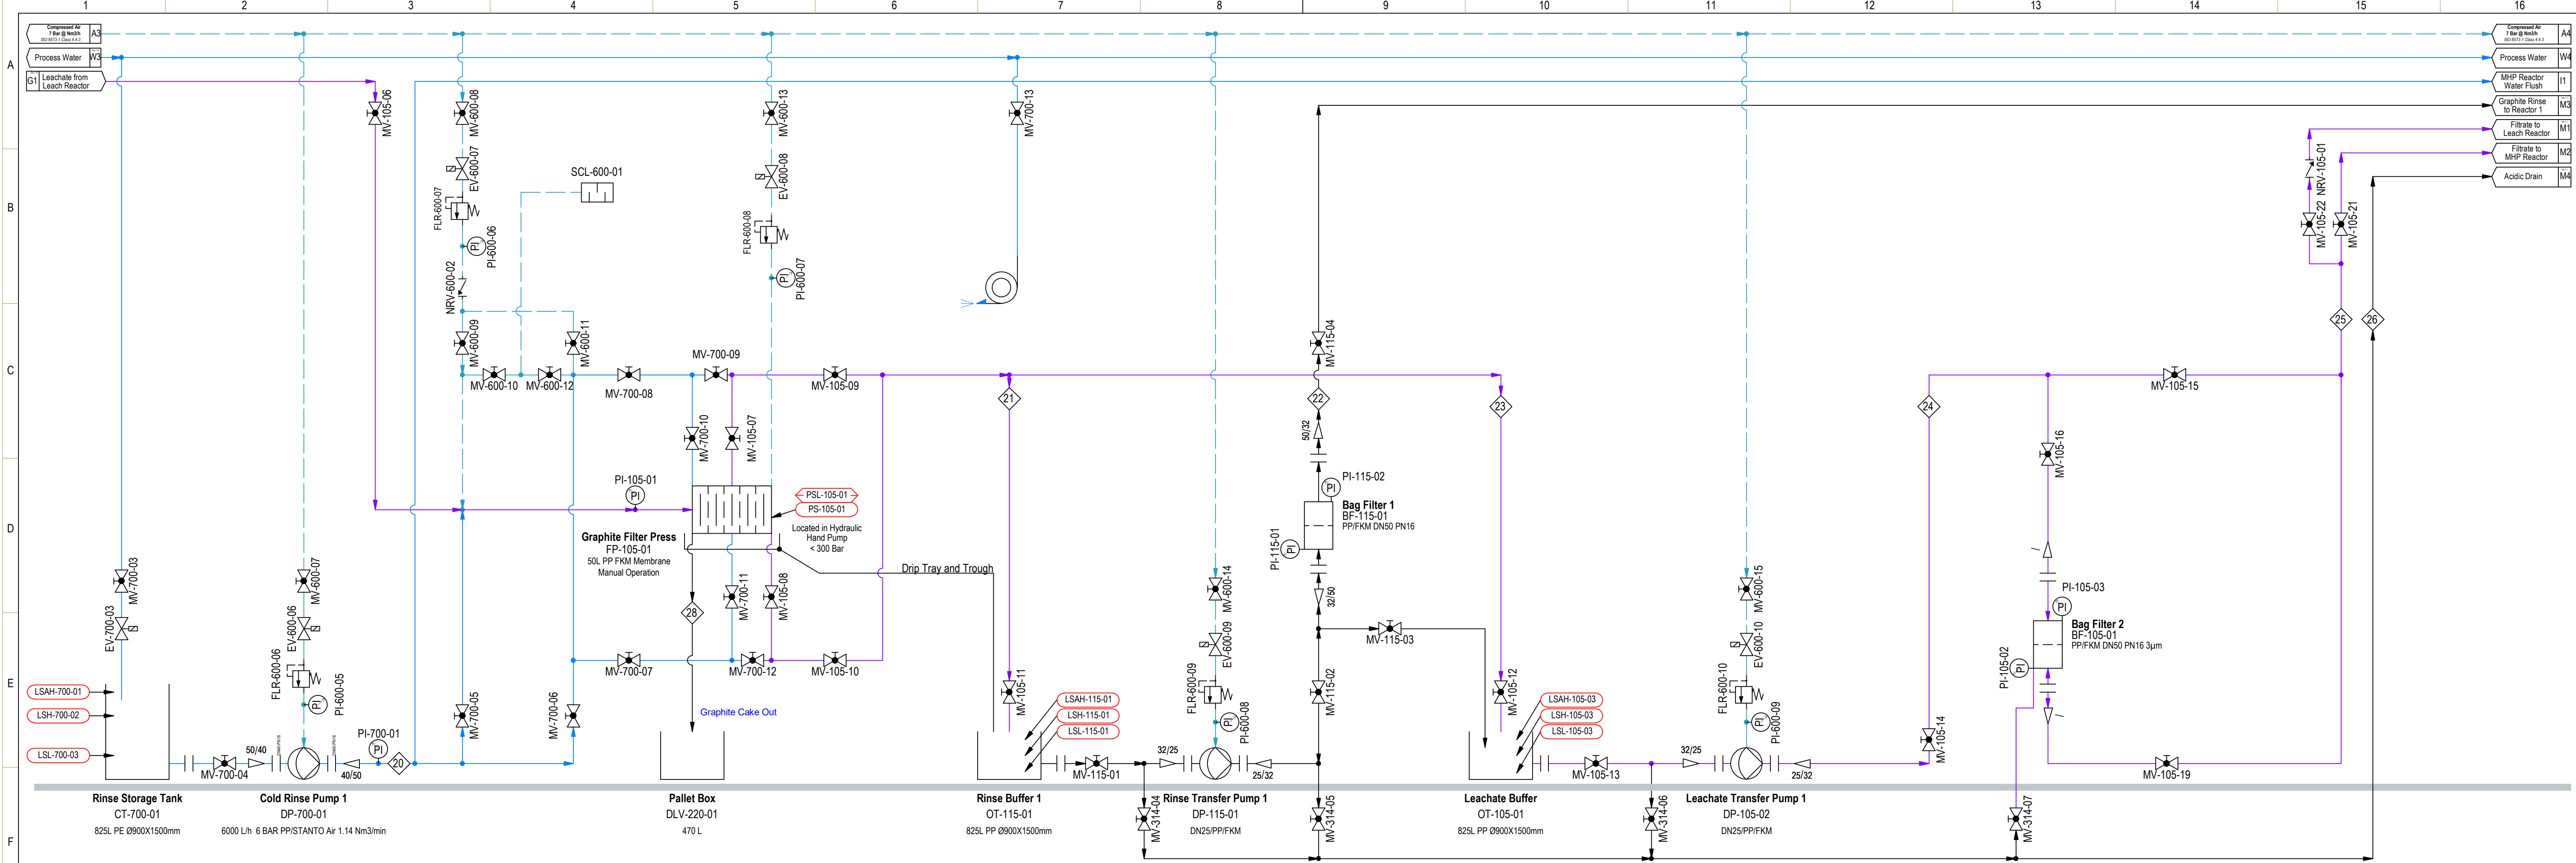

Responsible dept.	Technical reference	Created by	Checked by	Approved by	Scale
	BS	MW	-	-	1:1
Document type		Document status			
P&ID		P			
Title, Supplementary title		Drawing number			
Leachate & MHP		IP-103-RBM-02			
Rev.	Date of issue	Lang.	Page		
4	24/06/2025	E	6/46		

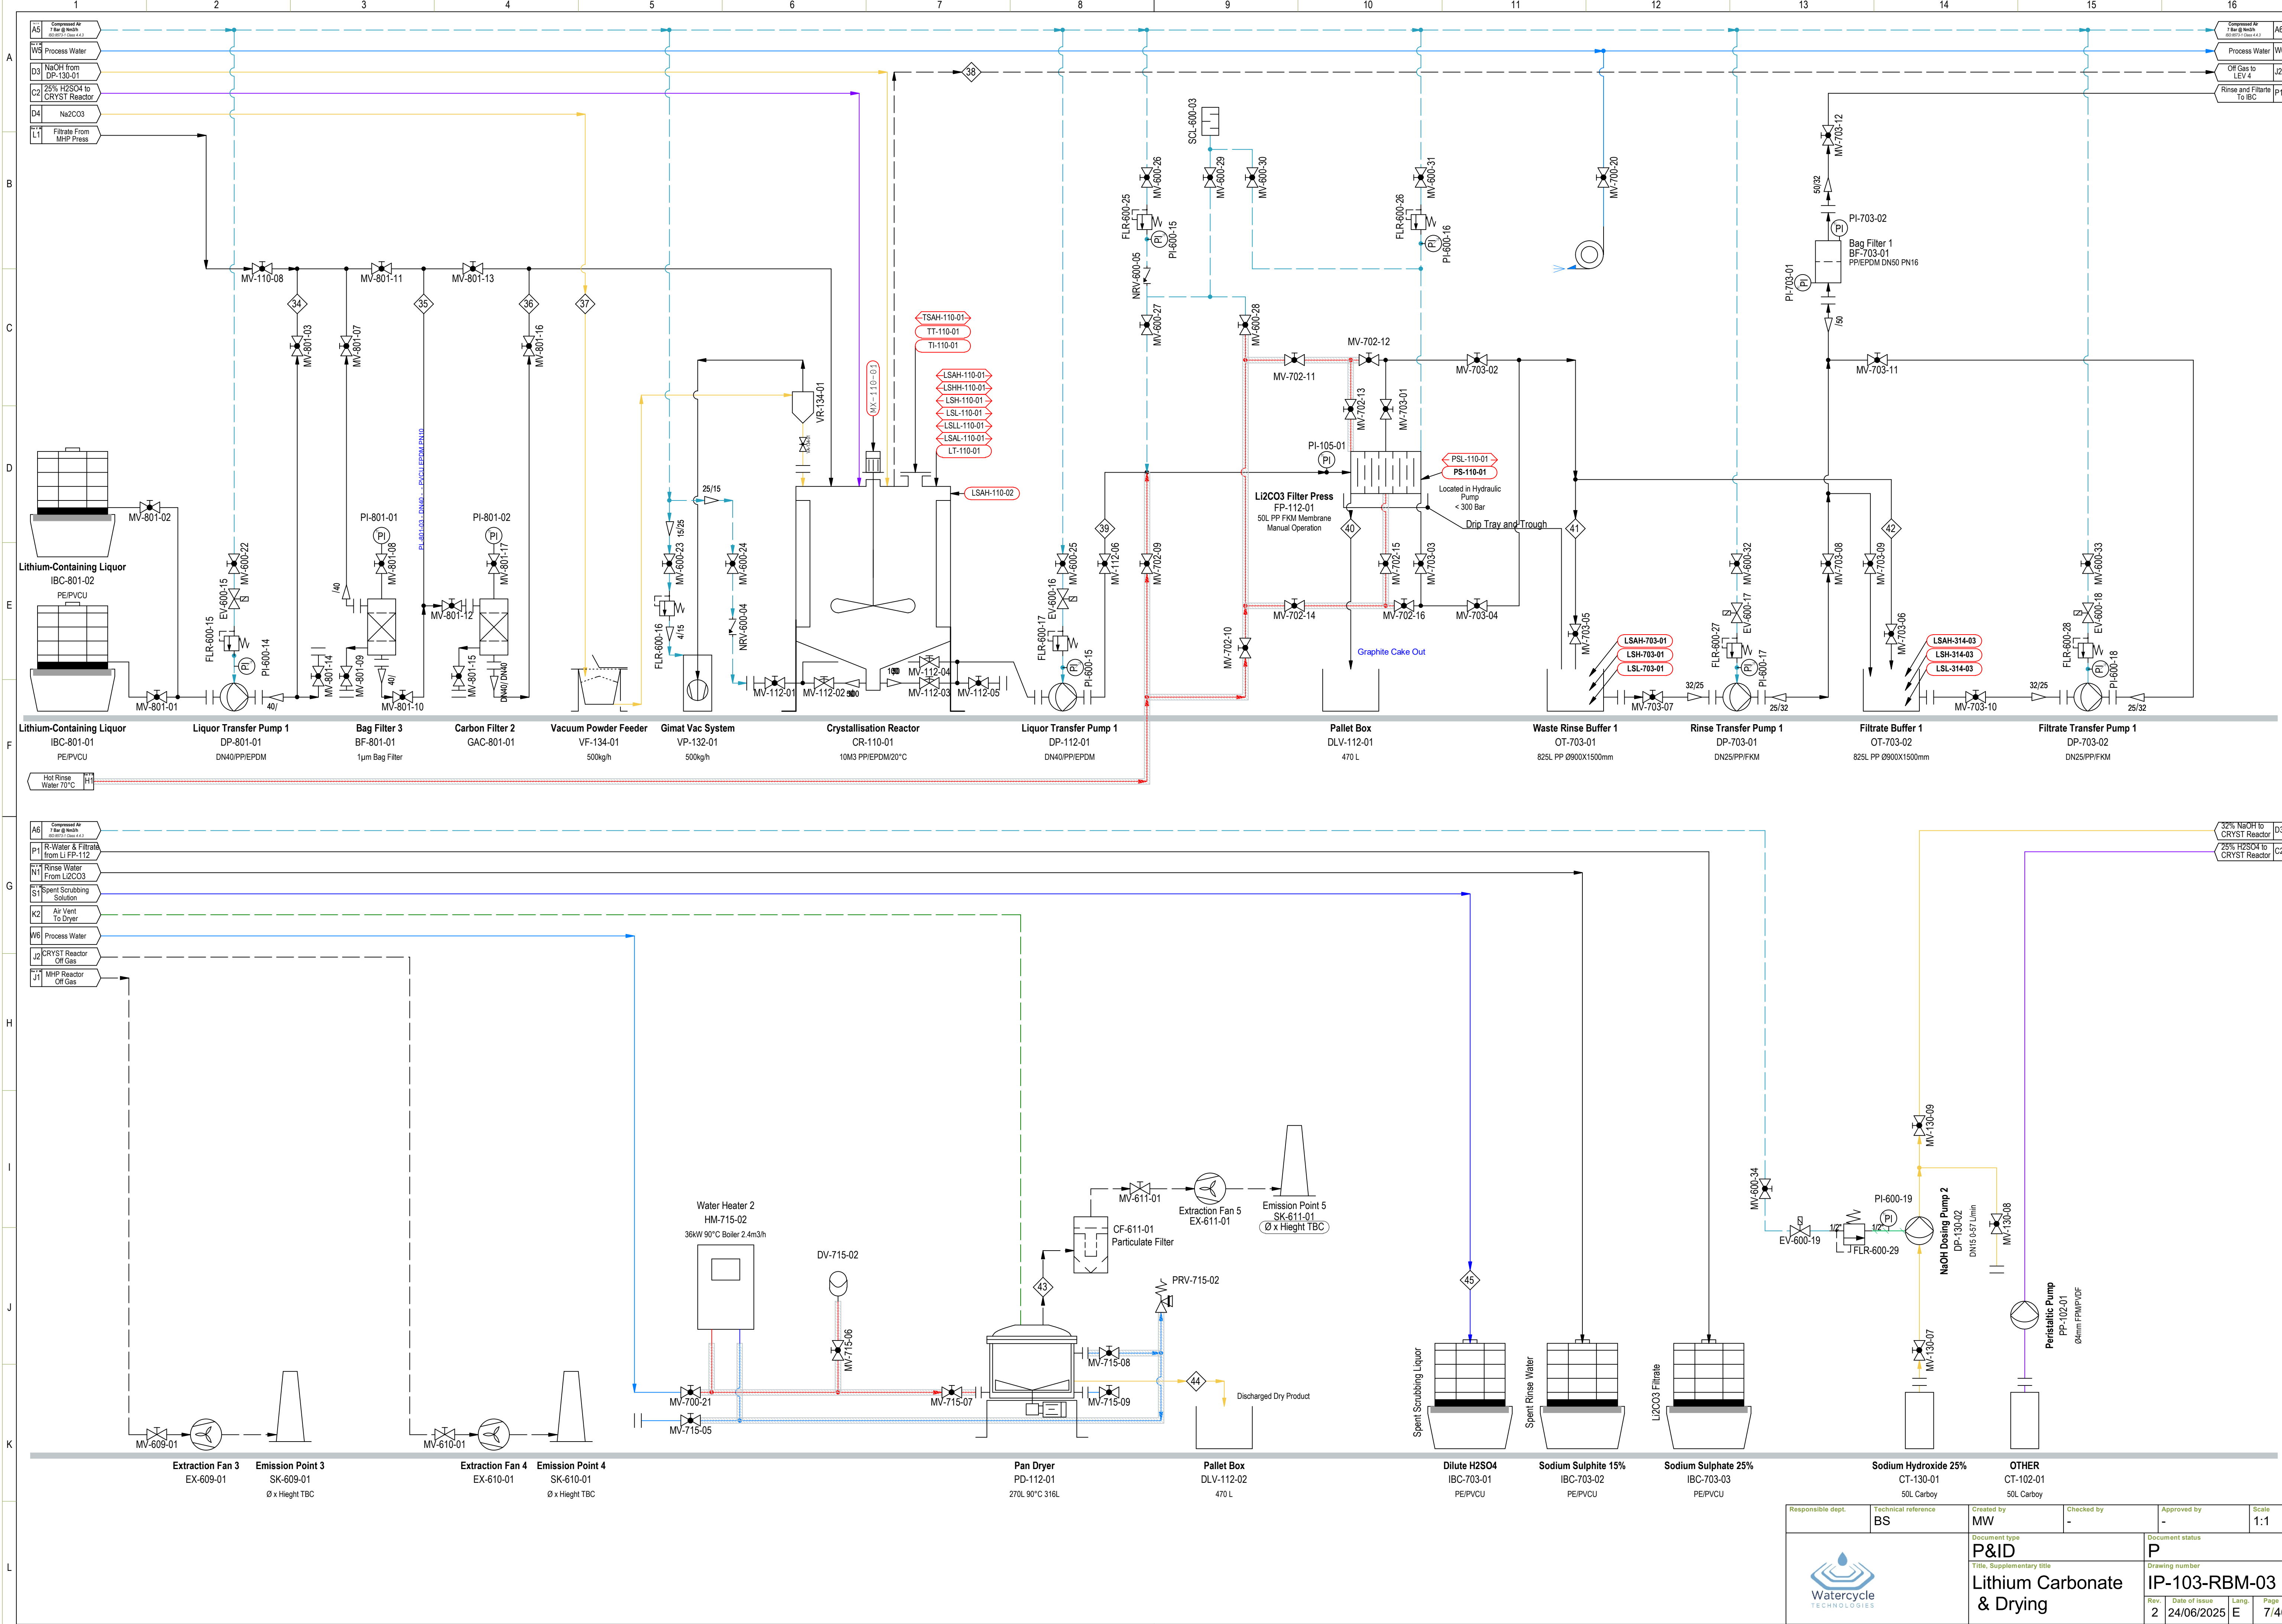

Responsible dept.	Technical reference	Created by	Checked by	Approved by	Scale
	BS	MW	-	-	1:1
Document type		Document status			
P&ID		P			
Title, Supplementary title		Drawing number			
Lithium Carbonate & Drying		IP-103-RBM-03			
Rev.	Date of issue	Lamp.	Page		
2	24/06/2025	E	7/46		