


- NOTES**
- Verifying Dimensions.  
The contractor shall verify dimensions against such other drawings or site conditions as pertain to this part of the work.
  - Existing Services.  
Any information concerning the location of existing services indicated on this drawing is intended for general guidance only. It shall be the responsibility of the contractor to determine and verify the exact horizontal and vertical alignment of all cables, pipes, etc. (both underground and overhead) before work commences.
  - Issue of Drawings.  
Hard copies, dwf and pdf will form a controlled issue of the drawing. All other formats (dwg, dxf etc.) are deemed to be an uncontrolled issue and any work carried out based on these files is at the recipient's own risk. RPS will not accept any responsibility for any errors arising from the use of these files, either by human error by the recipient, listing of un-dimensioned measurements, compatibility issues with the recipient's software, and any errors arising when these files are used to aid the recipient's drawing production, or setting out on site.
  - Datum.

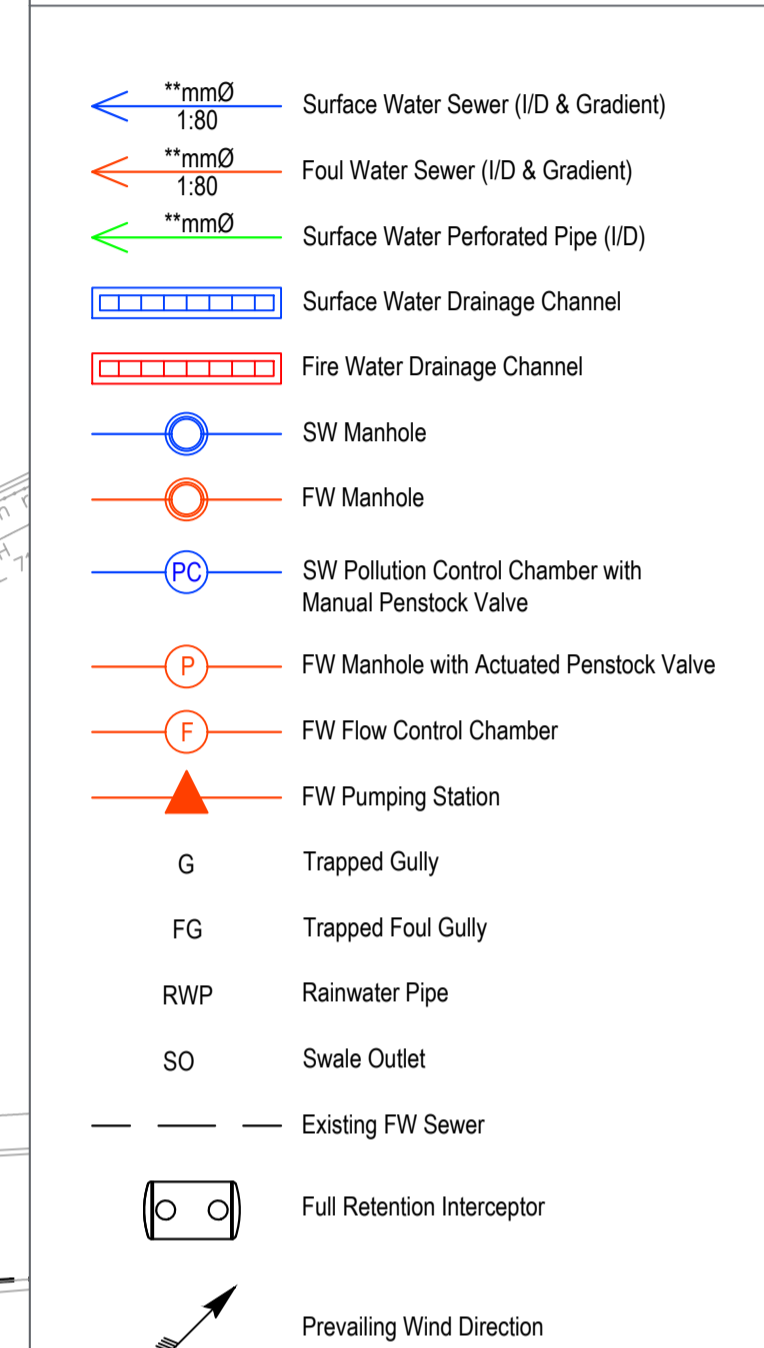

rev	amendments	check	date

**RPS** A TRINA TECH COMPANY  
 Elmwood House  
 74 Boucher Road  
 Belfast  
 BT12 6RZ  
 T +44 (0) 28 90 667914  
 F +44 (0) 28 90 668286  
 W www.rpsgroup.com/ireland  
 E ireland@rpsgroup.com

Client  
**Hertfordshire County Council**

Project  
**Waterdale Shredding Building**

Title  
**Waste Permit - Drainage Layout**

Project Number IBR1405	Sheet Size A1	Drawing Scale 1:200
---------------------------	------------------	------------------------

Drawing Number  
**3001**

Drawn By CMcL	Status Final	Revision -
------------------	-----------------	---------------

Checked By CMcK	Approved By JB	Date 15/03/2025
--------------------	-------------------	--------------------