


THIS INFORMATION CONTAINED HEREIN IS PROPRIETARY INFORMATION AND SHALL NOT BE COPIED AND/OR REPRODUCED IN ANY MANNER, NOR USED FOR ANY PURPOSE WHATSOEVER EXCEPT AS SPECIFICALLY PERMITTED PURSUANT TO WRITTEN AGREEMENT

**T-001**  
Vent Gas Scrubber  
Design: 3 Bar/ 150 °C

**V-001**  
Vent Gas KO Drum  
Design: 1 Bar/ 50 °C  
Size: 600 mm ID X 1800 mm T/T

**F-001**  
Vent Gas Filter System  
Design: 1 Bar/ 50 °C

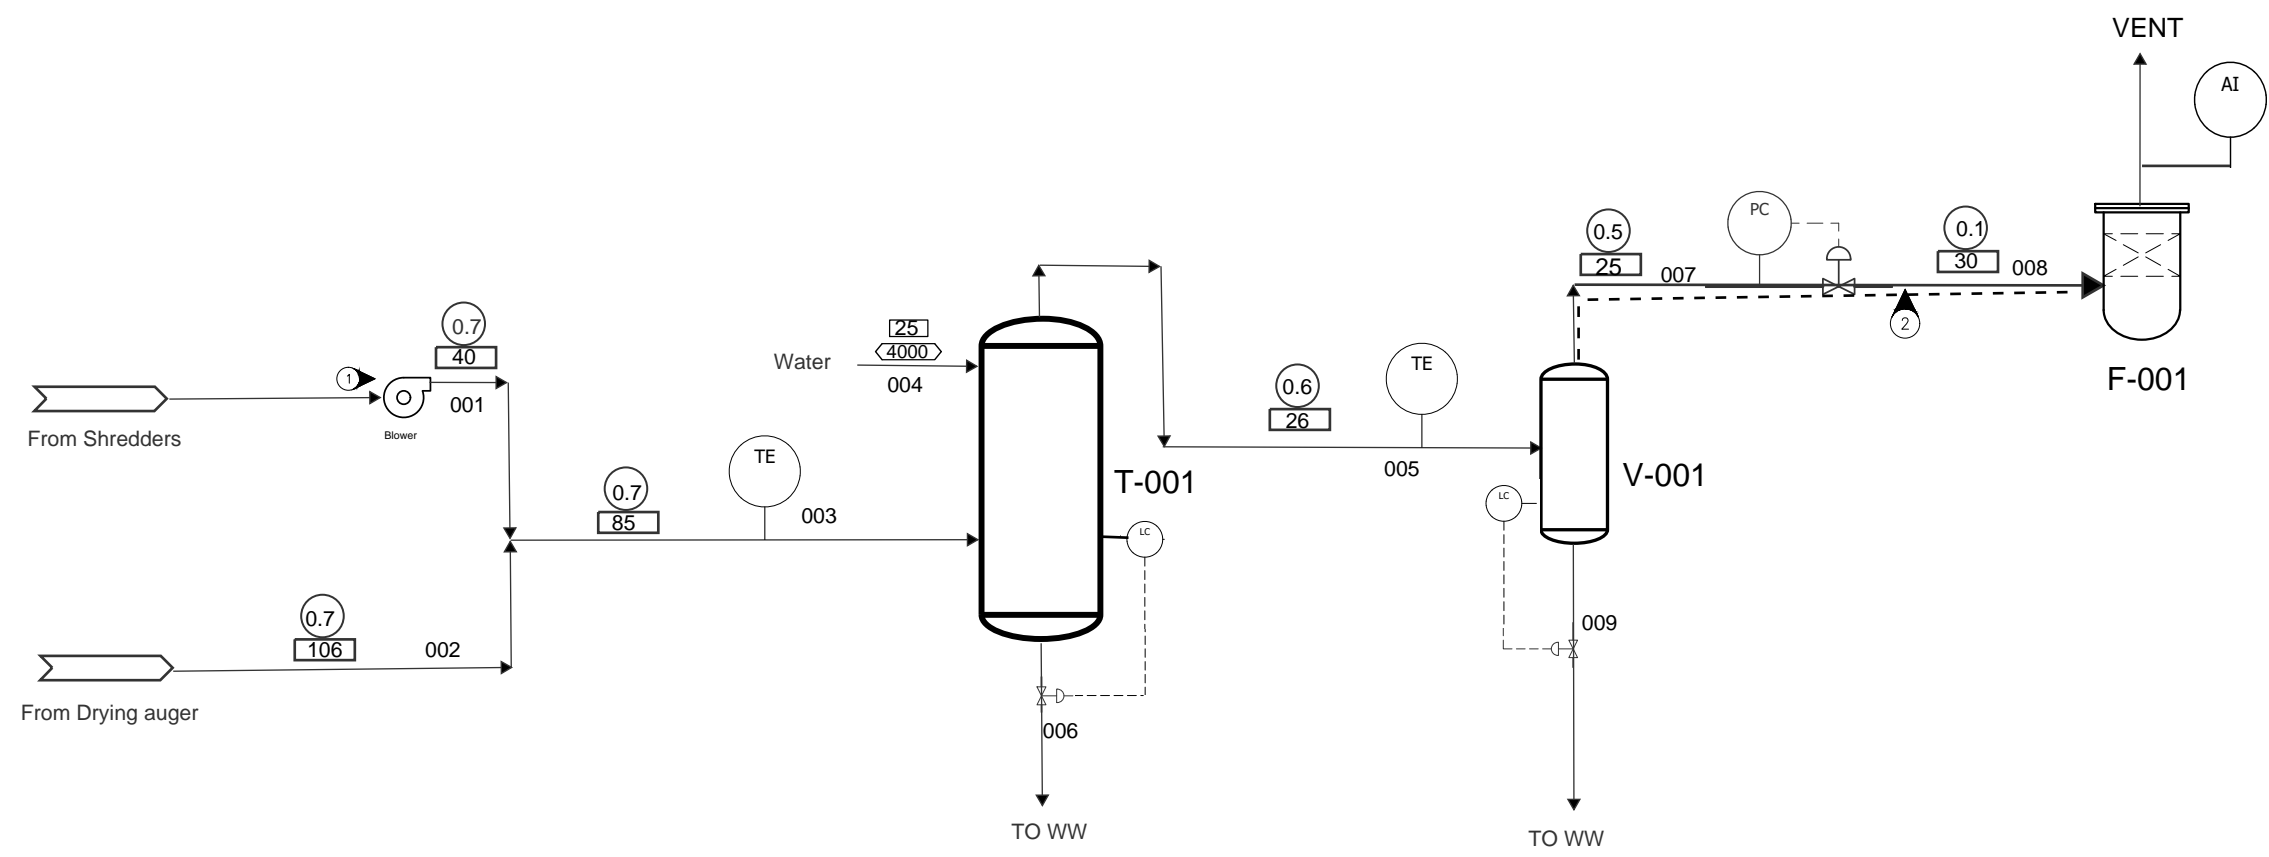

- NOTES:**
1. By others. Not part of study scope.
  2. Line to be electric traced to Keep 30 °C.

**LEGEND:**

XXXX	STREAM NUMBER
XX	PRESSURE, Bar
>XXXX	DUTY, Kcal/hr
<XXXX	FLOW, kg/HR
XXXX	FLOW, M3/Hr
>XXXX	POWER, Watt
>XXXX	STANDARD VOLUME FLOW, SM3/hr
XX	TEMPERATURE, °C

**CONFIDENTIAL**

NO.	DATE	REVISIONS	BY	CK.	APPR.
B	12/09/22	ISSUED FOR INFORMATION	HA	AK	GA
A	10/20/22	ISSUED FOR INFORMATION	HA	AK	DB



DRAWN BY	DATE
CHECKED BY	DATE
APPROVED BY	DATE
COST/SCHEDULE/ AREA	
SCALE	NONE

Texas Firm #8018

Hargrove Associates Inc.  
16300 Katy Freeway, Ste. 300  
Houston, TX 77094  
832.910.8775 - hargrove-epc.com

DRAWING TITLE

**PROCESS FLOW DIAGRAM  
VENT GAS PROCESS  
STUDY**

CONTRACT NO. 2260.220842.10	OWNER NO.
APPROVED BY	DATE
APPROVED BY	DATE
DRAWING NUMBER <b>TBD</b>	REV. <b>B</b>